


NOTES:

- 1/2" SHEETROCK WALLS AND CLGS.
- 1 3/8" X 24" S.C. S PANEL INT. DOORS
- 5/8" SHRK WALLS AND CLG. AT GARAGE
- 4" EXTERIOR WALLS
- INSULATION R13 IN WALLS R38 IN ATTIC
- ADD MIN SPLIT A/C SYSTEM AT SCREENED PORCH
- ALL DECKING MATERIAL TO BE TREX
- TREATED SUPPORT MATERIAL CAPPED WITH ICE AND WATER SHIELD
- AT ALL EXTERIOR DECKING
- WINDOWS TO MATCH EXISTING (1/2" PLYWOOD SHEETS CUT AND LABELED TO FIT EACH WINDOW
- STORED IN GARAGE)
- CEILING OF PORCHES, SCREENED PORCH, AND CARPORT TO BE PAINTED V-GROOVE PINE (PRIME BOTH SIDES BEFORE INSTALL)
- ALL HOSE BIBS TO HAVE BACK FLOW PREVENTER

EXISTING SQUARE FOOTAGE	
FIRST FLOOR	1455
SECOND FLOOR	972
TOTAL LIVING	1387
PORCH	
GARAGE	320
TOTAL COV. AREA	2442
PROPOSED SQUARE FOOTAGE	
FIRST FLOOR	1502
SECOND FLOOR	1442
TOTAL LIVING	3244
PORCH	
GARAGE	320
CARPORIT	1274
TOTAL COV. AREA	5158

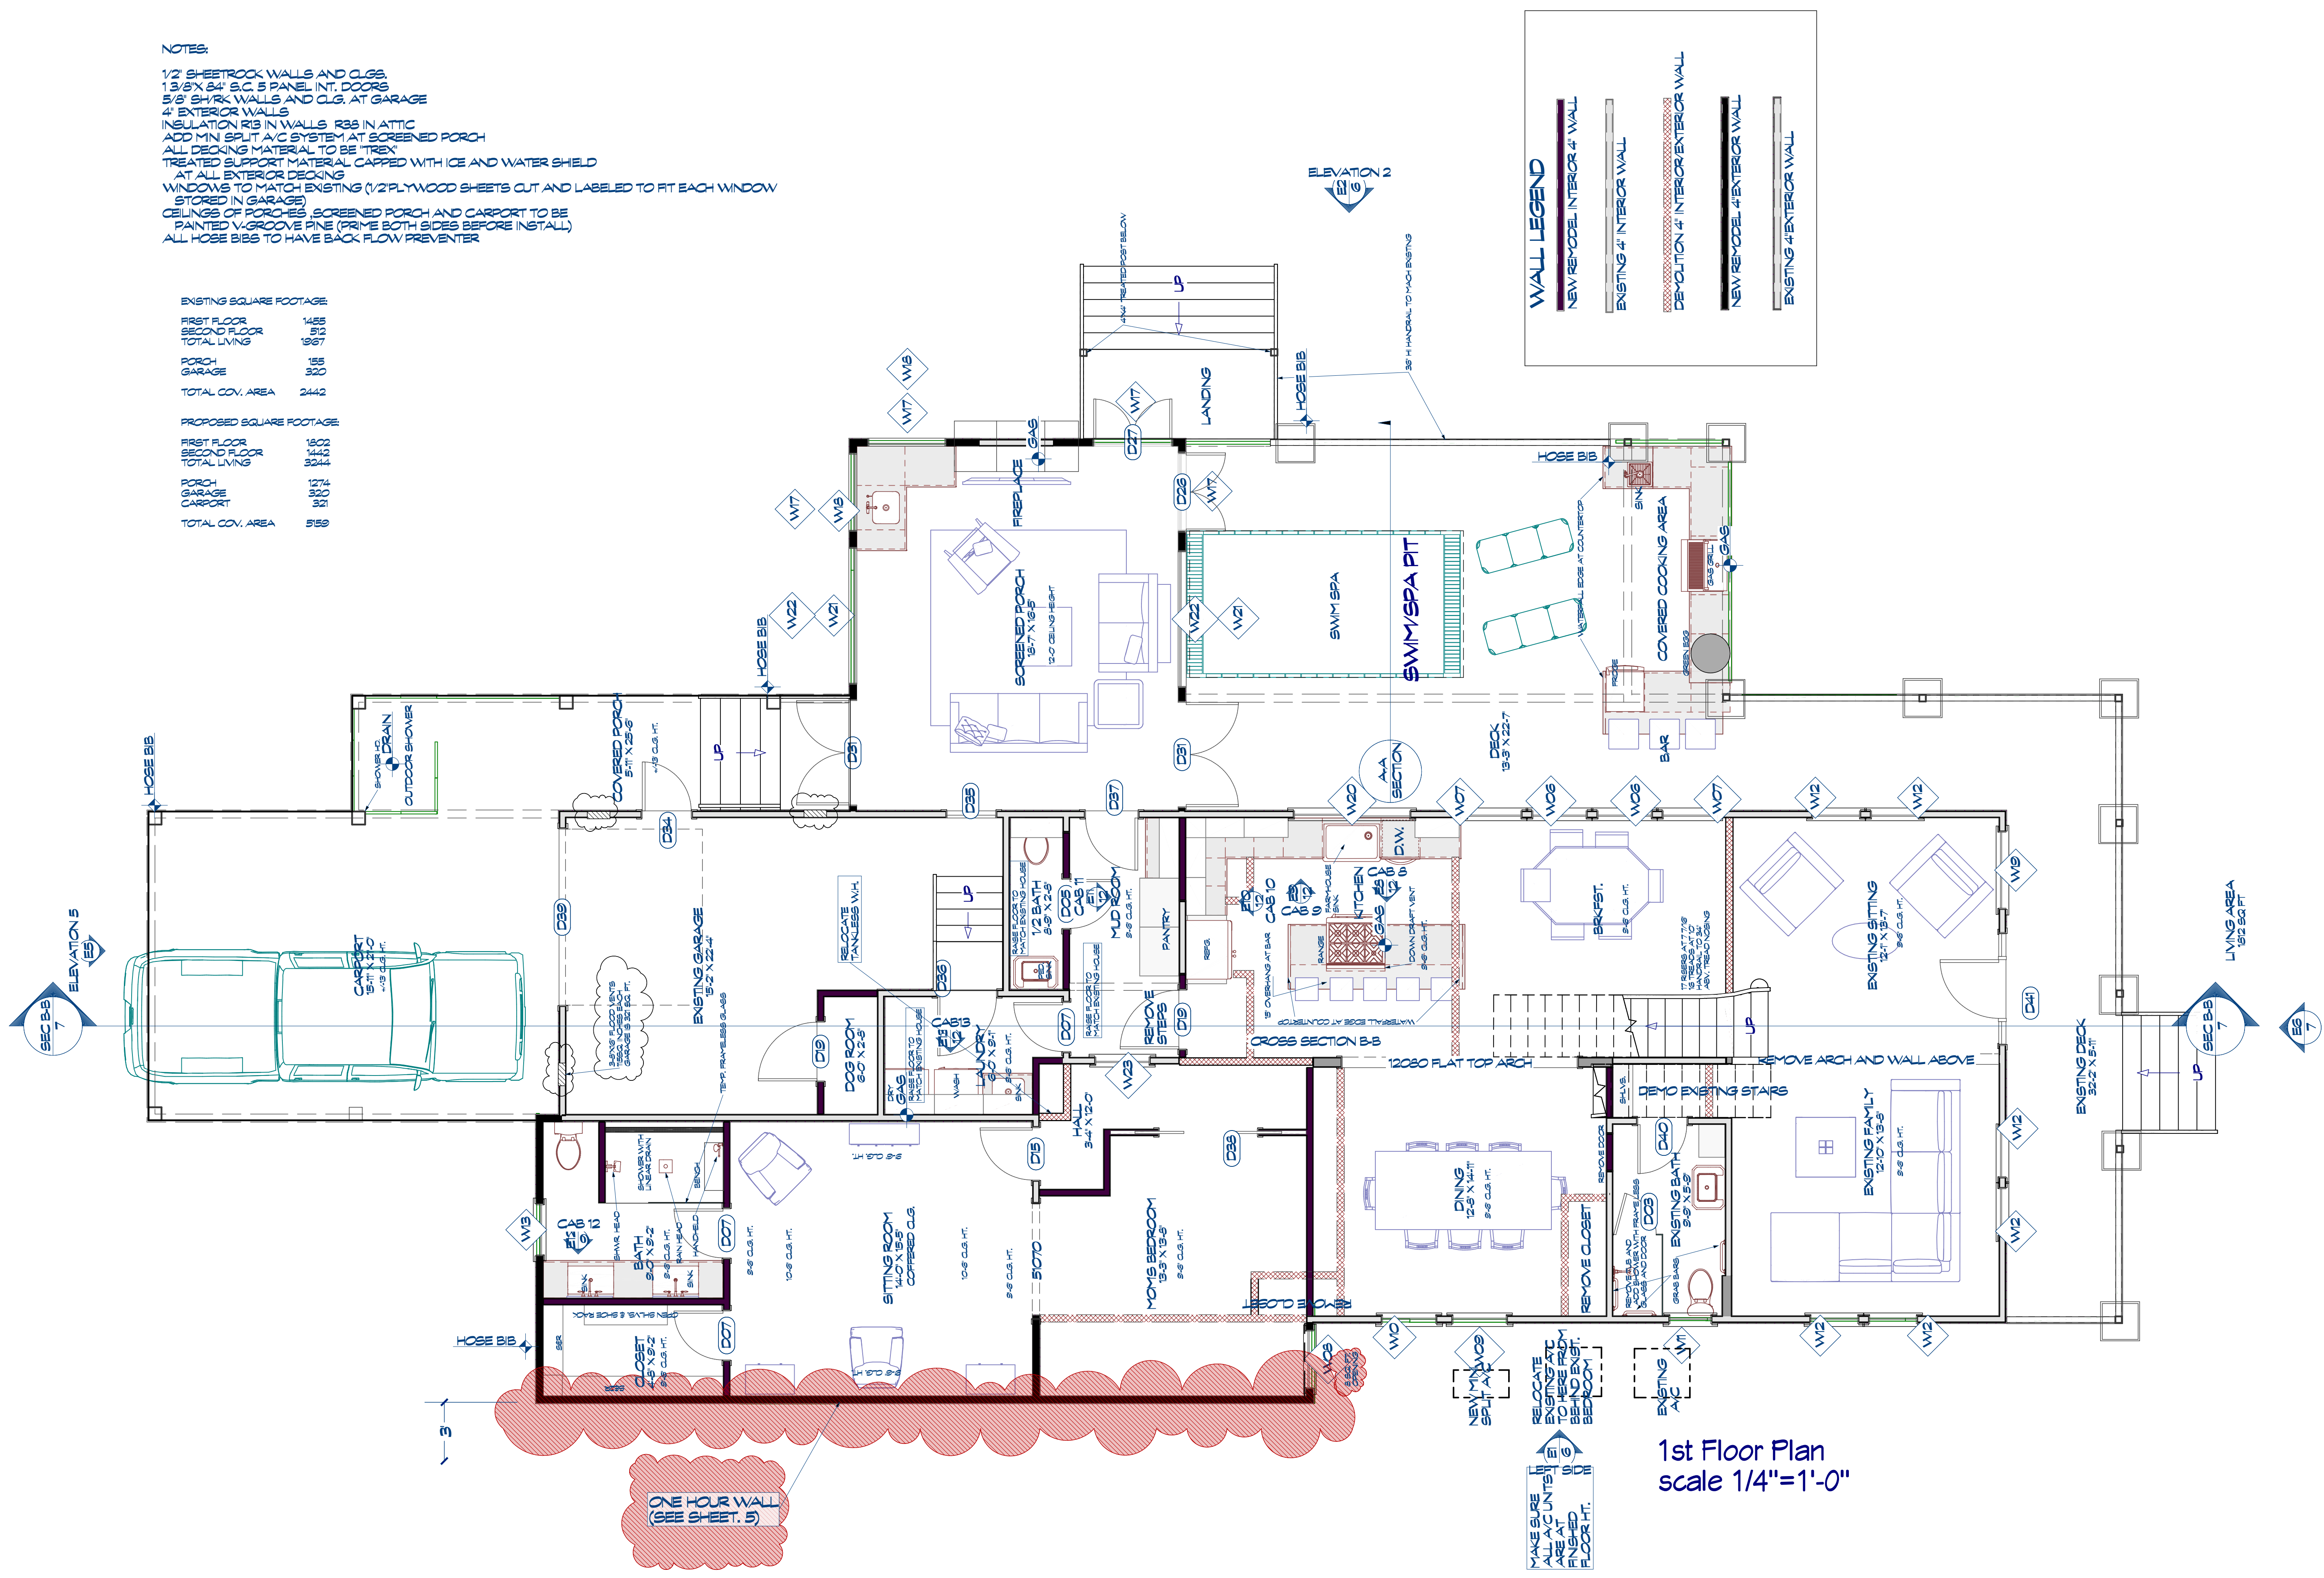


WALL LEGEND

- NEW REMODEL INTERIOR 4" WALL
- EXISTING 4" INTERIOR WALL
- DEMOLITION 4" INTERIOR EXTERIOR WALL
- NEW REMODEL 4" EXTERIOR WALL
- EXISTING 4" EXTERIOR WALL

1st Floor Plan
 scale 1/4"=1'-0"

800 Wilcrest Dr. suite 120
 Houston, Texas 77042
 Office 713-759-8262
 Cell 713-806-1998

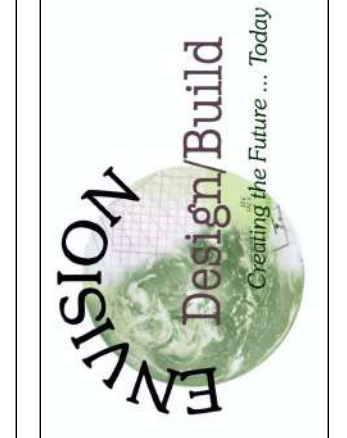


DRAWINGS PROVIDED BY:

DATE:
 2/8/2023


SCALE:
 1/4"=1'-0"

SHEET:

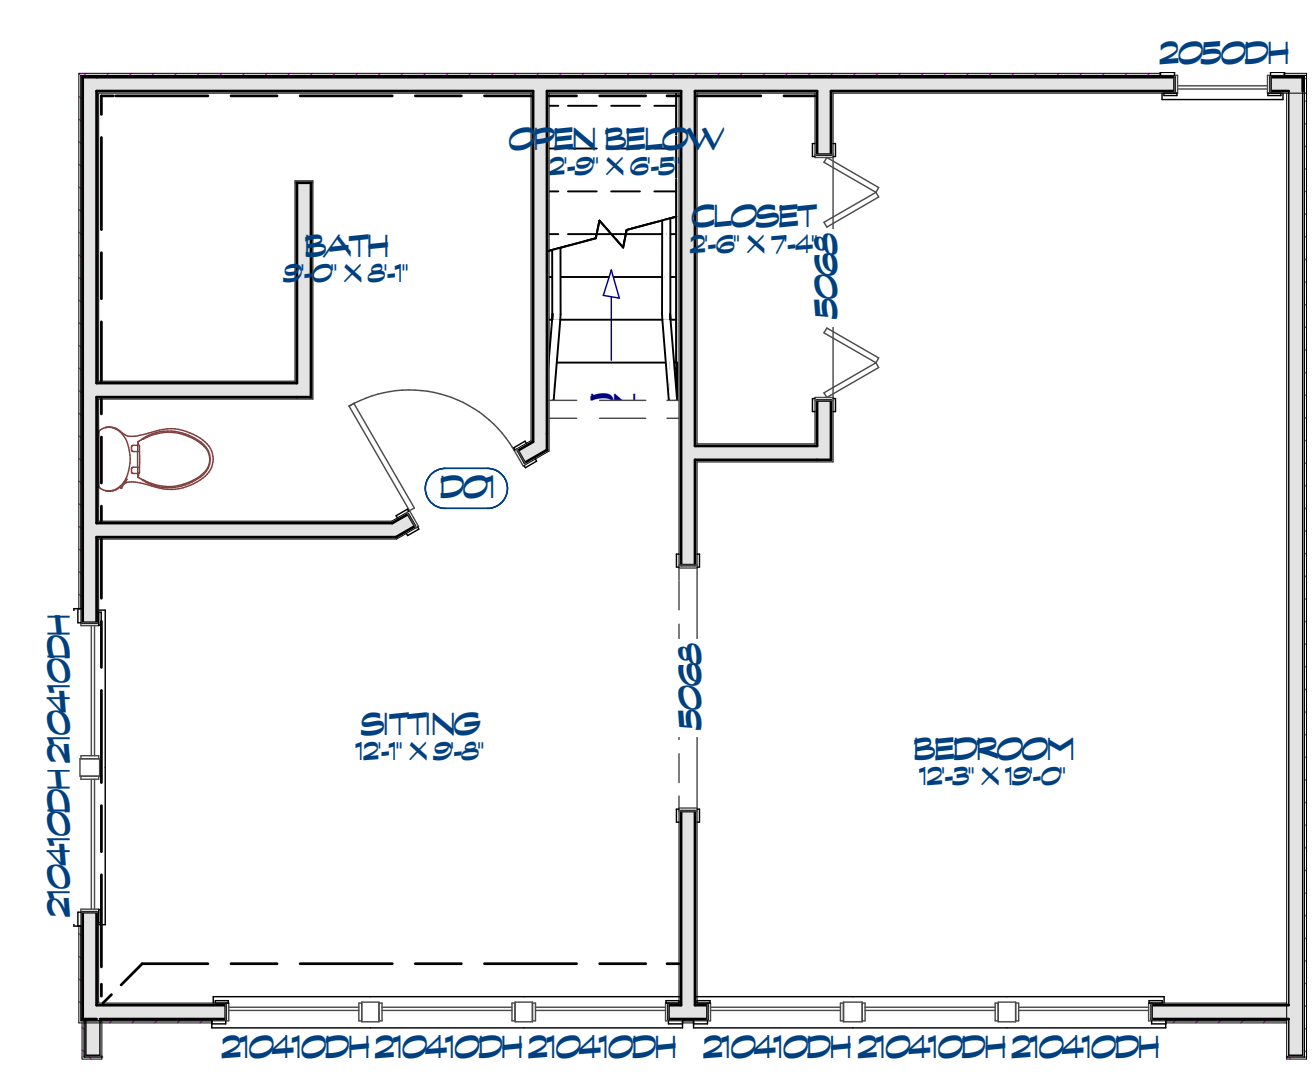

As-Built Second Floor Plan
 scale 1/4"=1'-0"


SQUARE FOOTAGE 512

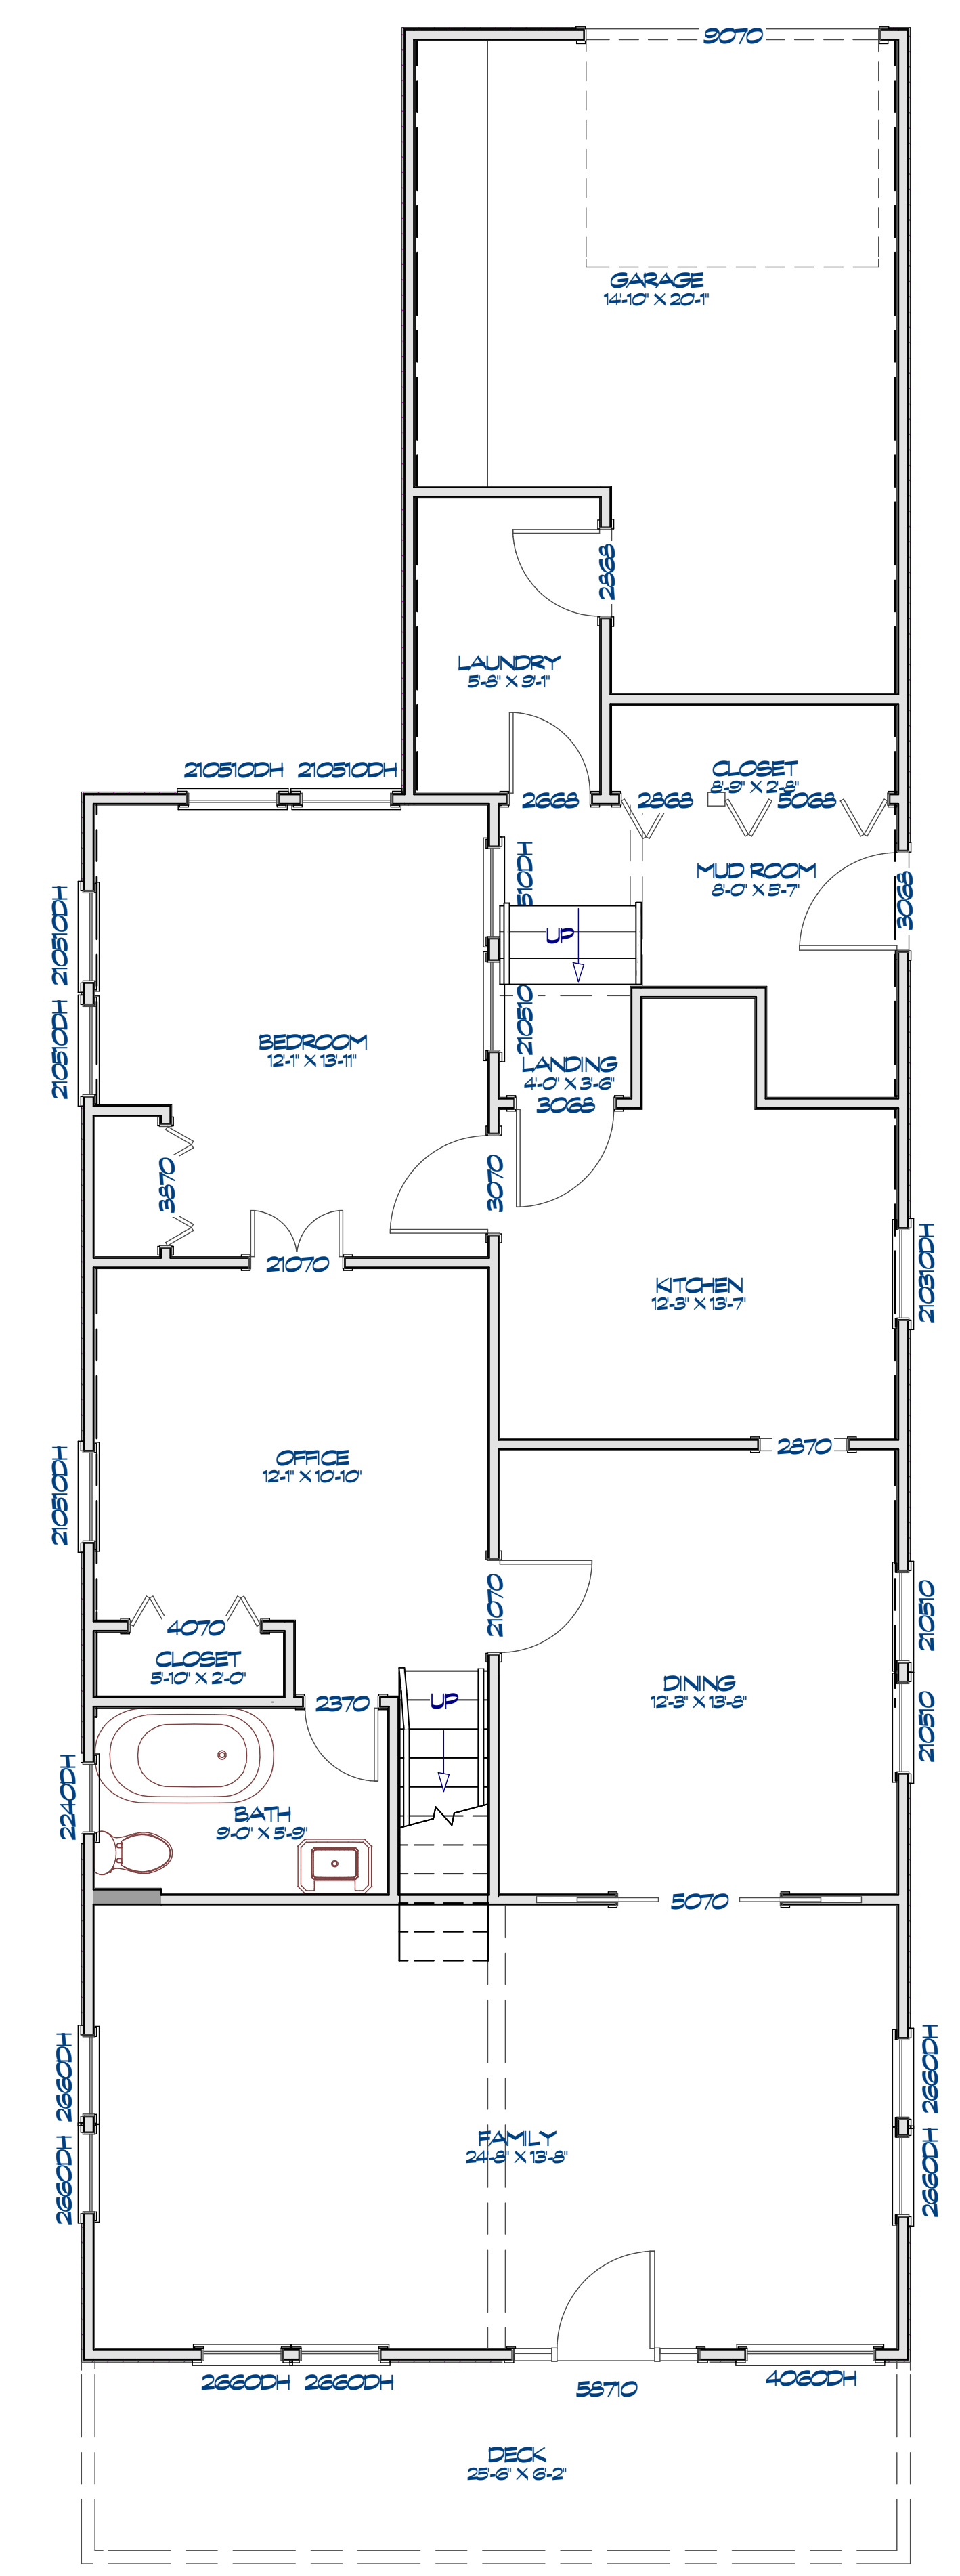

As-Built First Floor Plan
 scale 1/4"=1'-0"

SQUARE FOOTAGE 1485

800 Wilcrest Dr. suite 120
 Houston, Texas 77042
 Office 713-759-8062
 Cell 713-806-1998

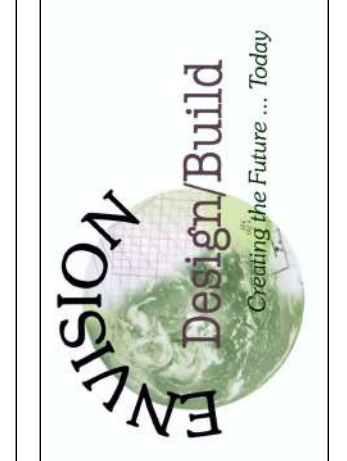

DRAWINGS PROVIDED BY:

DATE:

2/8/2023


SCALE:

1/4"=1'-0"


SHEET:



DETAIL OF ONE HOUR WALL

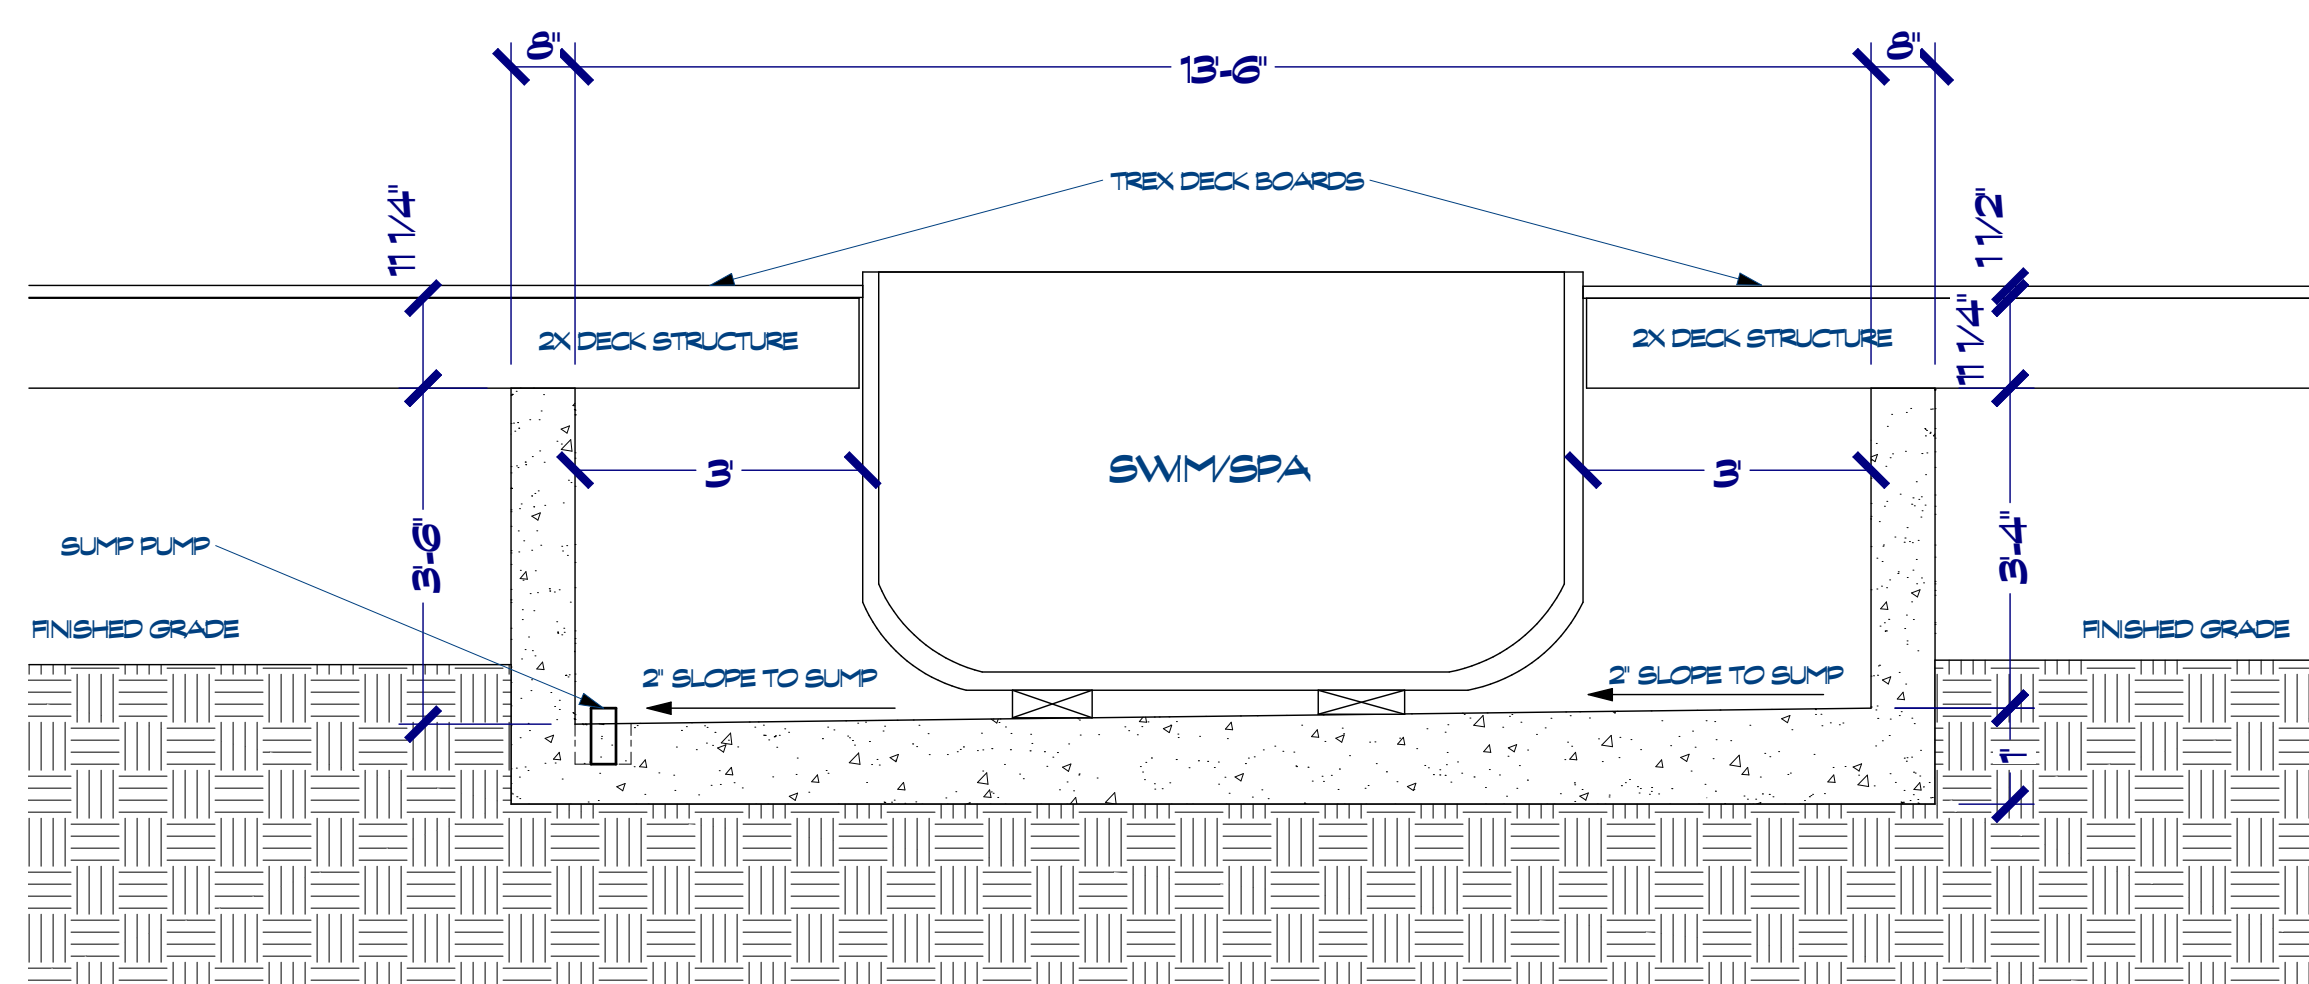

SECTION A-A
 scale 1/2"=1'-0"

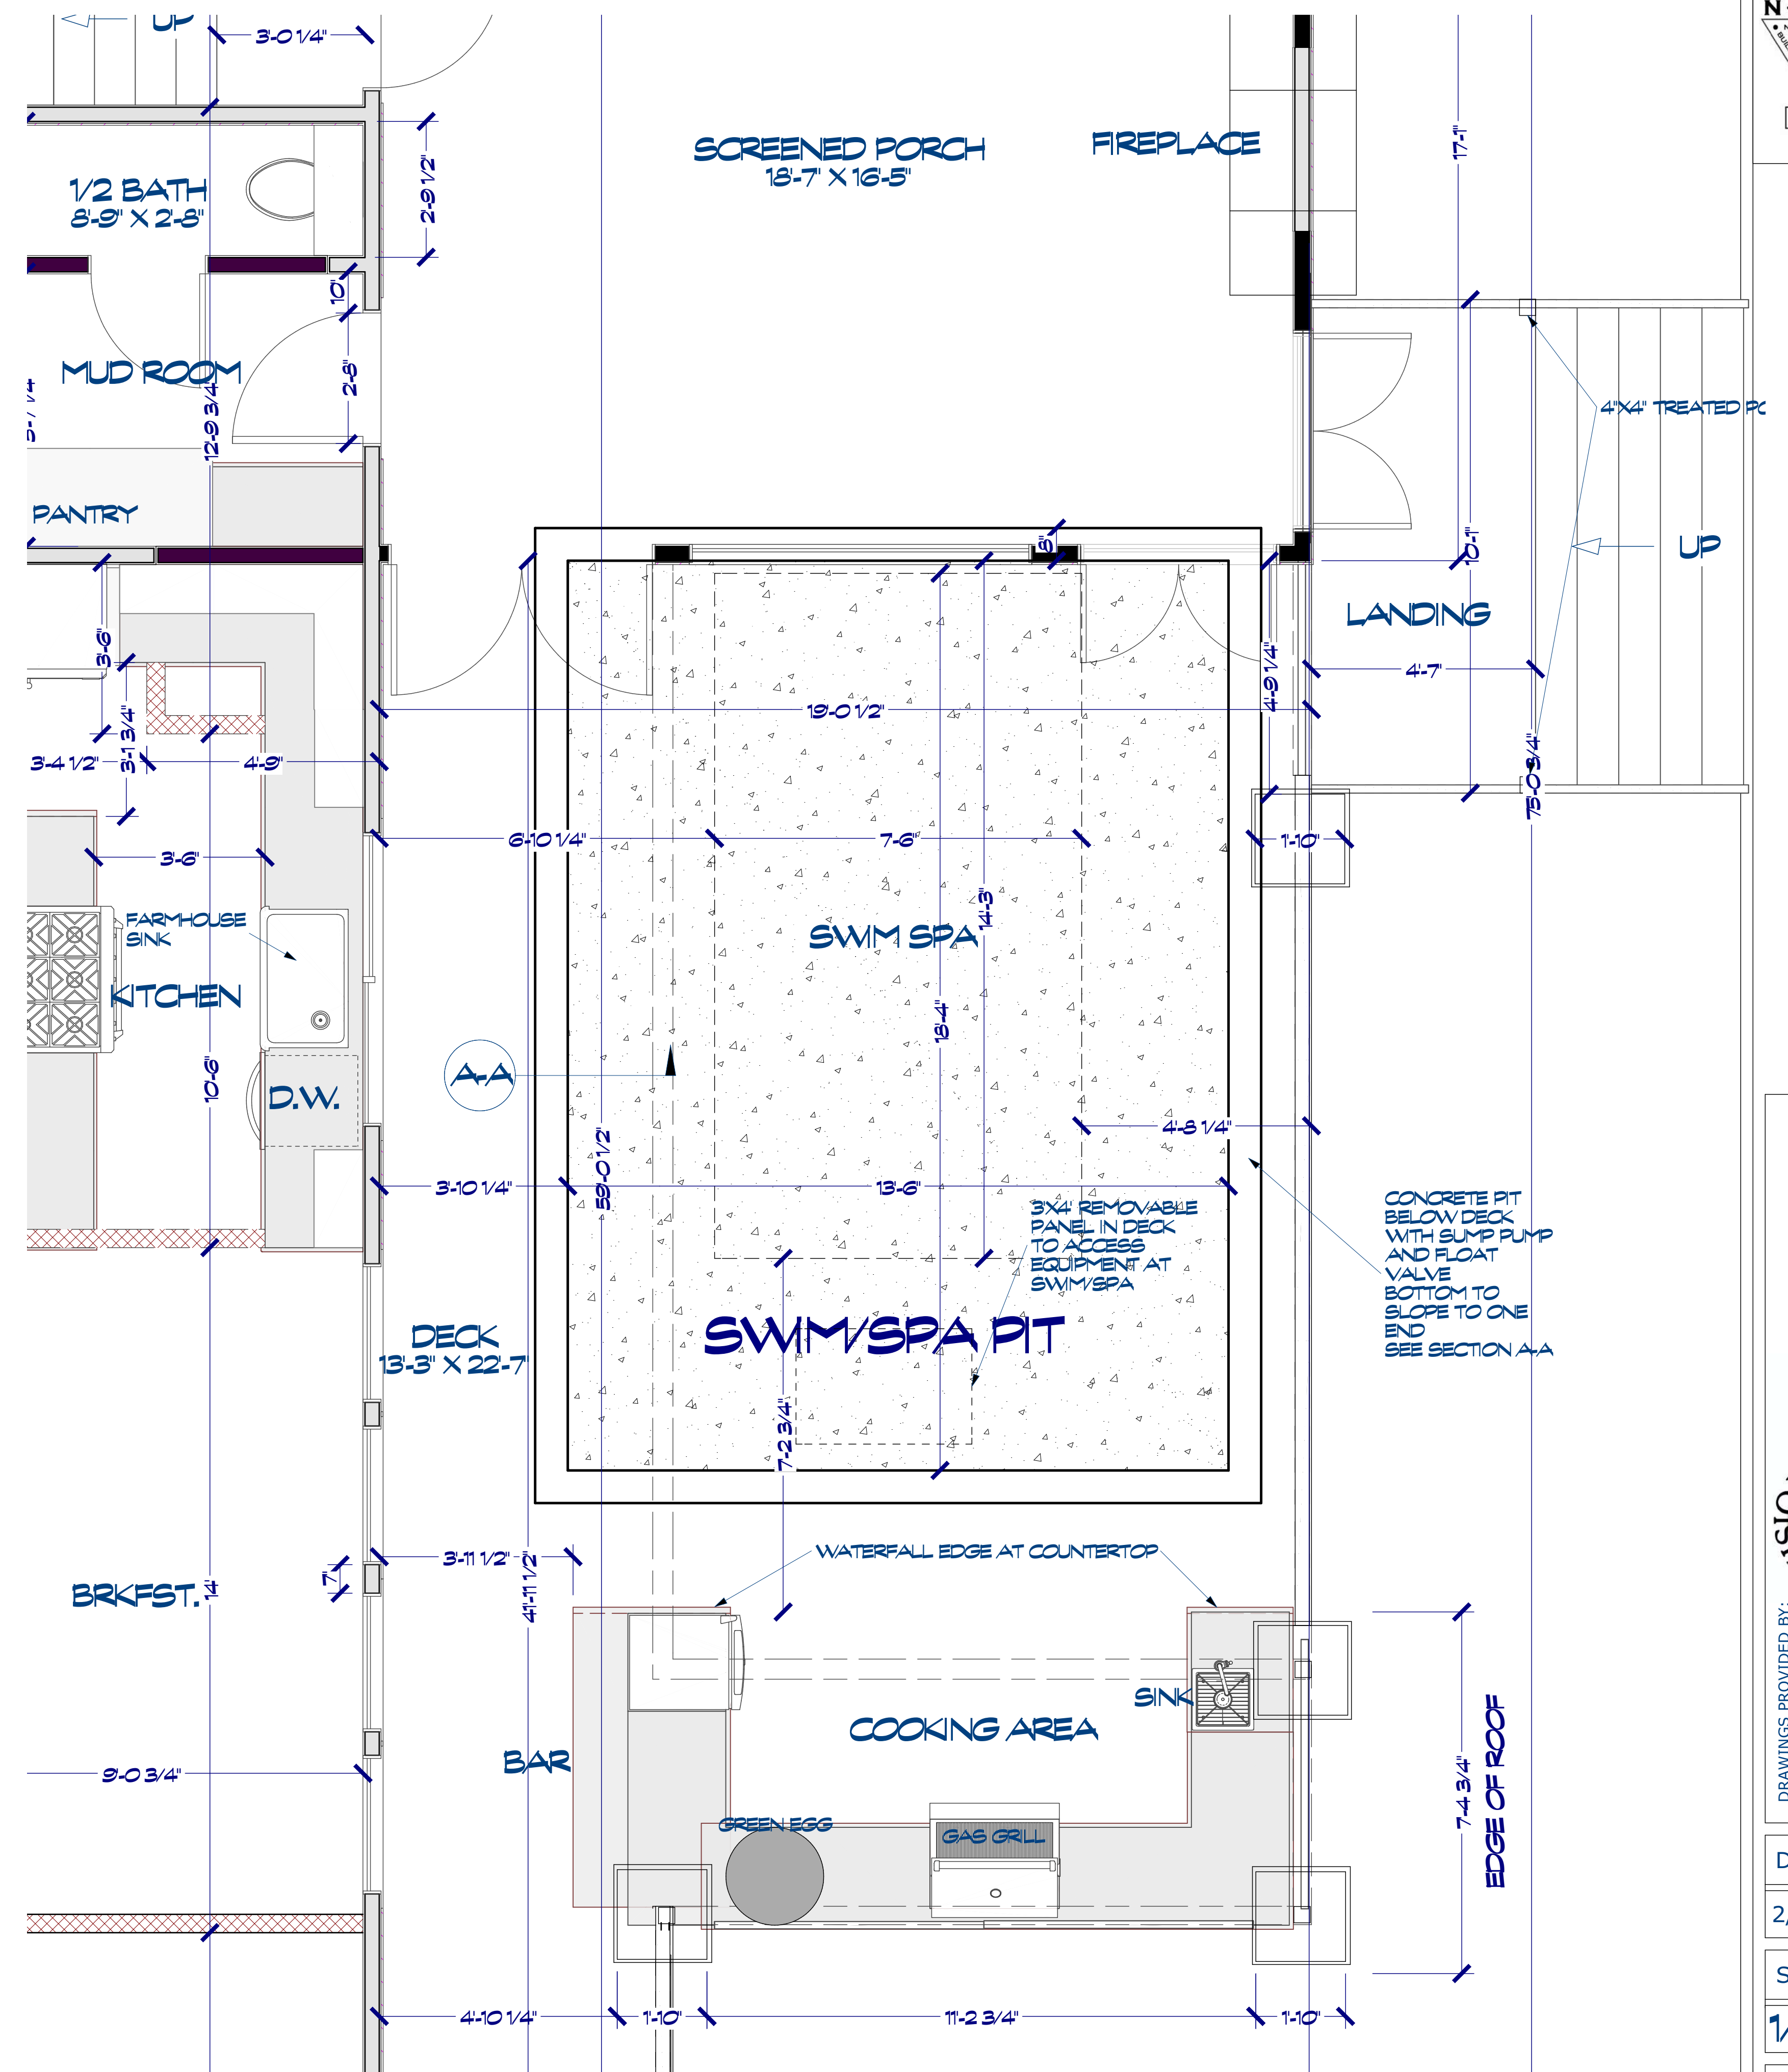

PIT AT SWIM/SPA
 SCALE 1/2"=1'-0"

800 Wilcrest Dr. suite 120
 Houston, Texas 77042
 Office 713-759-8022
 Cell 713-806-1998

ENVISION
 Design/Build
 Creating the Future... Today

DRAWINGS PROVIDED BY:

DATE:


2/8/2023

SCALE:

1/4"=1'-0"

SHEET:

A-5

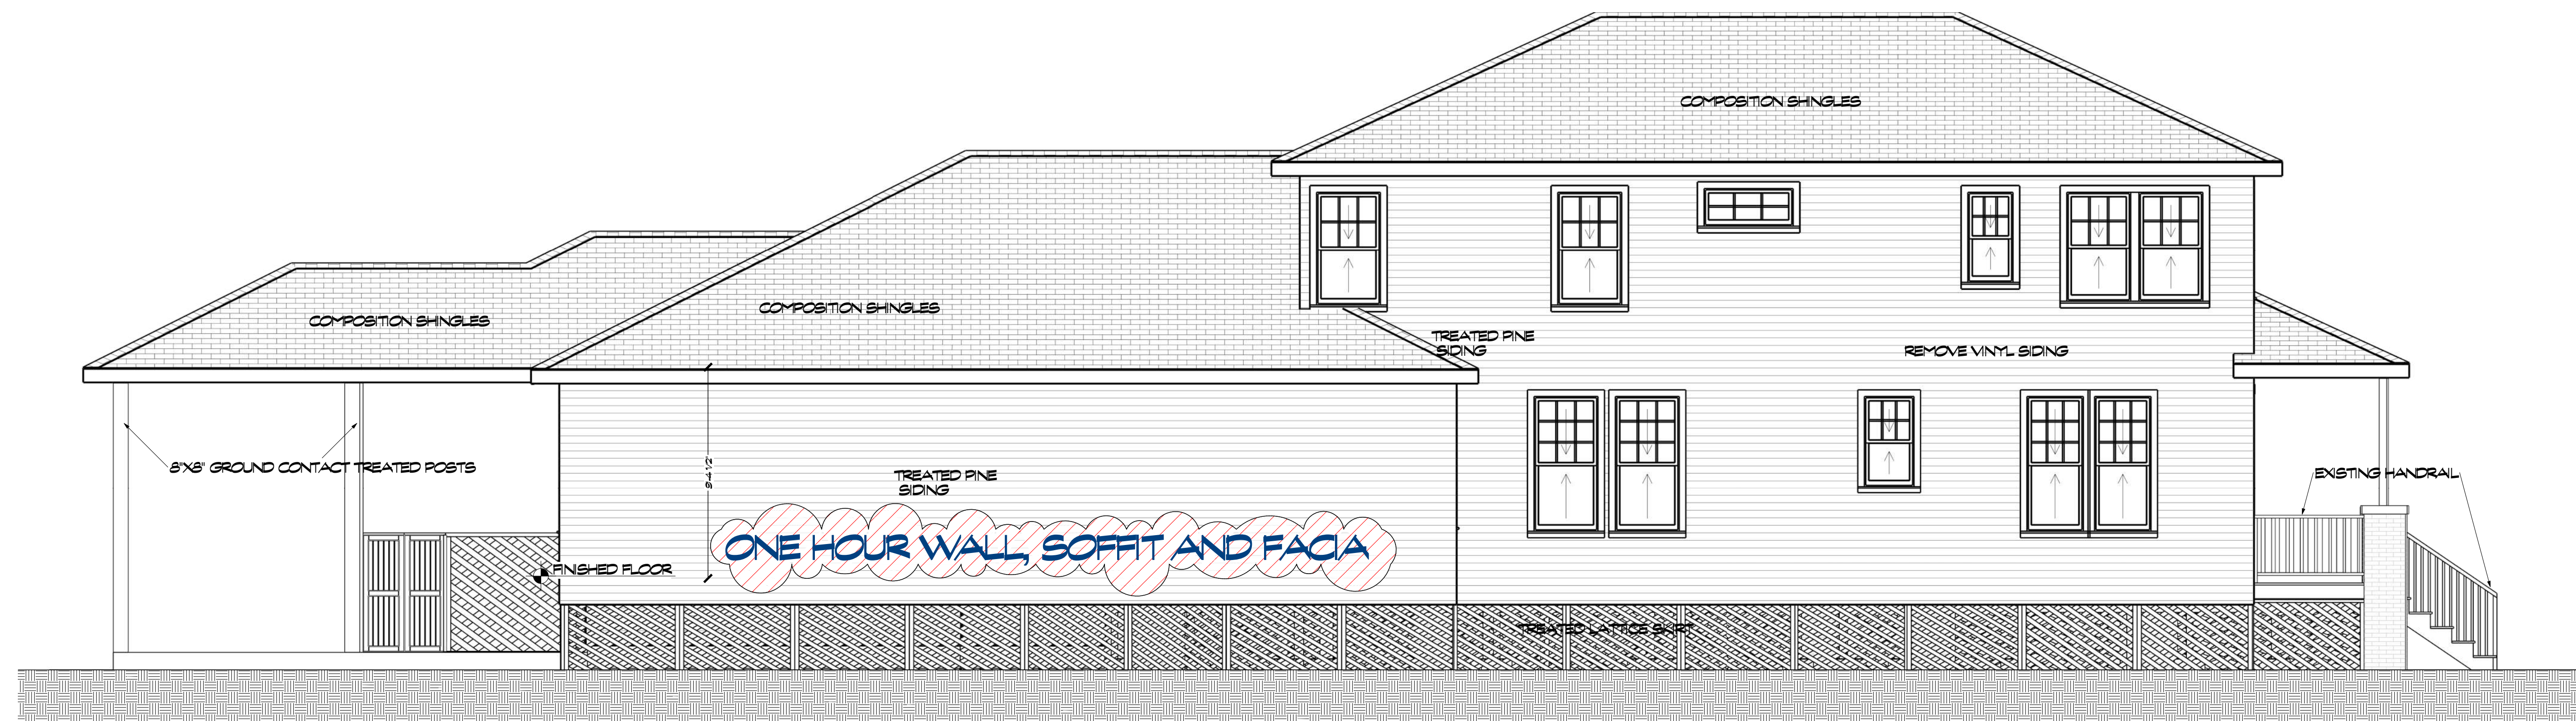

LEFT SIDE

E1



RIGHT SIDE

E2

800 Wilcrest Dr. Suite 120
 Houston, Texas 77042
 Office 713-759-8262
 Cell 713-806-1998

ENVISION
 Design/Build
 Creating the Future... Today

DRAWINGS PROVIDED BY:

DATE:

2/8/2023

SCALE:

1/4"=1'-0"

SHEET:


AG



FRONT ELEVATION



REAR ELEVATION

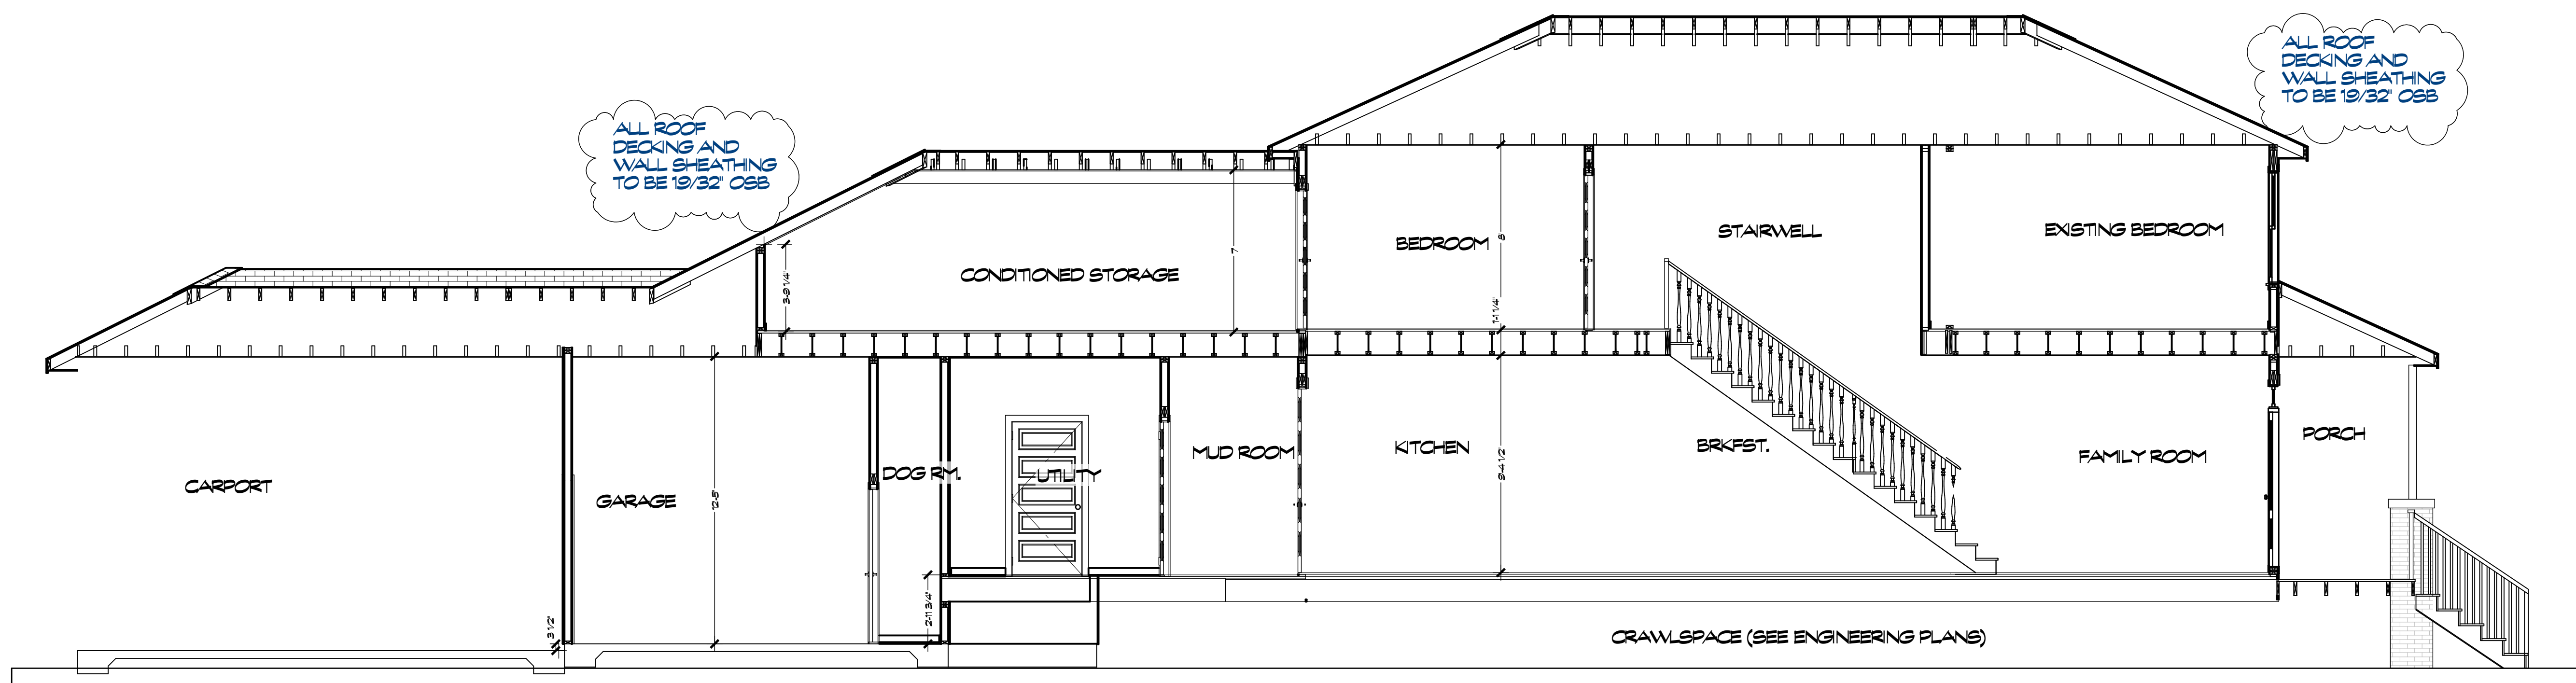

Cross Section B-B

EG

E7

800 Wilcrest Dr., Suite 120
 Houston, Texas 77042
 Office 713-759-8022
 Cell 713-806-1998

ENVISION
 Design/Build
 Creating the Future... Today

DRAWINGS PROVIDED BY:

DATE:


2/8/2023

SCALE:


1/4"=1'-0"

SHEET:


A-7

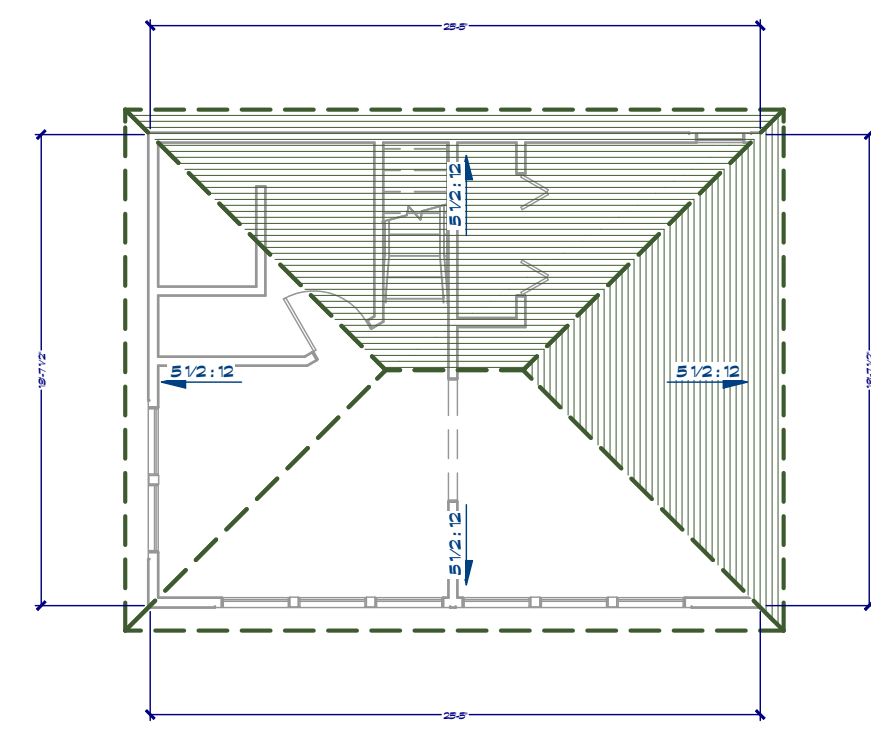


As-Built 2nd Flr. Roof Plan View
 scale 1/8"=1'-0"

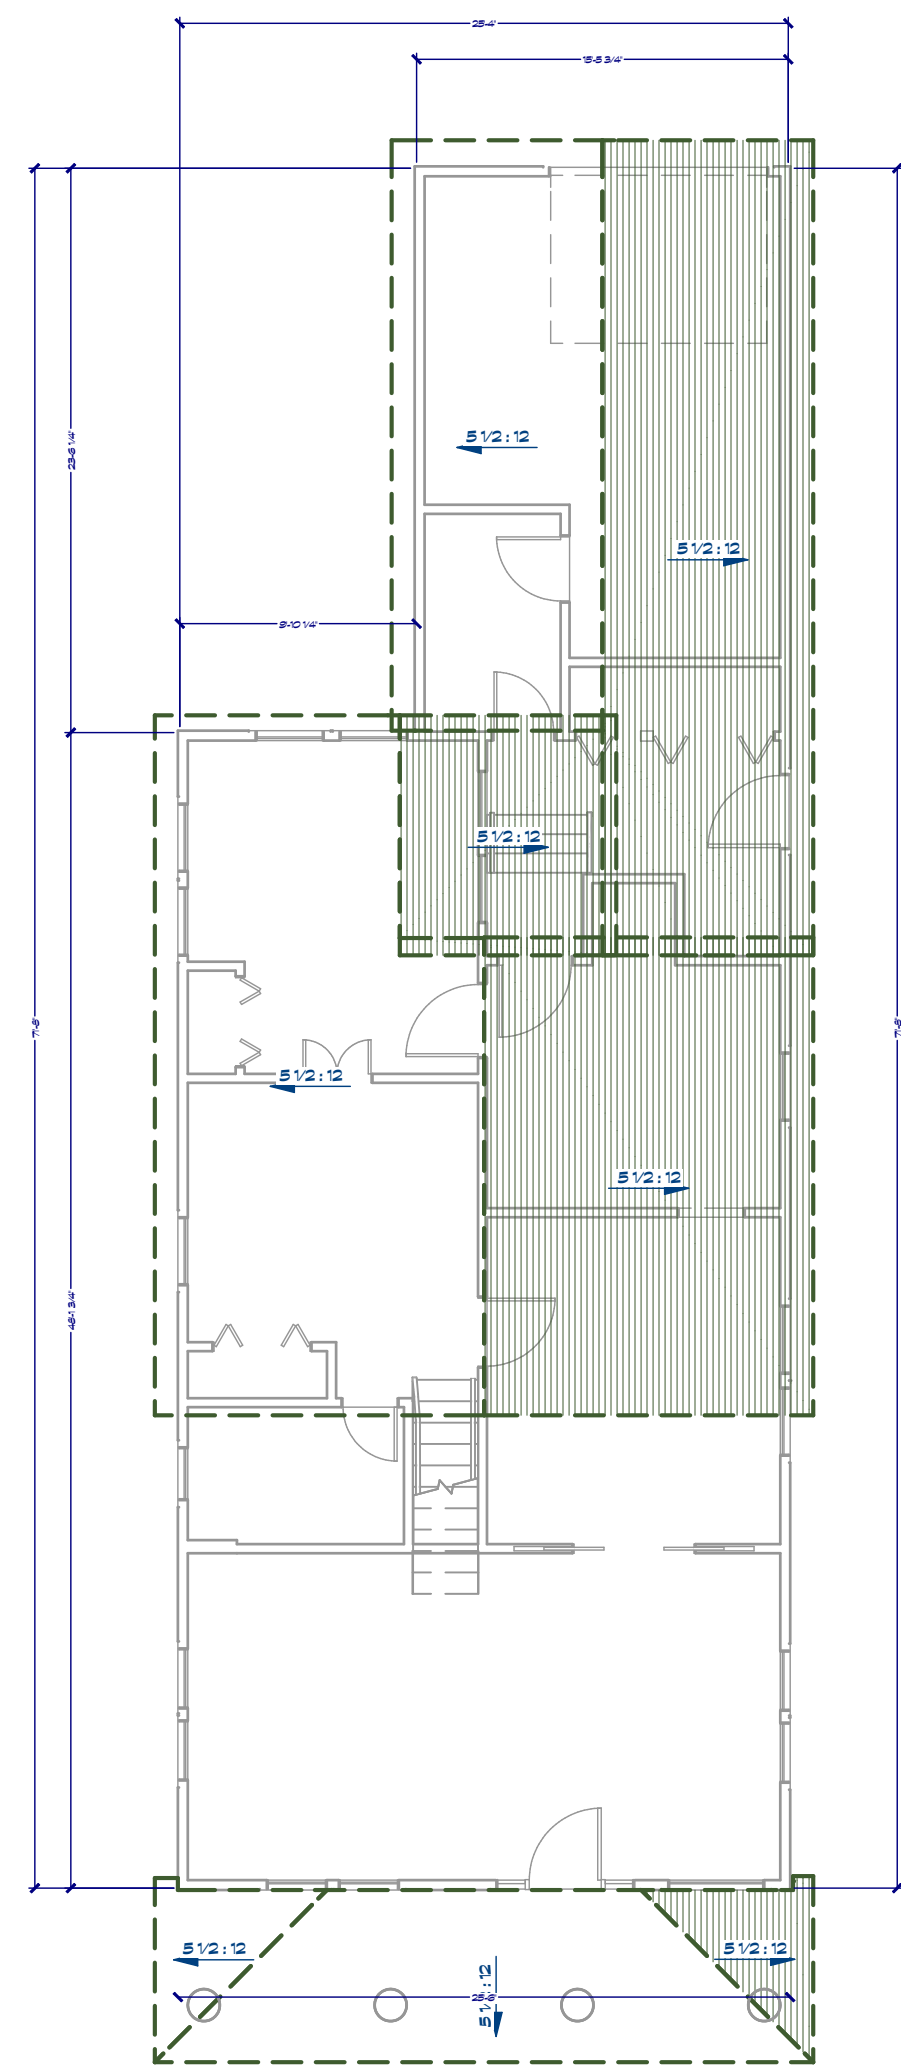

As-Built 1st Flr. Roof Plan View
 scale 1/8"=1'-0"

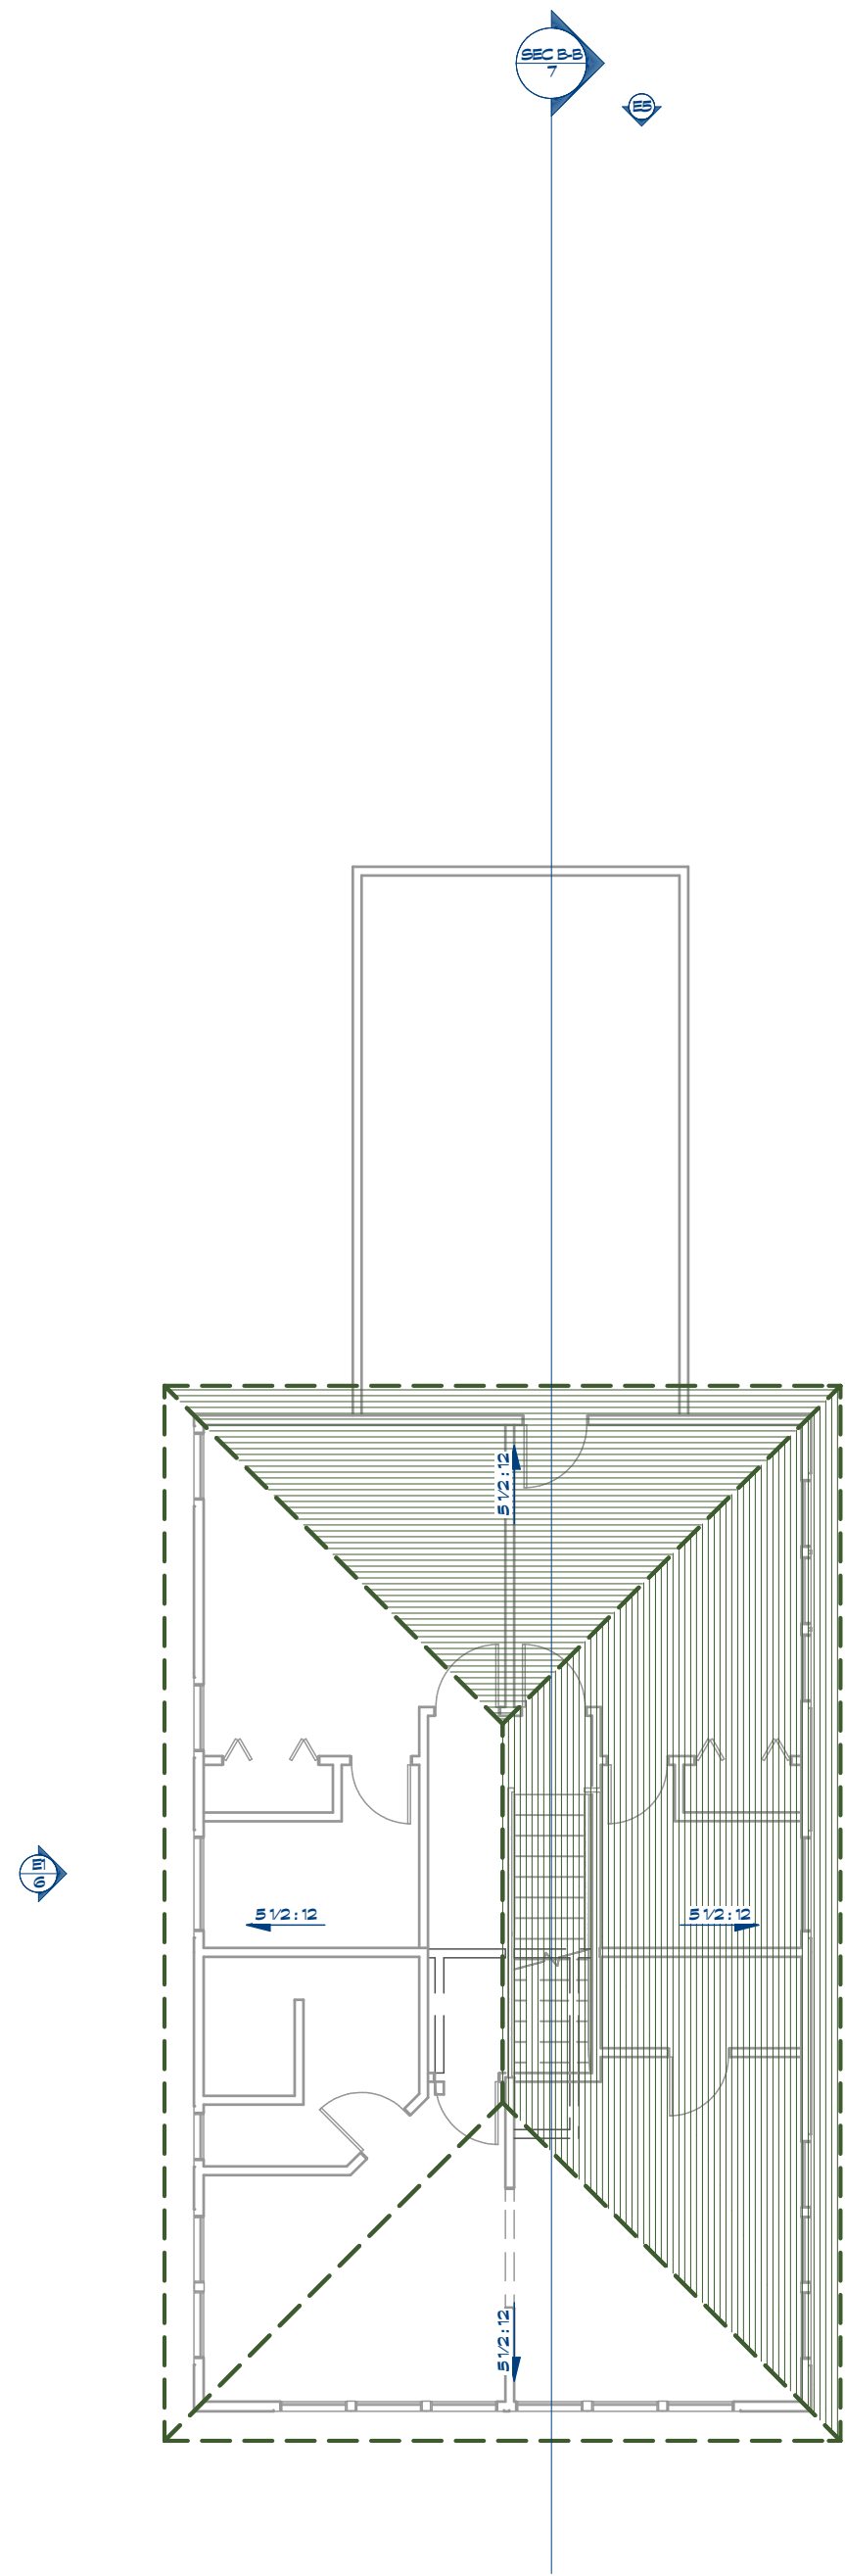

2nd Floor remodeled roof plan
 scale 1/8"=1'-0"

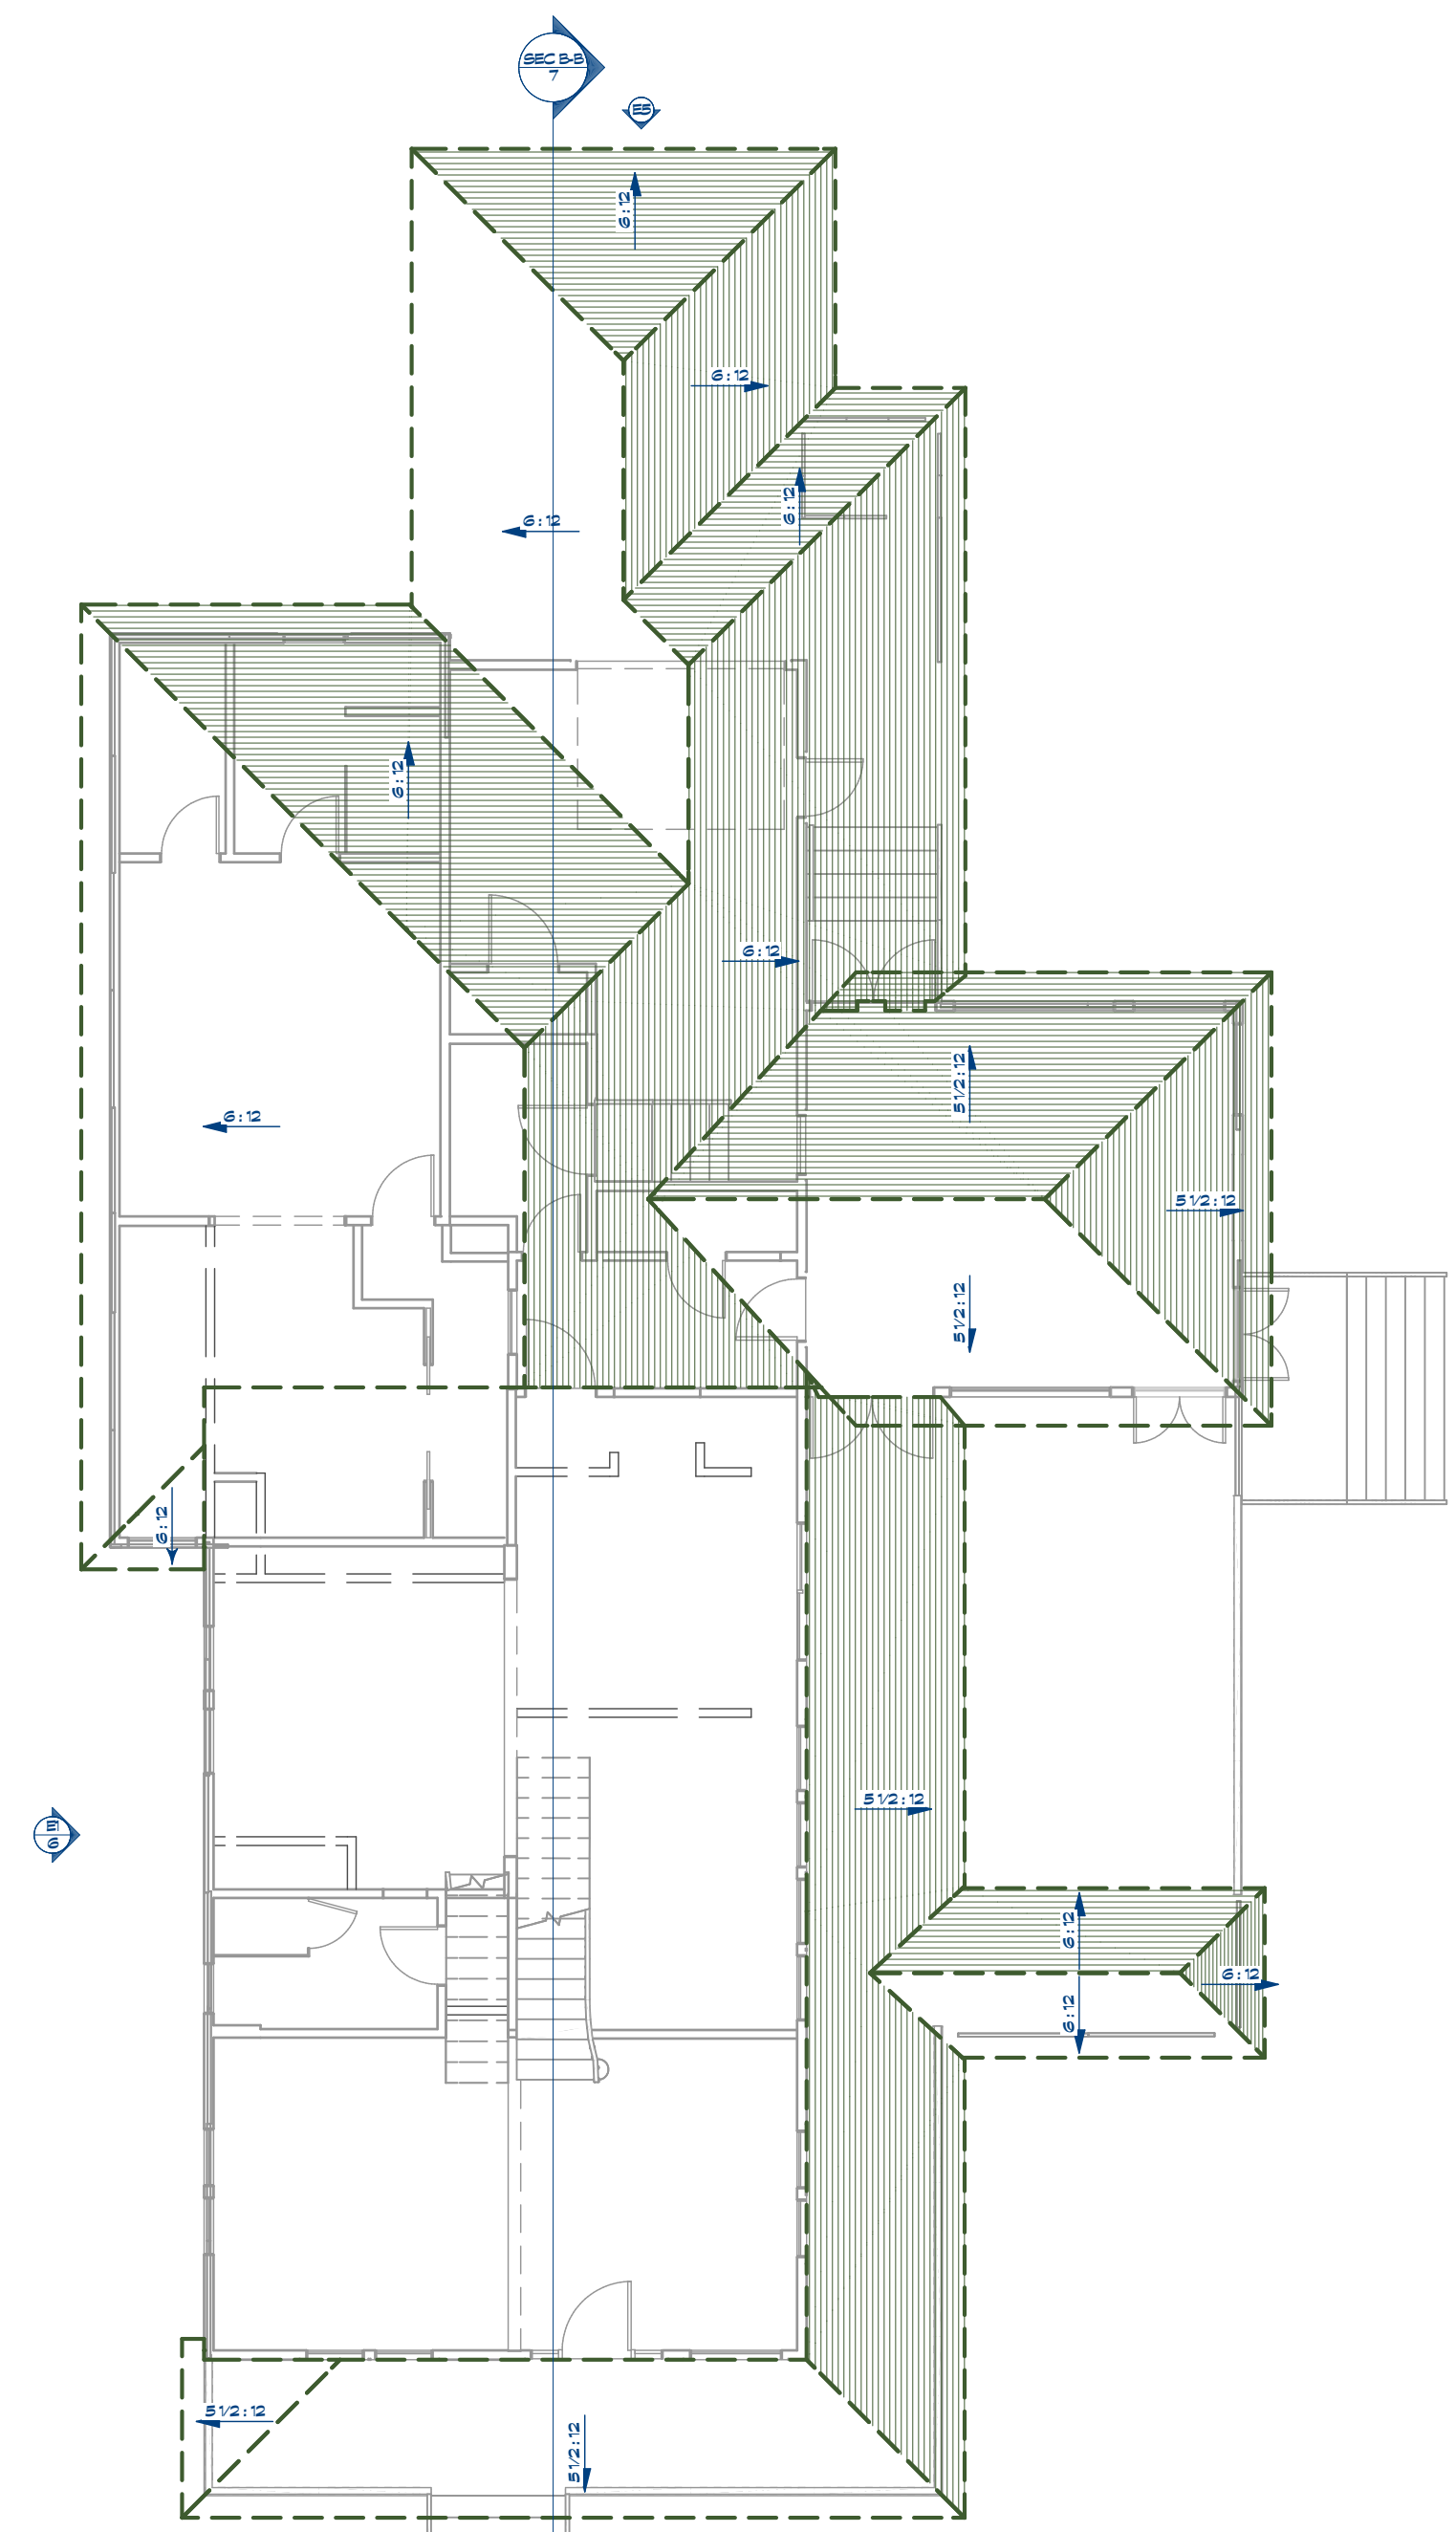

1st Floor remodeled roof plan
 scale 1/8"=1'-0"





DRAWINGS PROVIDED BY:
 ENVISION
 Design/Build
 Creating the Future... Today

800 Wilcrest Dr. suite 120
 Houston, Texas 77042
 Office 713-759-8062
 Cell 713-806-1998

DATE:
 2/8/2023

SCALE:
 1/4"=1'-0"

SHEET:
 A-8

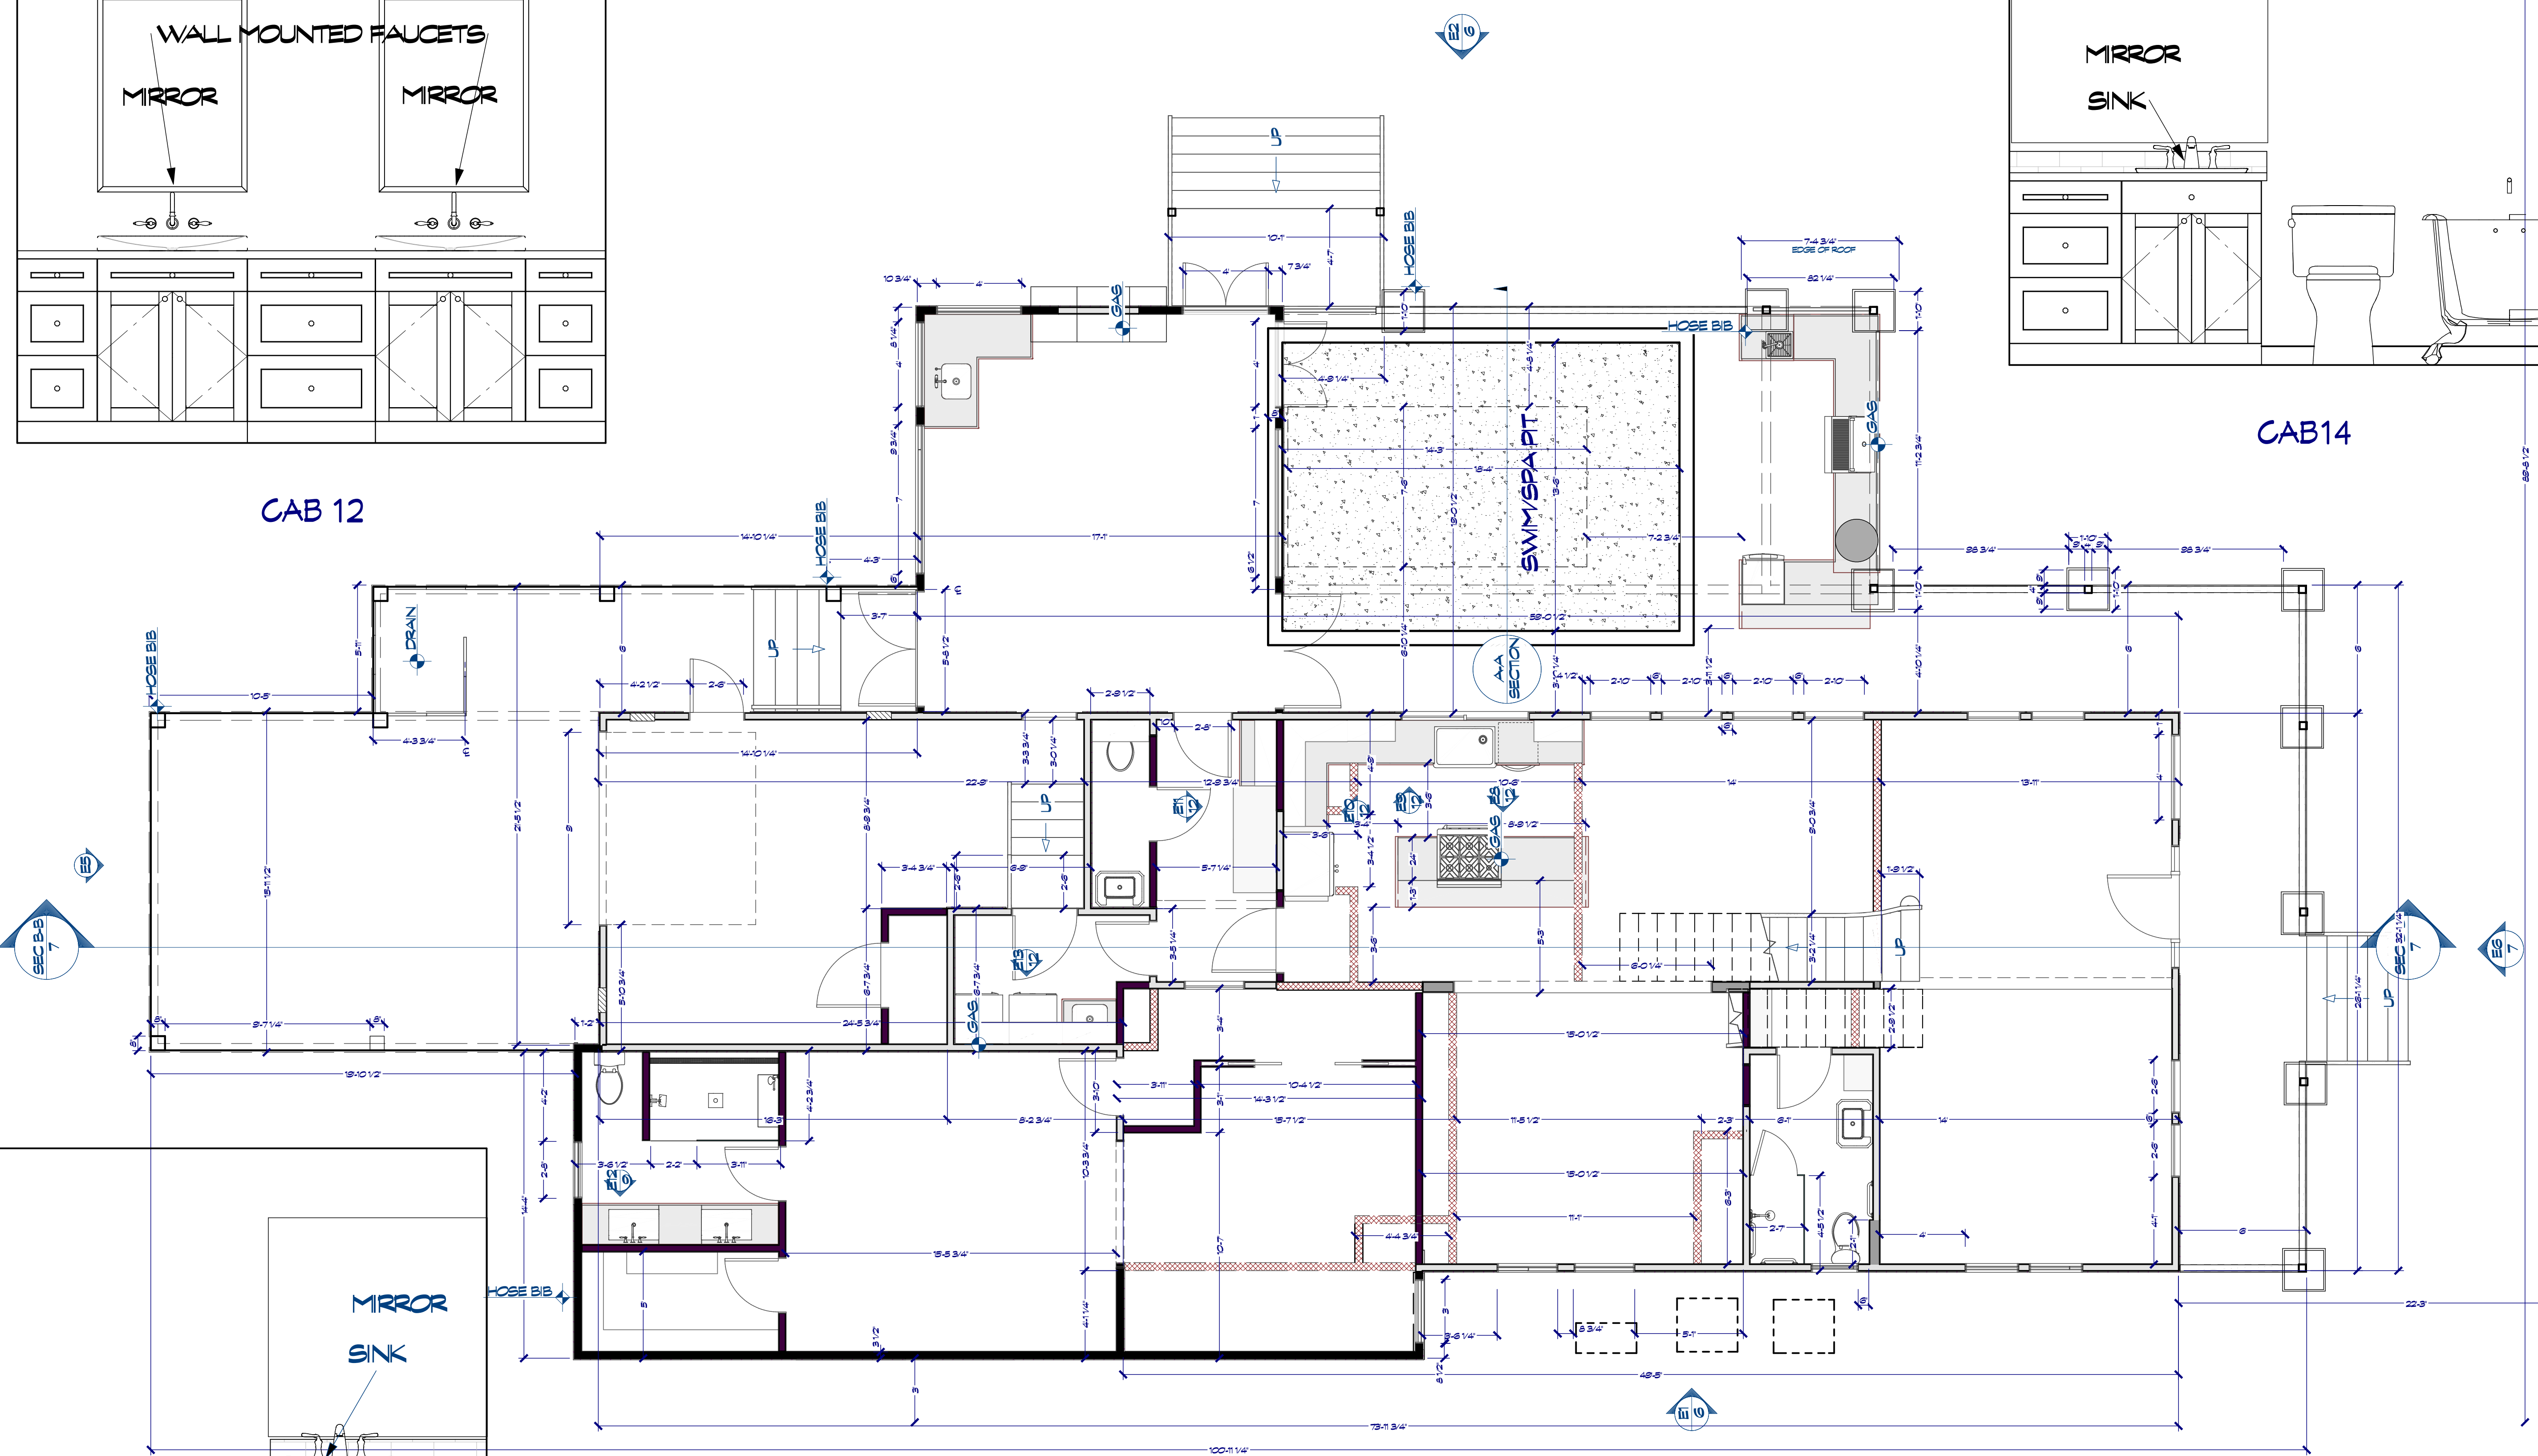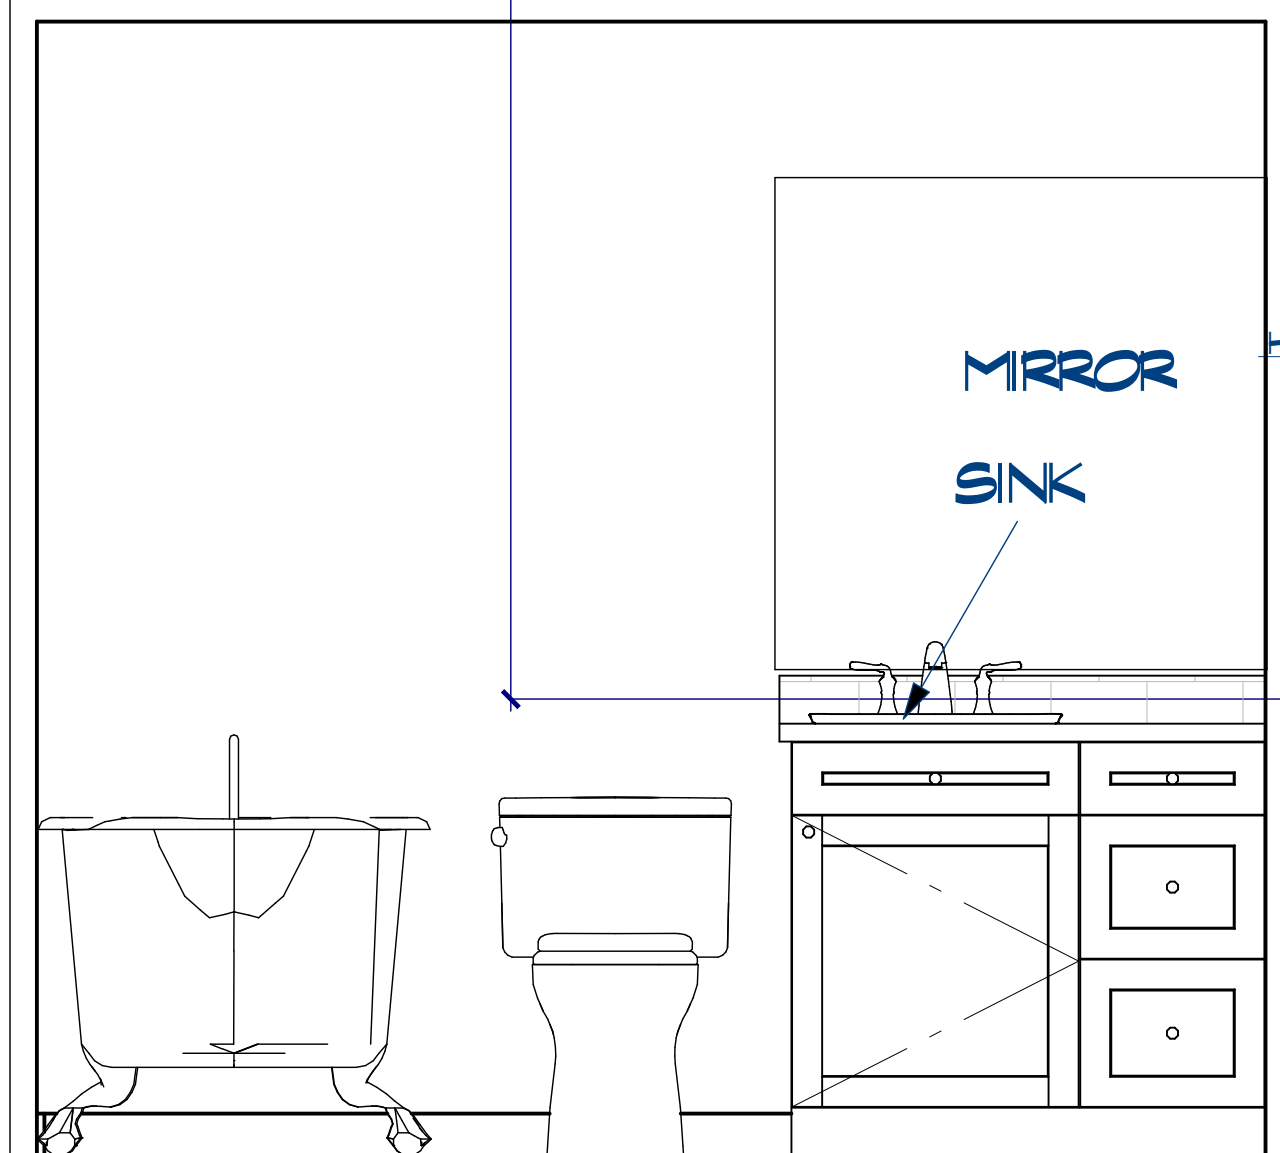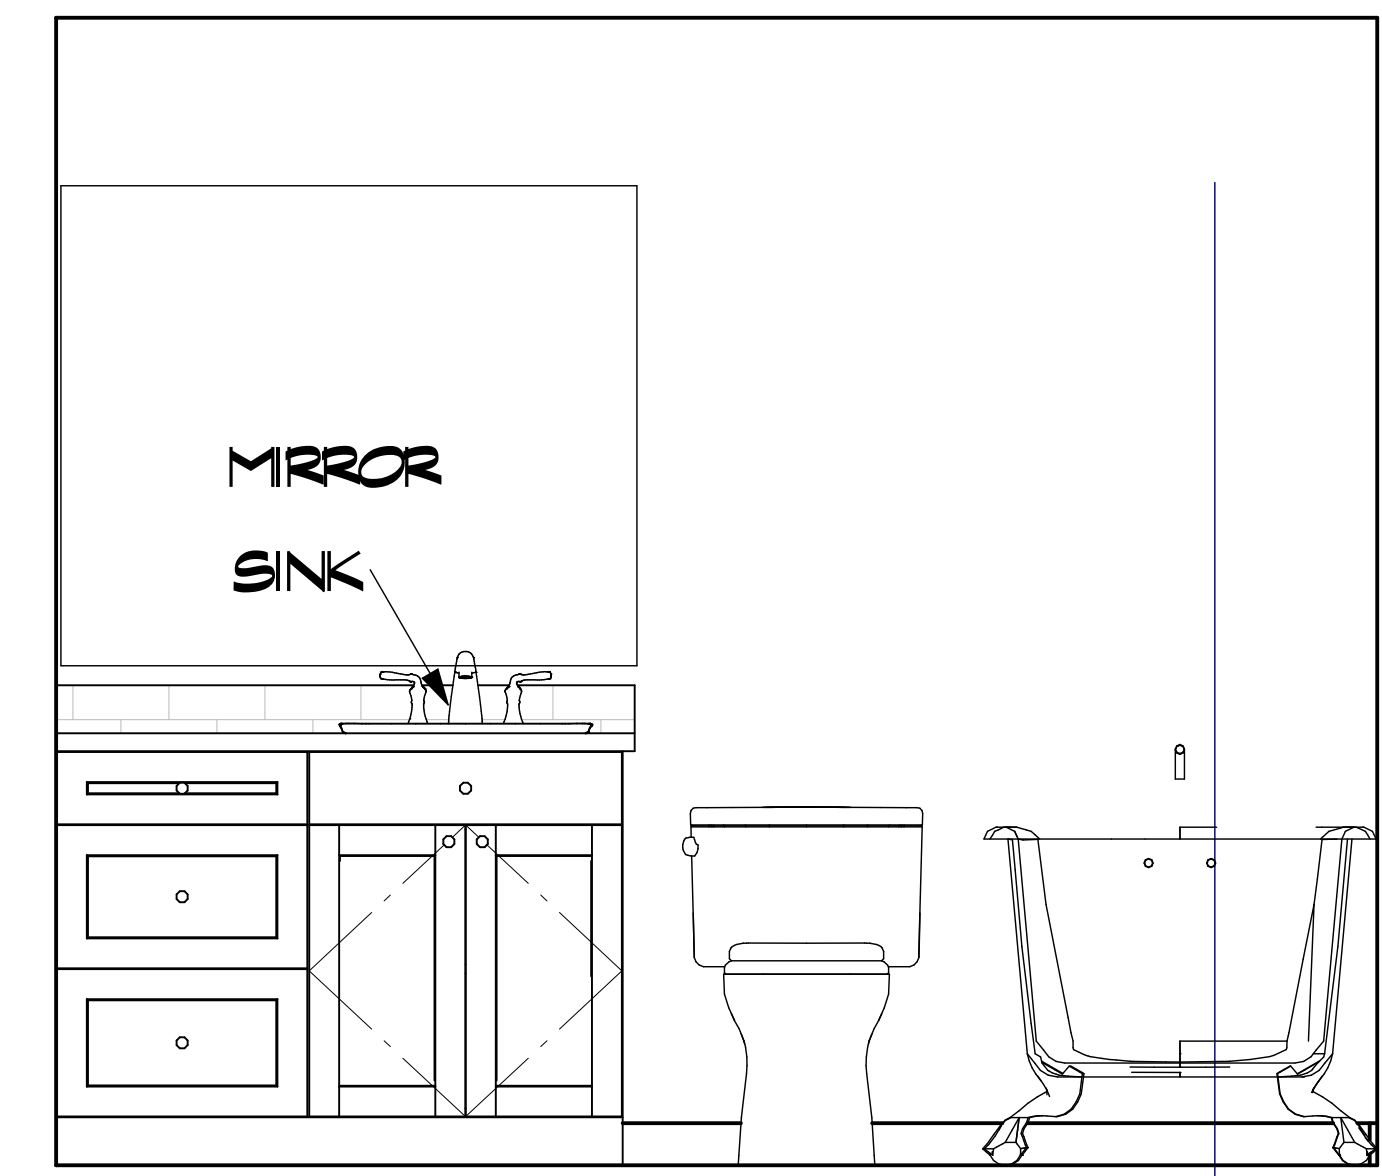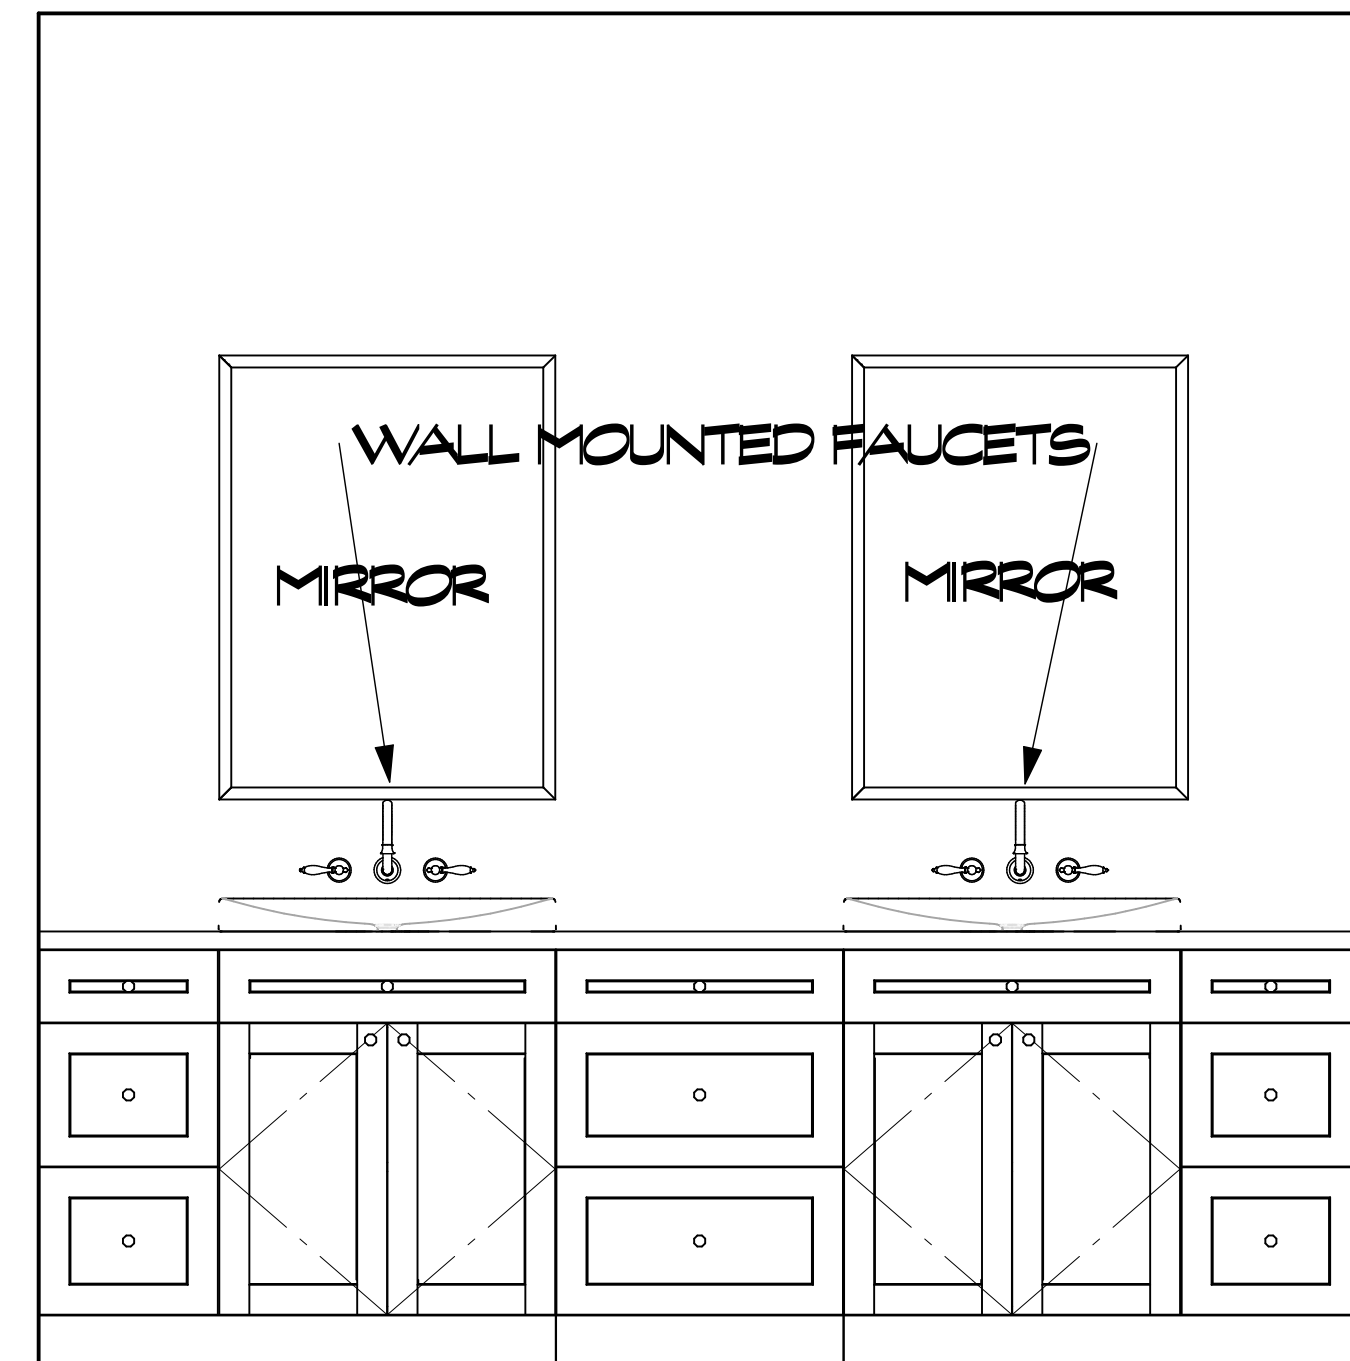


DRAWINGS PROVIDED BY:
 ENVISION
 Design/Build
 Creating the Future... Today

800 Wilcrest Dr. suite 120
 Houston, Texas 77042
 Office 713-759-8262
 Cell 713-806-1998

DATE:
 2/8/2023


SCALE:
 1/4"=1'-0"

SHEET:
 A-9

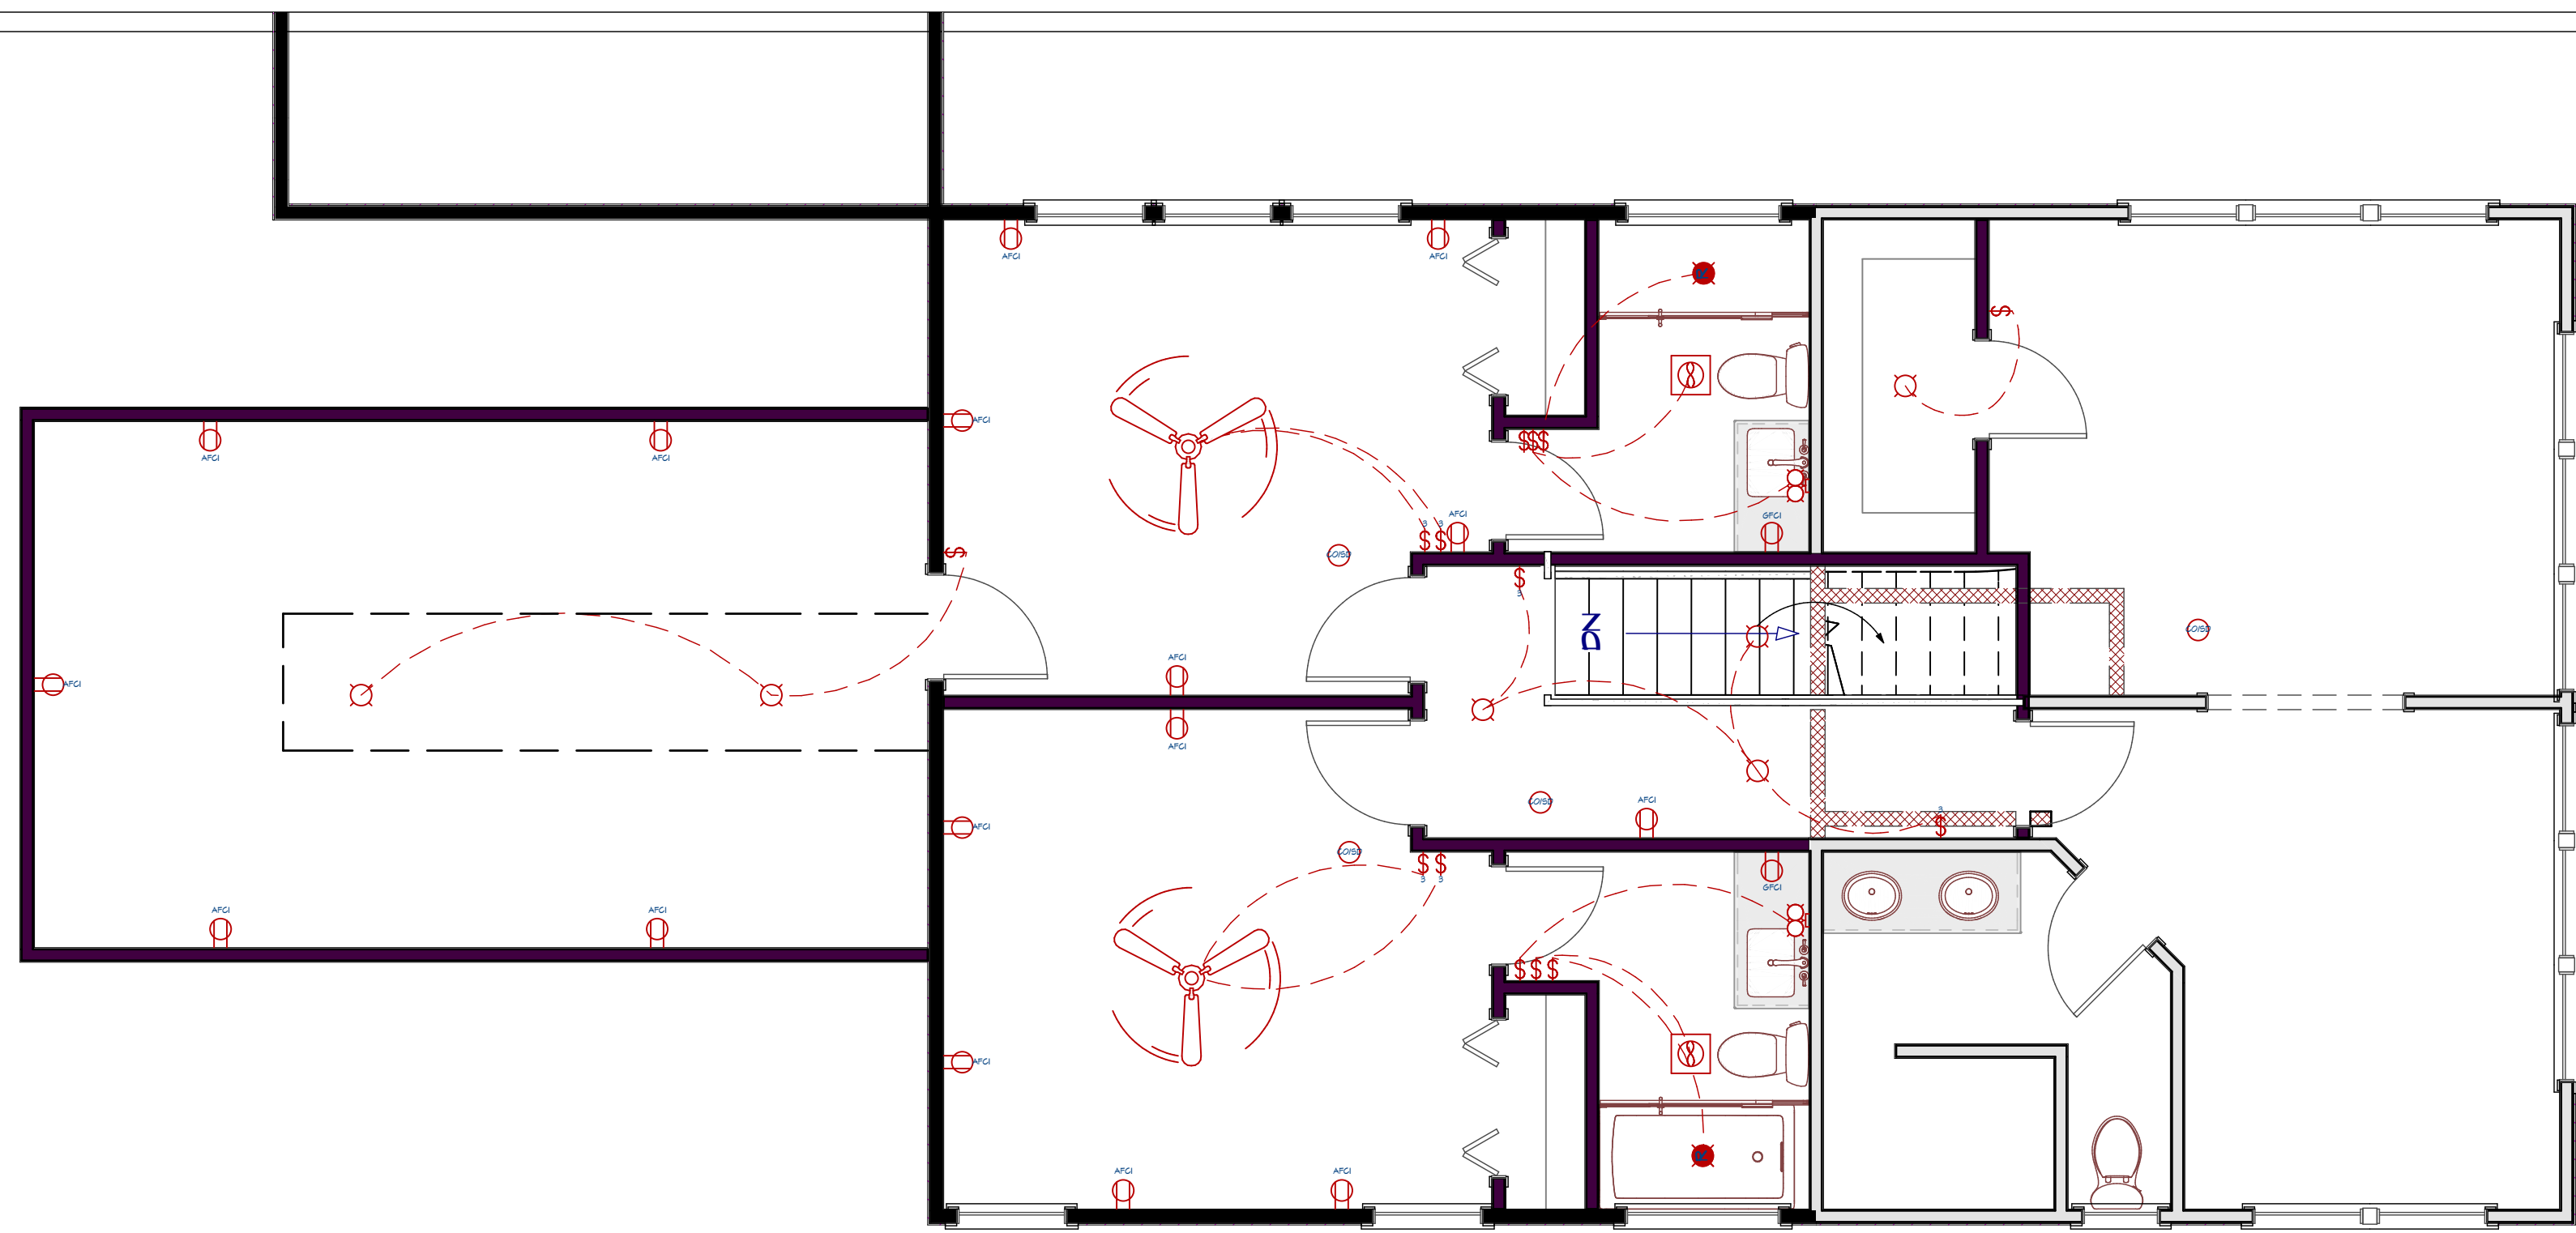


Second Floor Electrical Plan View
 scale 1/4"=1'-0"

21.

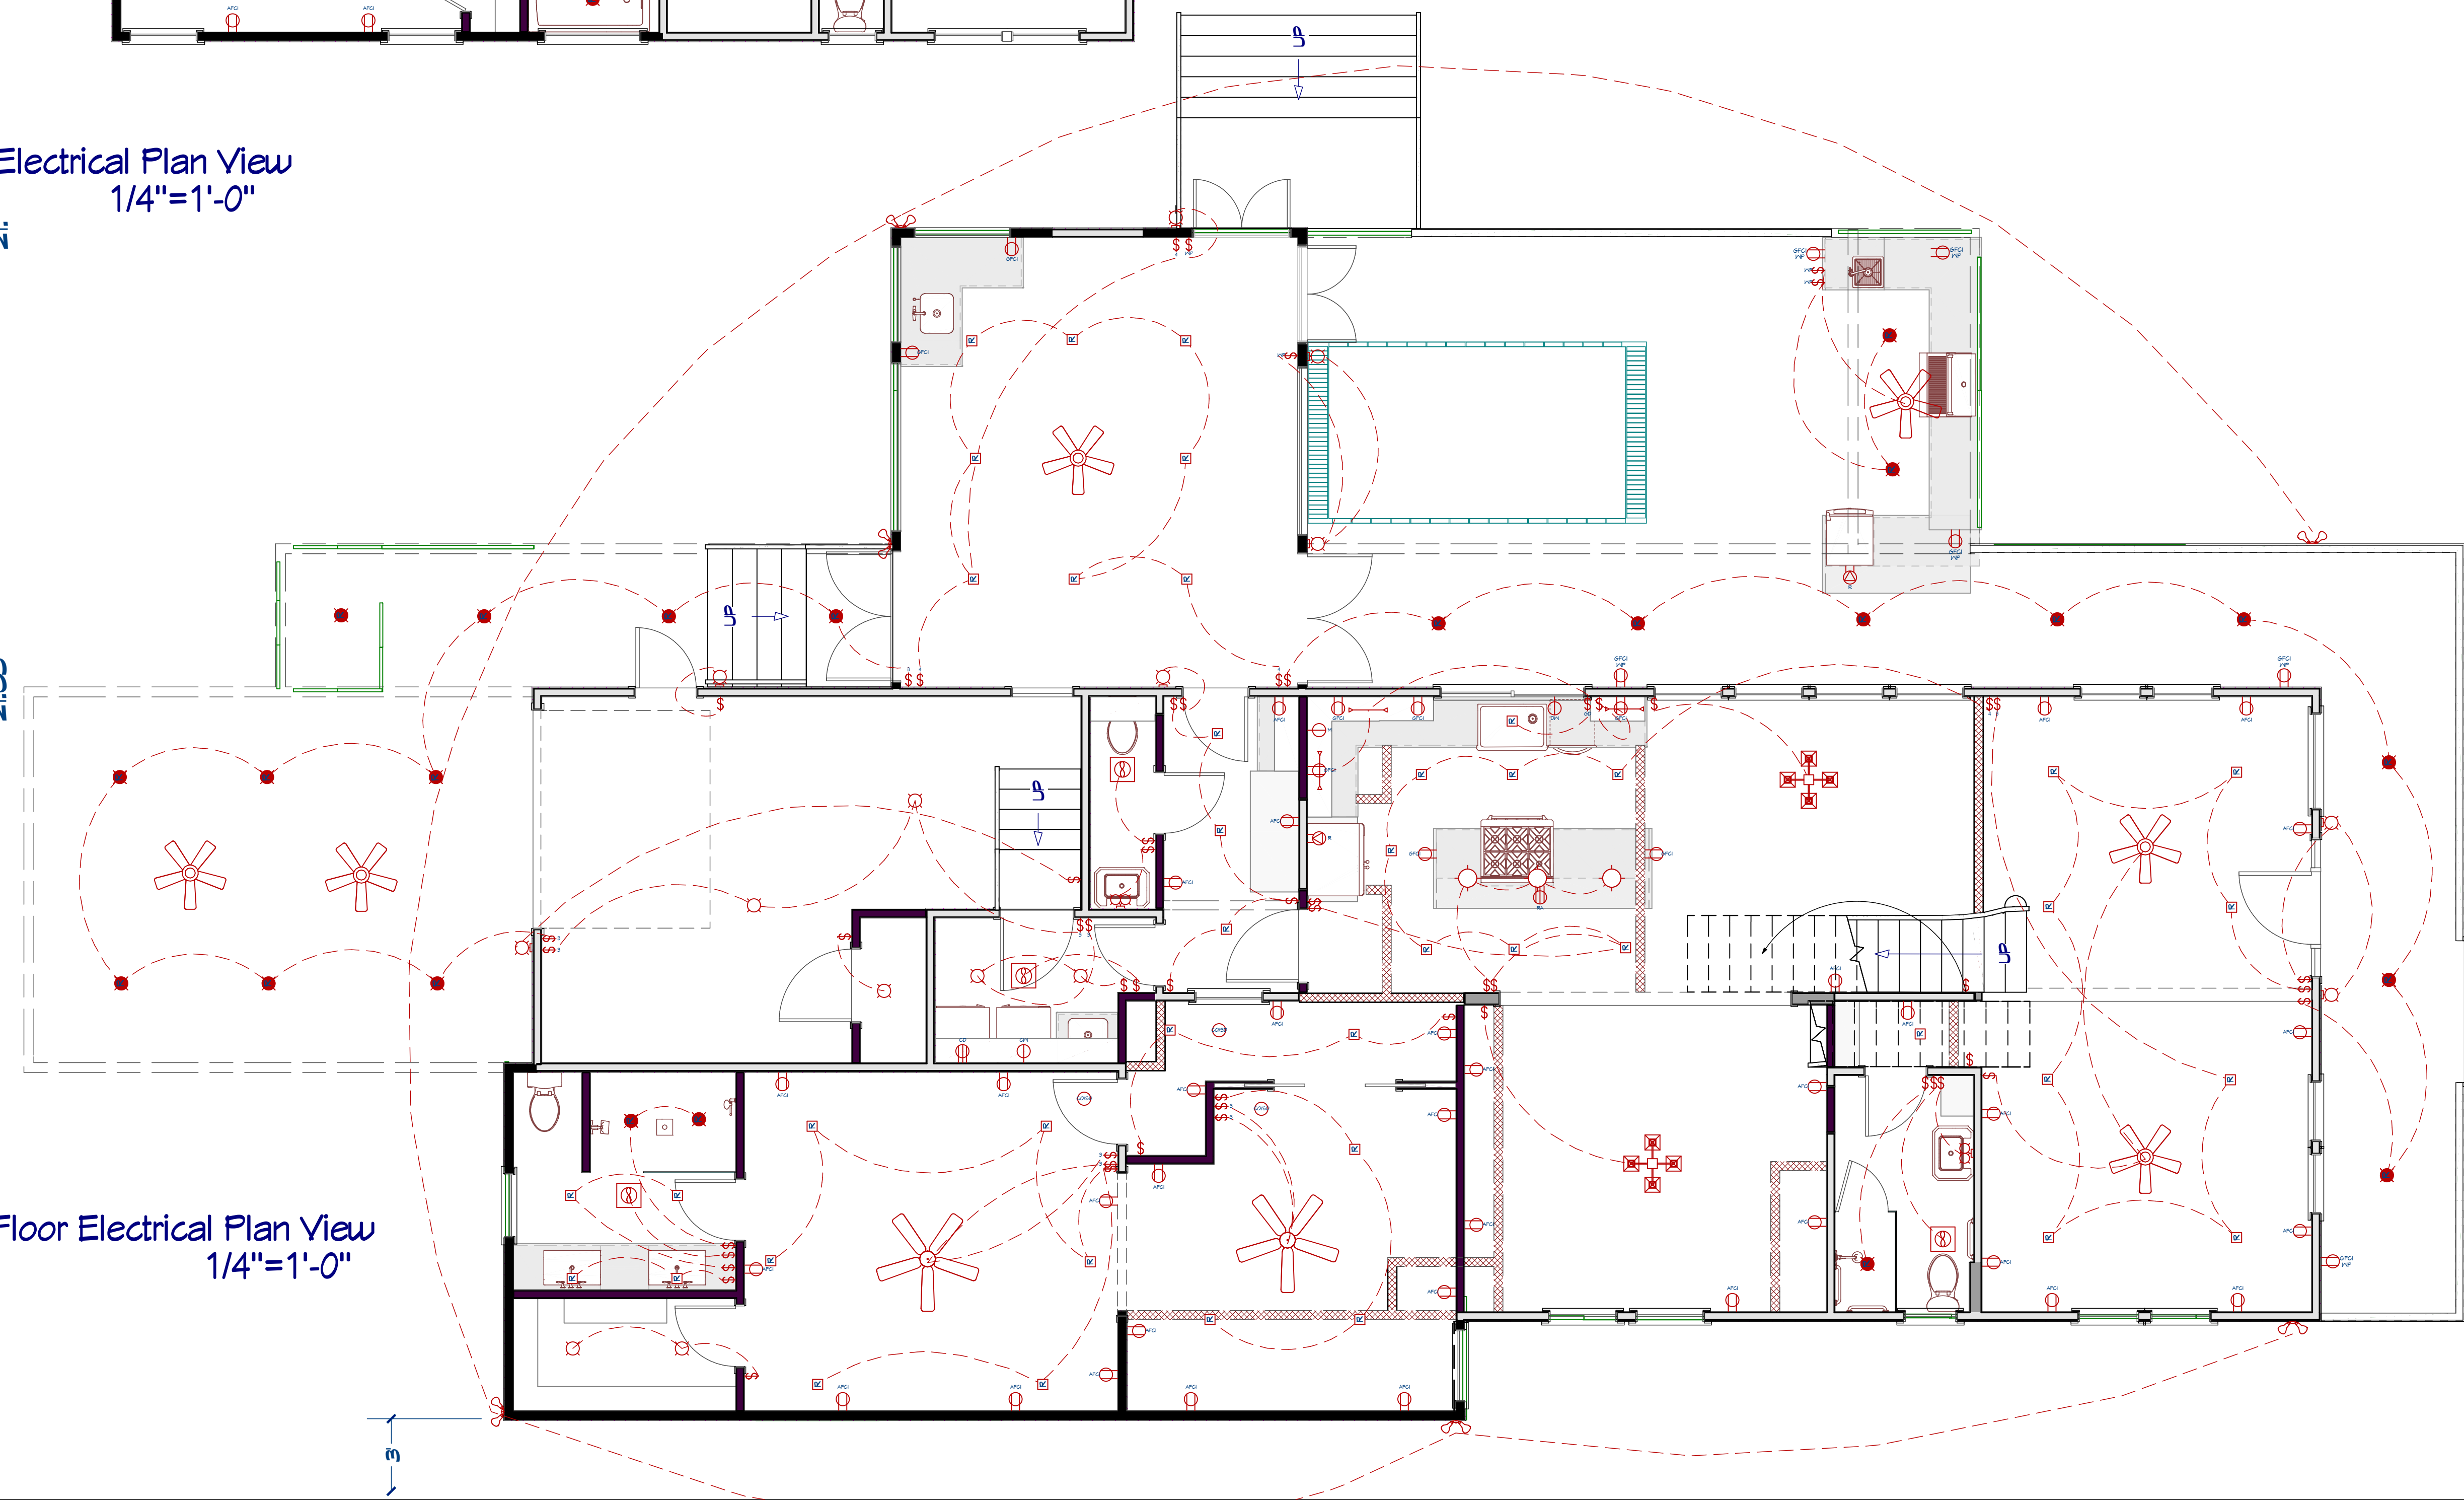

First Floor Electrical Plan View
 scale 1/4"=1'-0"

800 Wilcrest Dr. suite 120
 Houston, Texas 77042
 Office 713-759-8062
 Cell 713-806-1998

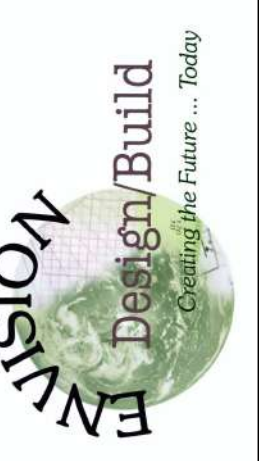

DRAWINGS PROVIDED BY:

DATE:


2/8/2023

SCALE:

1/4"=1'-0"


SHEET:

A-10

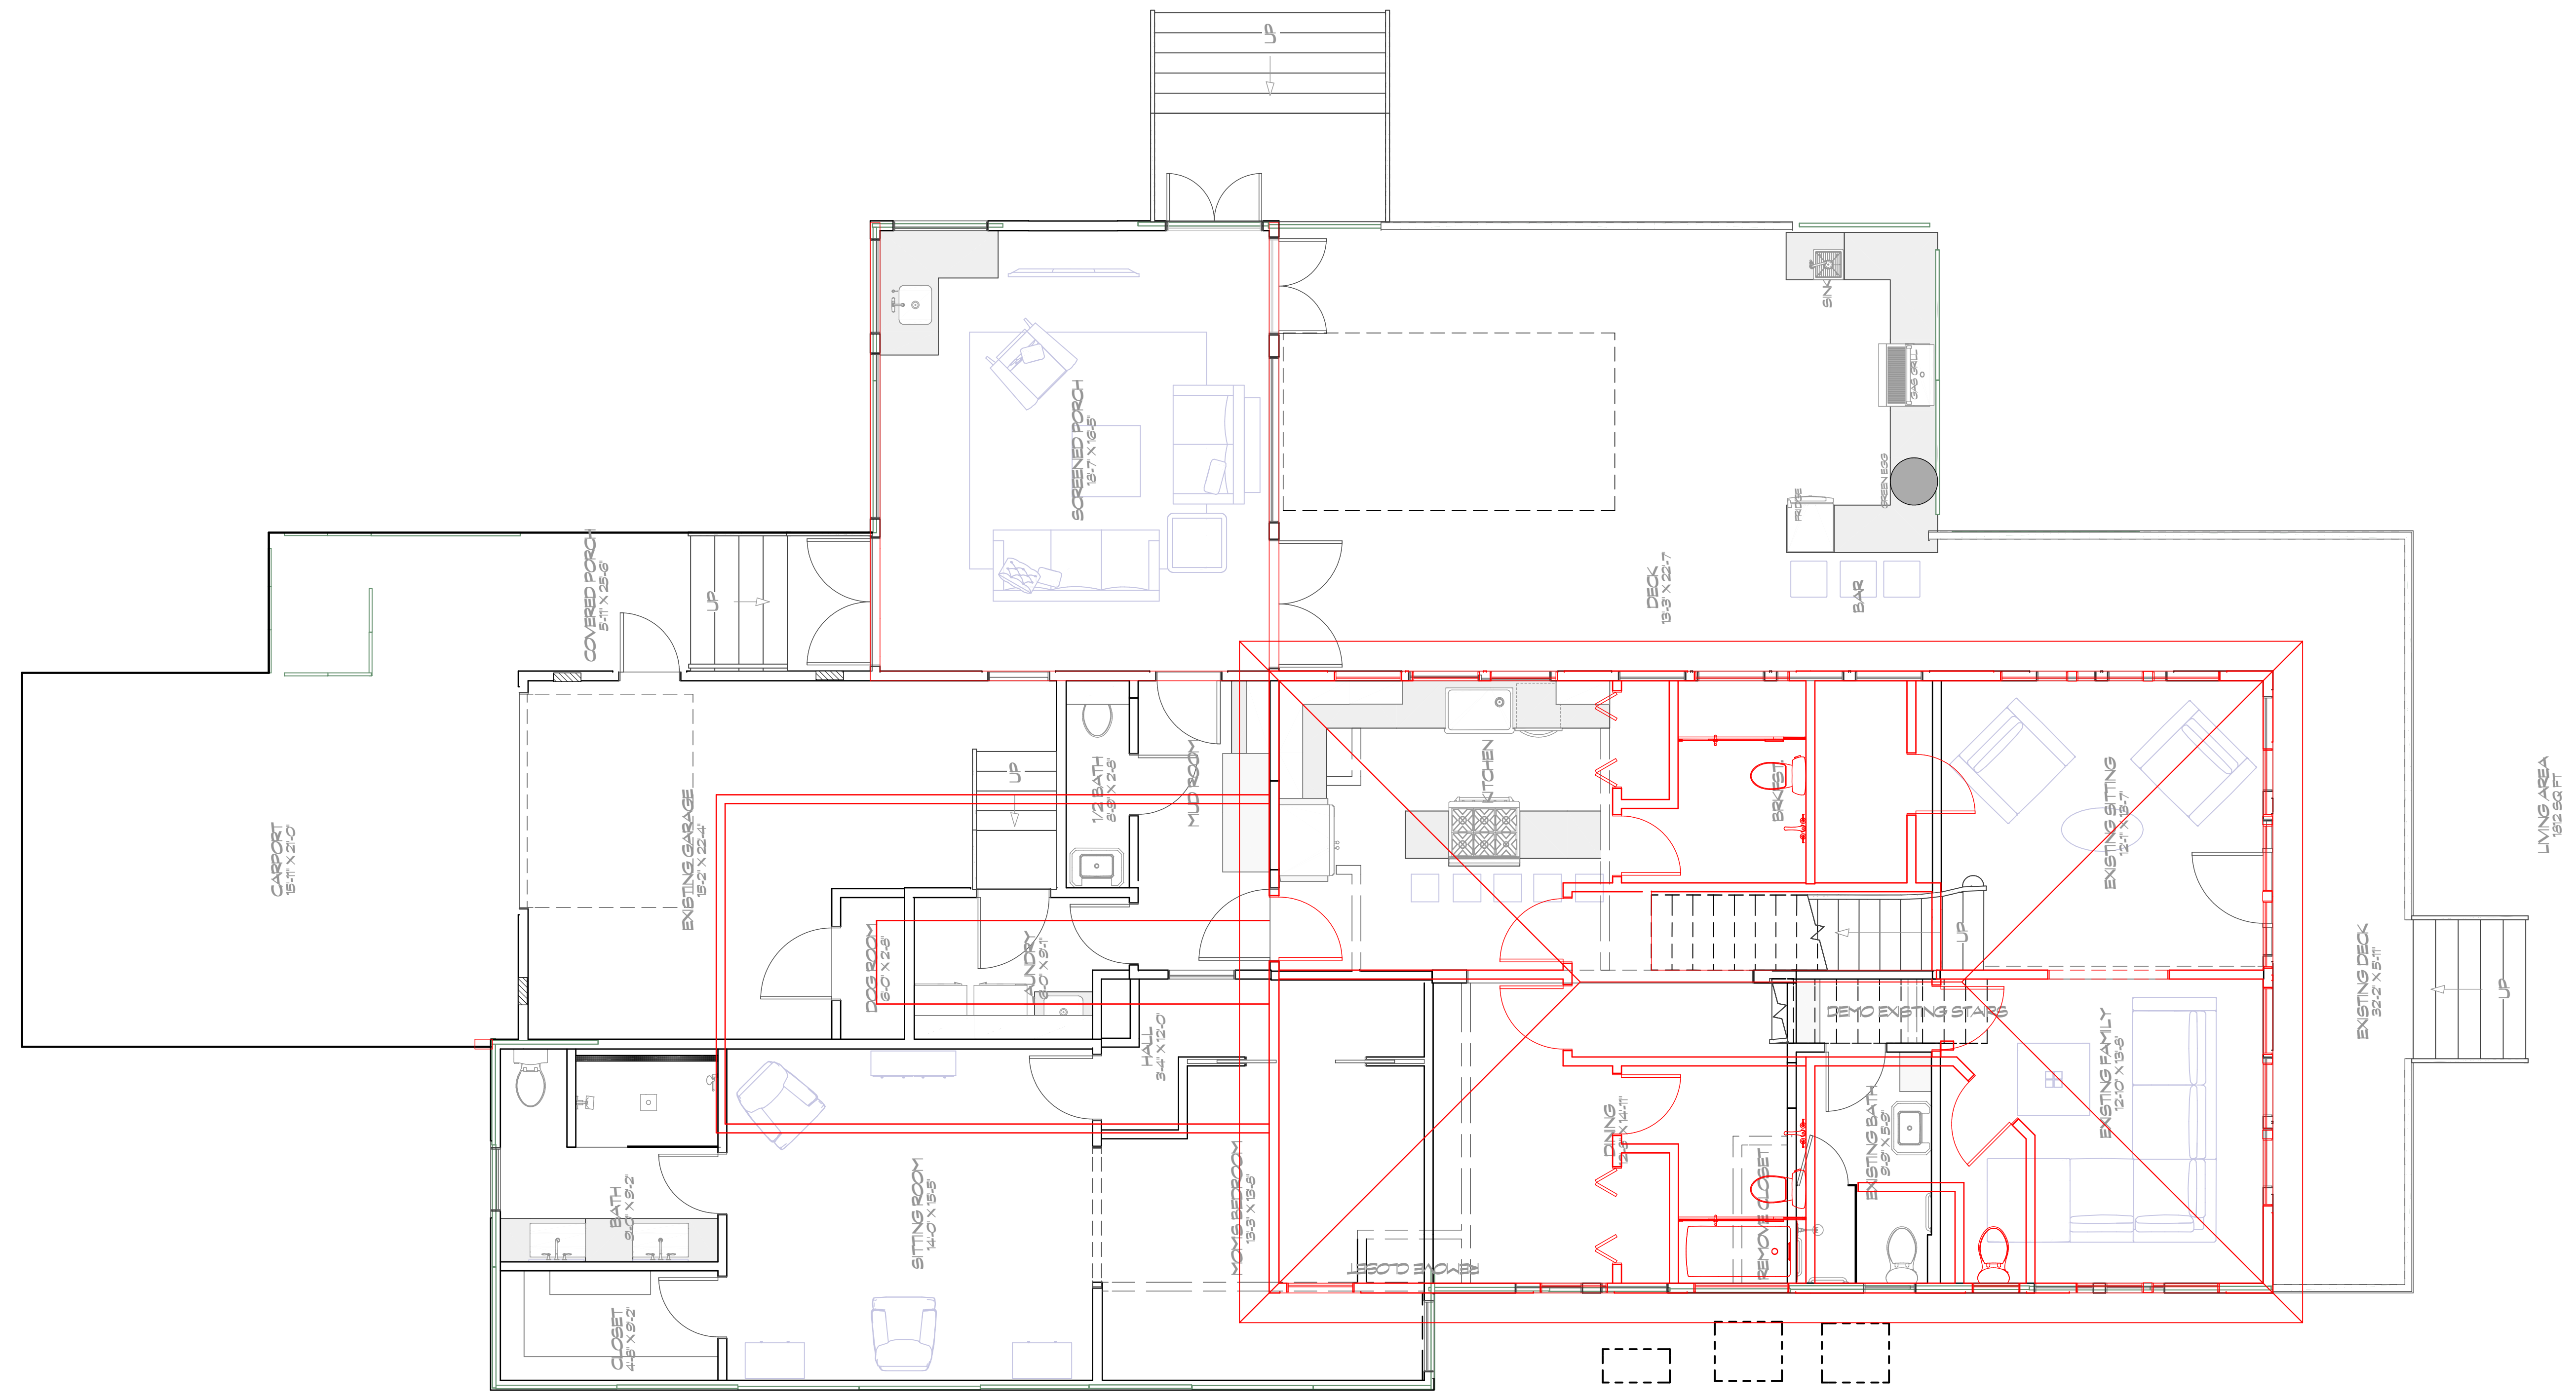

1st Floor with second floor overlaid in red
 scale 1/4"=1'-0"

800 Wilcrest Dr. suite 120
 Houston, Texas 77042
 Office 713-759-8062
 Cell 713-806-1998

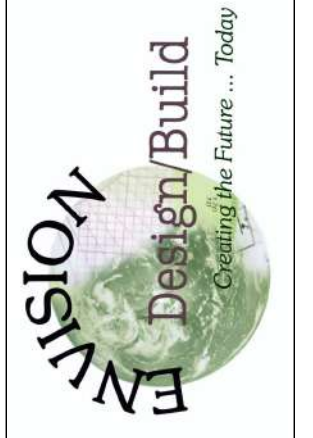

DRAWINGS PROVIDED BY:

DATE:


2/8/2023

SCALE:


1/4"=1'-0"

SHEET:


A-11

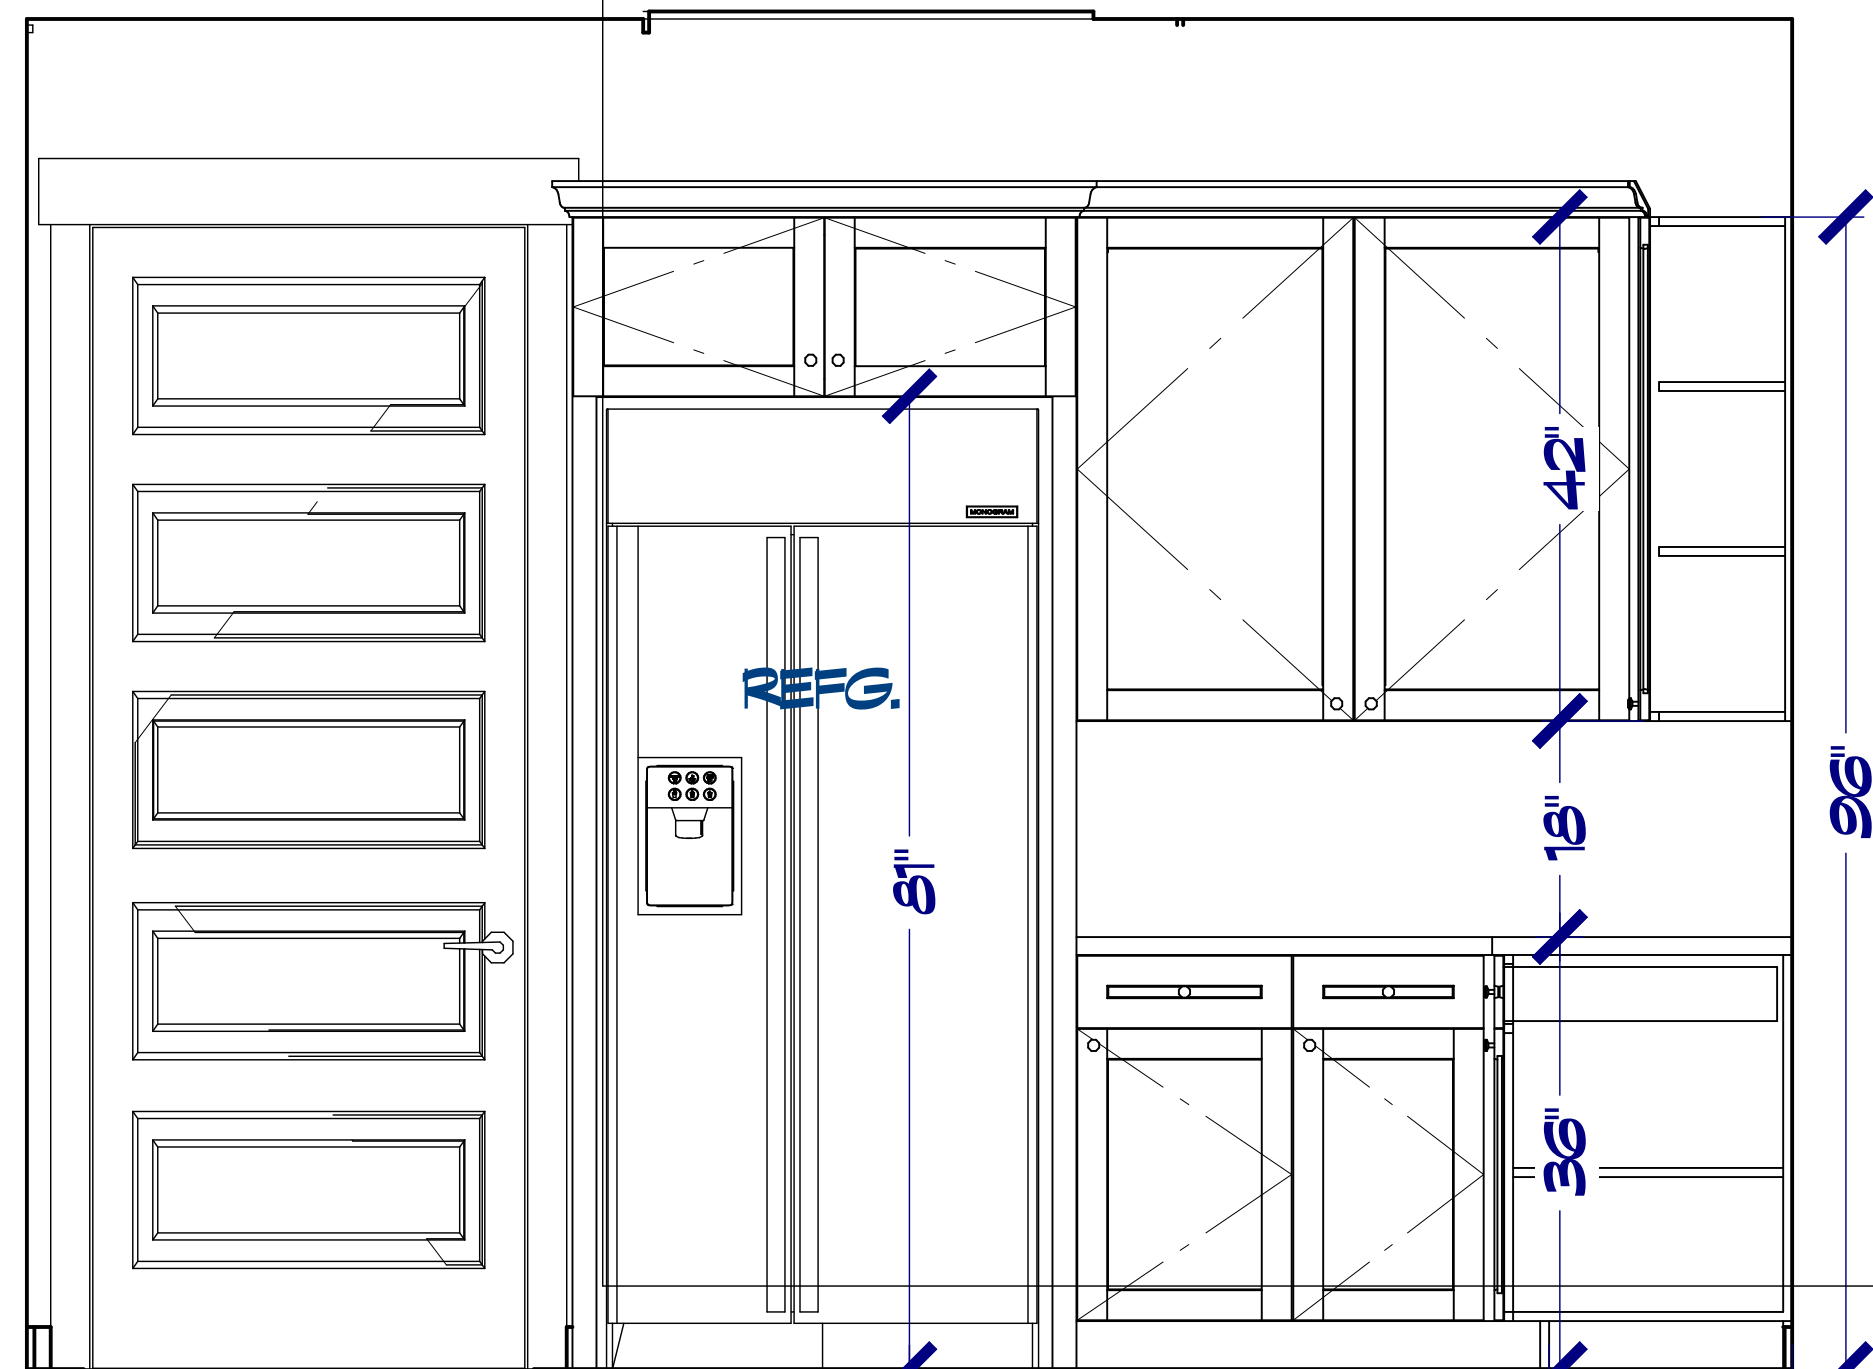


CAB 10

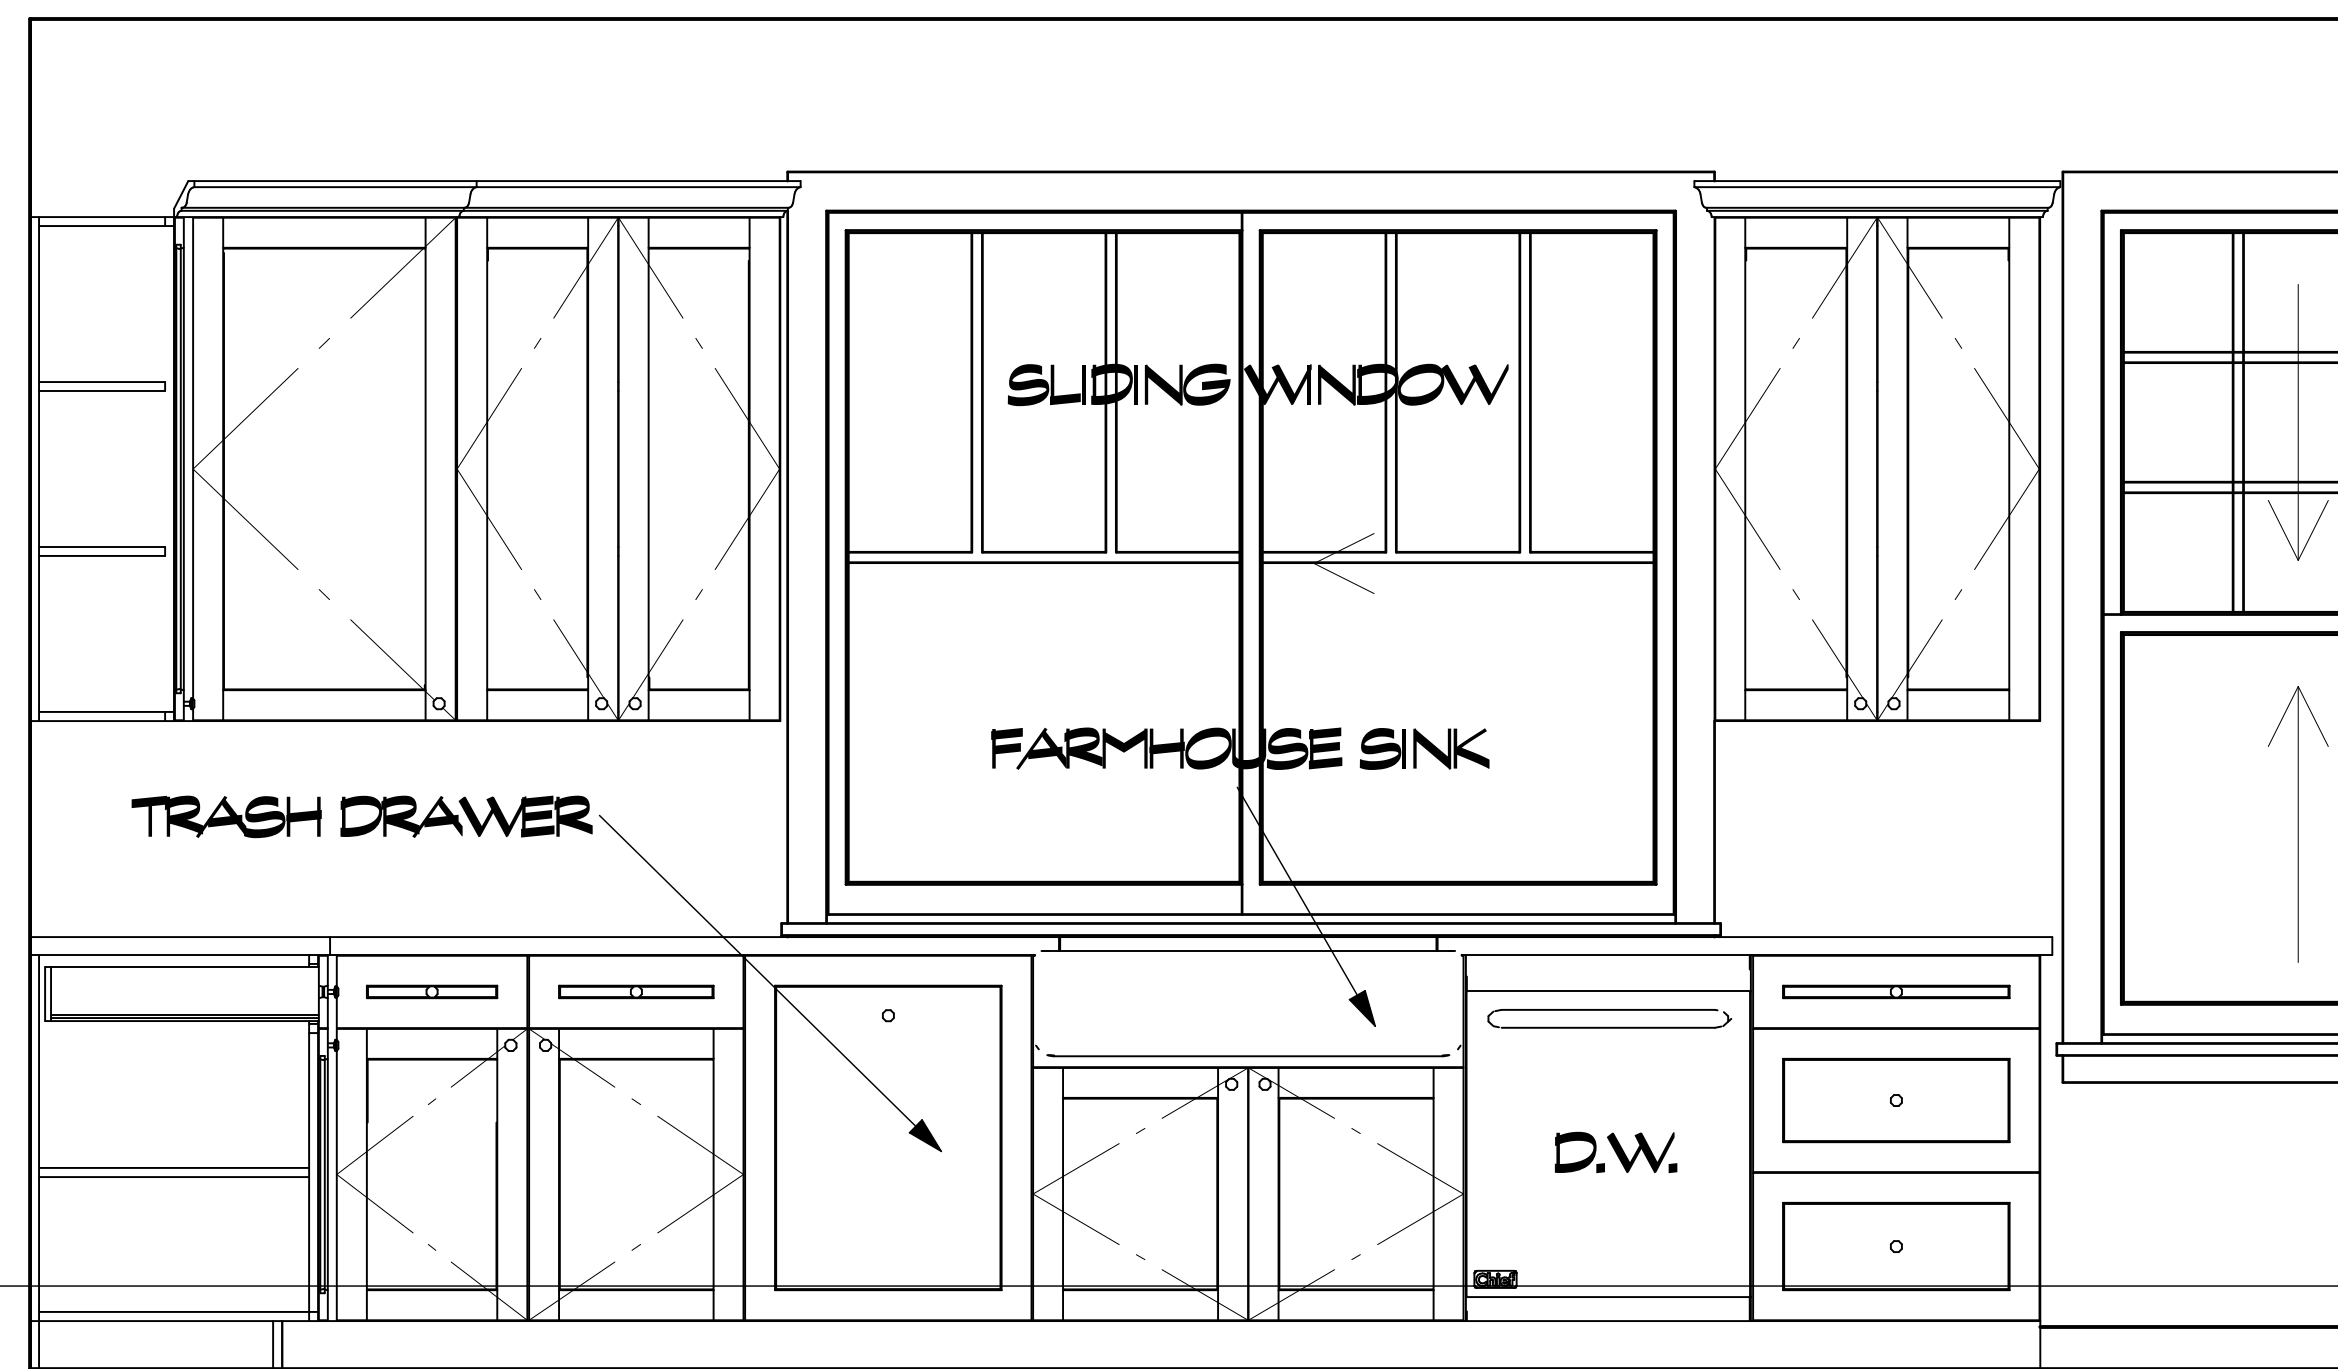

CAB 9

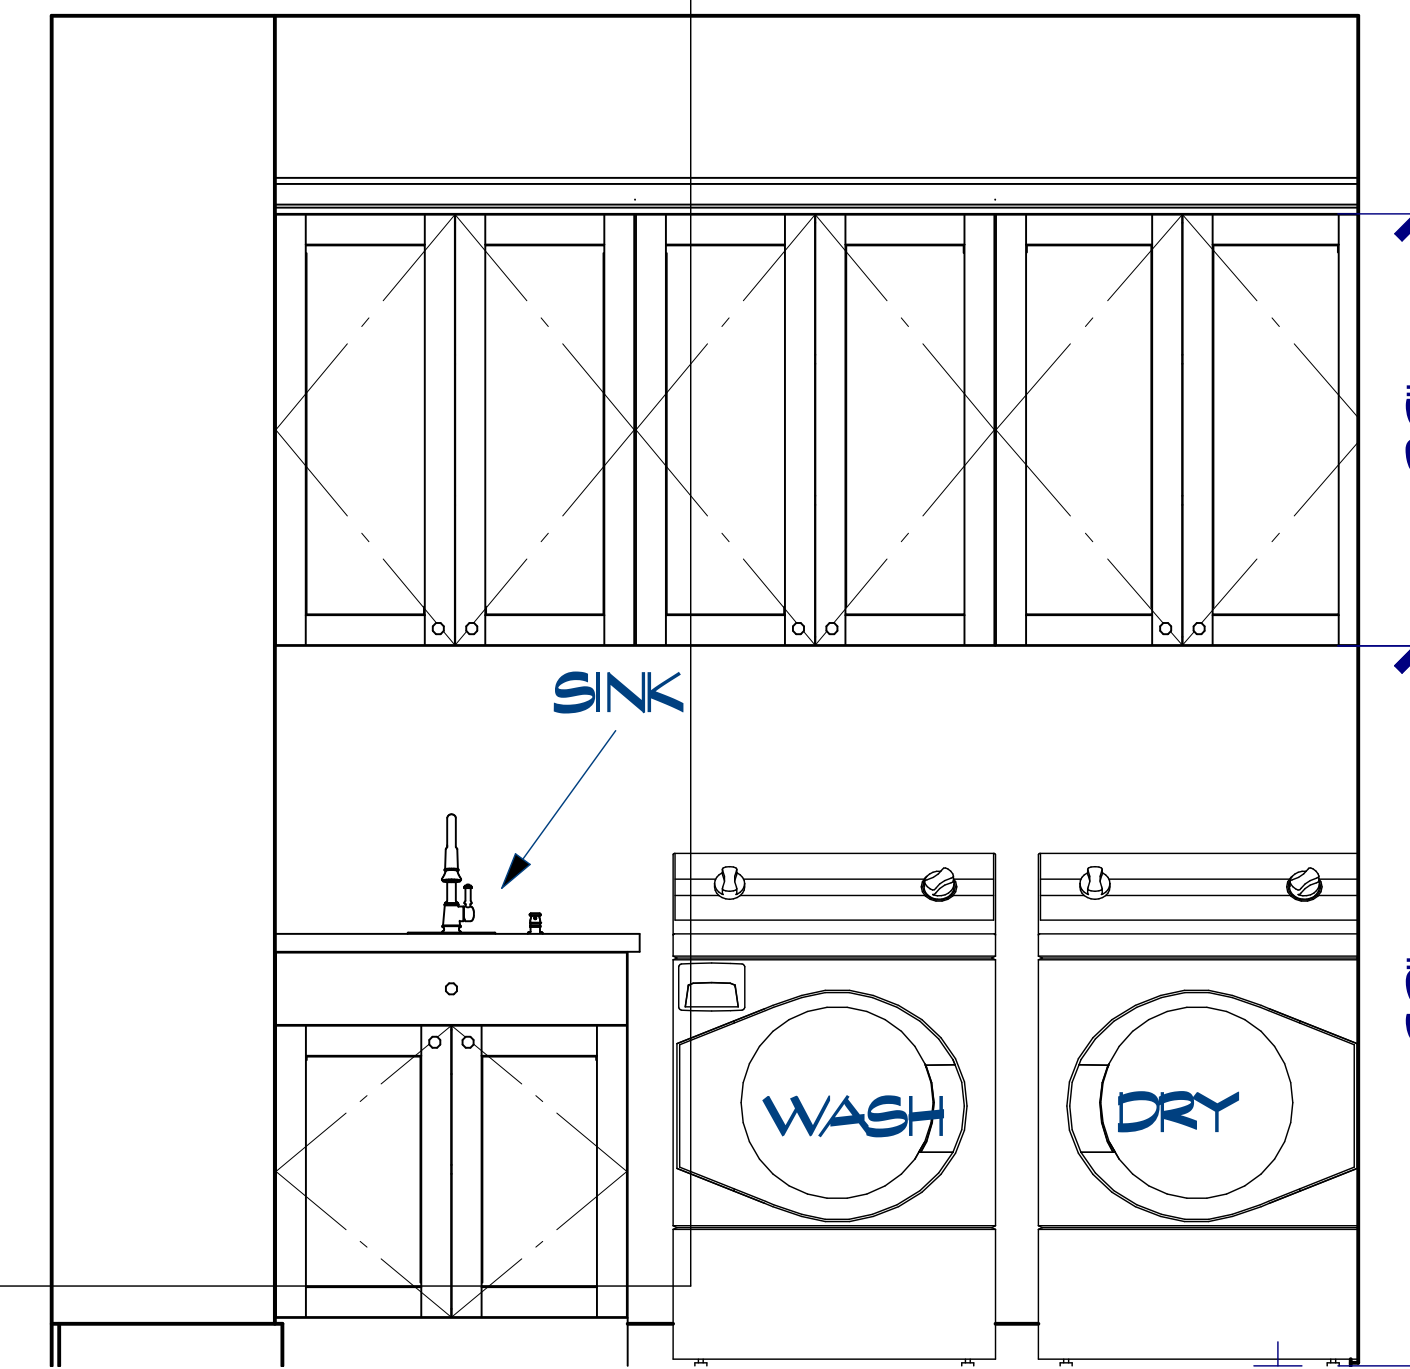


CAB 13

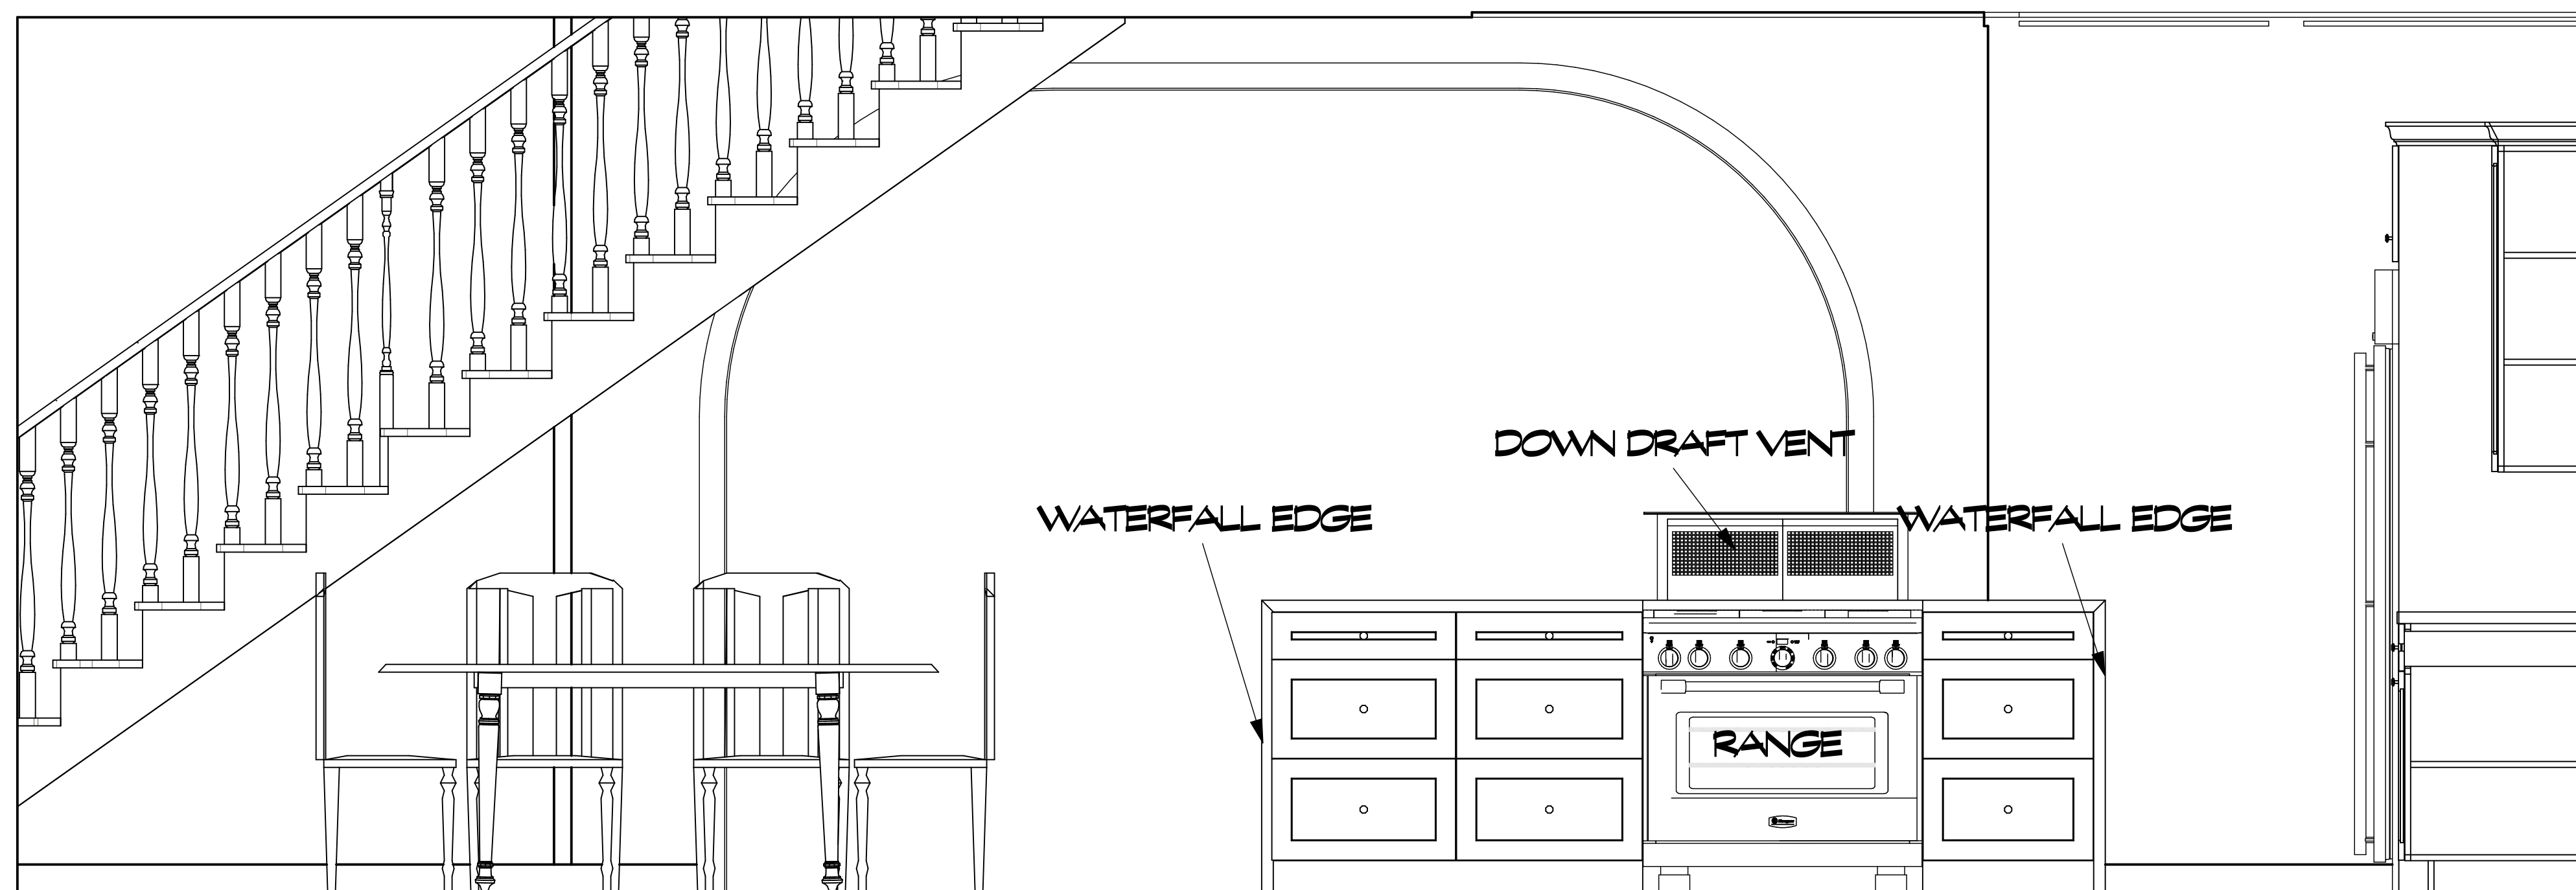

cab 8

CABINETS 3/4"=1'-0"

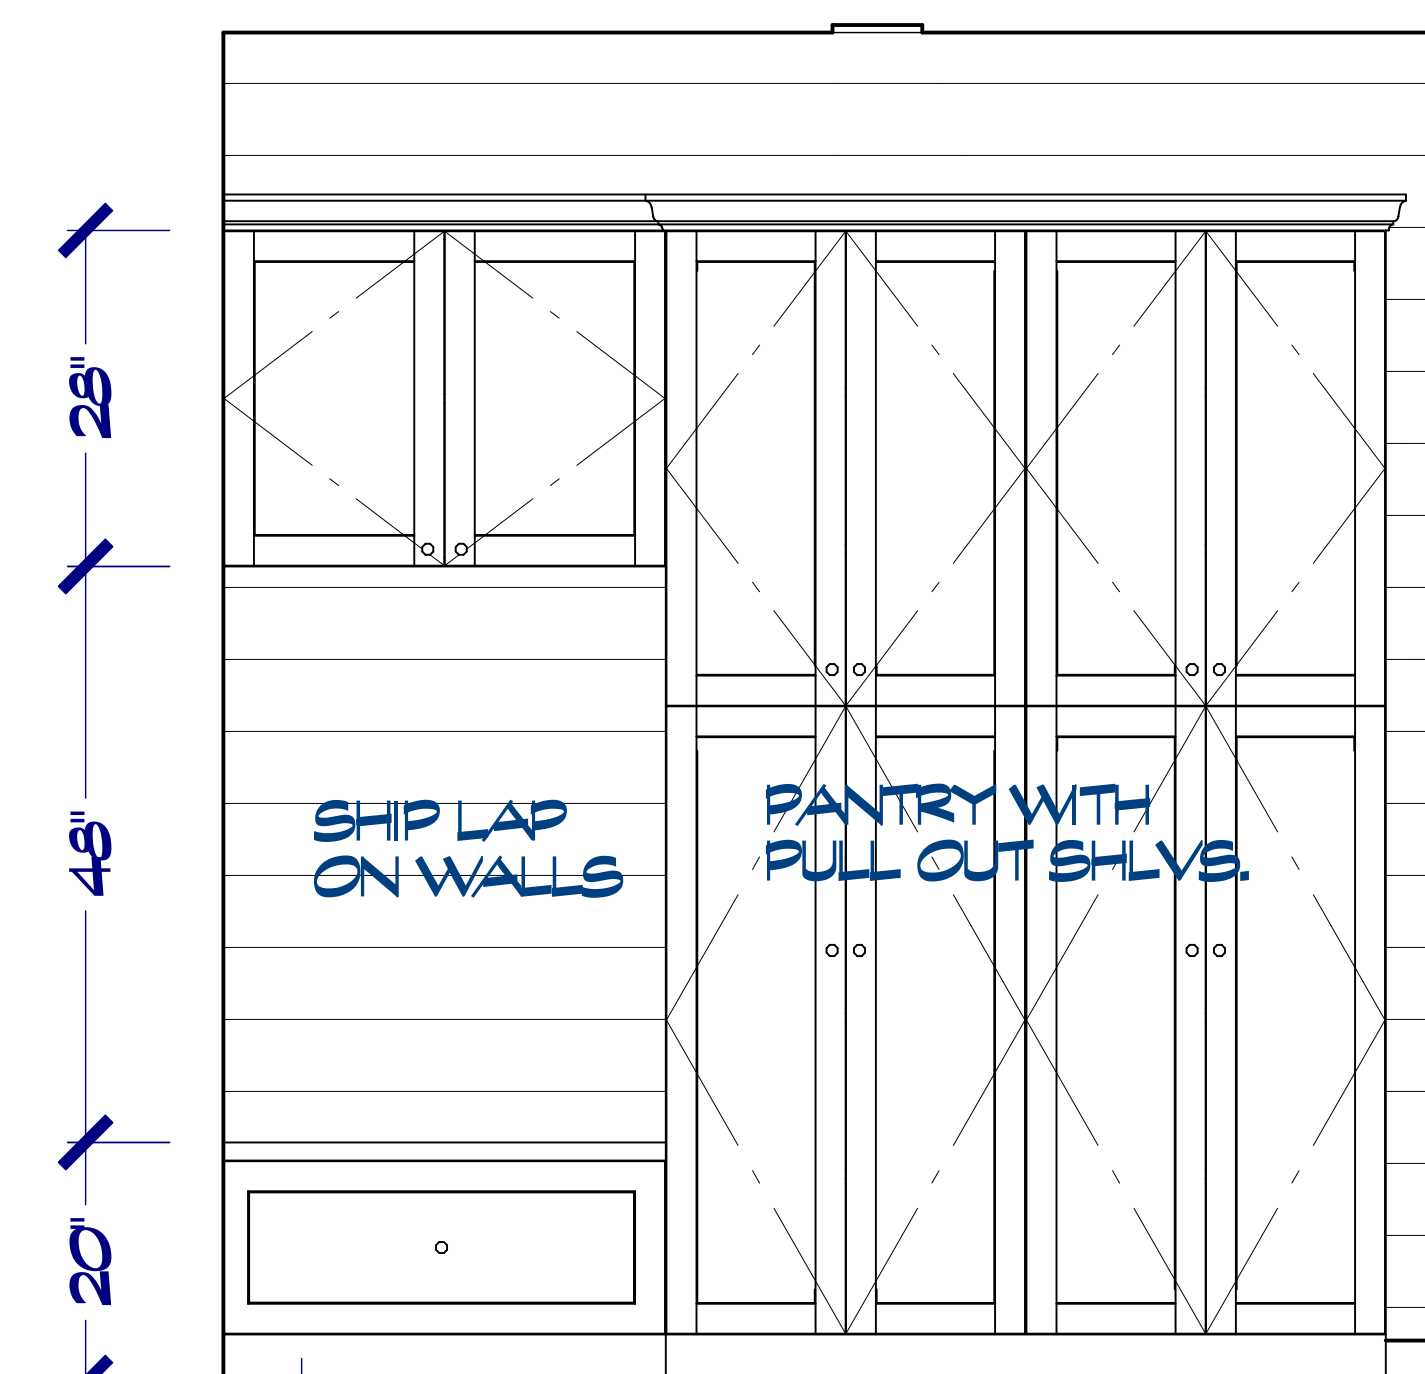

CAB 11

NO.	SYMBOL	QUANTITY	UNIT	DESCRIPTION	REMARKS
201		2	2	2868 L.N. 32'11/2" X 78'1/2"	H.N.B.D.DOOR P1 2'X8'11/2" (2)
202		1	2	2868 L.N. 32'7" X 78'1/2"	H.N.B.D.DOOR P1 2'X8'7" (2)
203		2	2	2868 R.N. 32'7" X 78'1/2"	H.N.B.D.DOOR P1 2'X8'7" (2)
204		1	2	2860 R.N. 34'7" X 78'1/2"	H.N.B.D.DOOR P1 2'X8'7" (2)
207		2	2	2868 L.N. 34'7" X 78'1/2"	H.N.B.D.DOOR P1 2'X8'7" (2)
208		1	2	2868 R.N. 34'7" X 78'1/2"	H.N.B.D.DOOR P1 2'X8'7" (2)
21		2	2	4088 L.R. 50'7" X 81'1/2"	4 DR. BR/OLD-GLASS/ED 2'X8'7" (2)

2nd Floor Door Schedule

NO.	SYMBOL	QUANTITY	UNIT	DESCRIPTION	REMARKS
205		1	1	2270 L.N. 28'7" X 81'1/2"	H.N.B.D.GLASS SLAB 2'X8'7" (2)
206		1	1	2870 L.N. 32'7" X 81'1/2"	H.N.B.D.DOOR P1 2'X8'7" (2)
207		3	1	2870 R.N. 32'7" X 81'1/2"	H.N.B.D.DOOR P1 2'X8'7" (2)
208		1	1	2870 R.N. 34'7" X 81'1/2"	H.N.B.D.DOOR P1 2'X8'7" (2)
209		2	1	3070 L.N. 34'7" X 81'1/2"	H.N.B.D.DOOR P1 2'X8'7" (2)
208		1	1	4080 L.R.N. 50'11" X 88'1/2"	DOUBLE H.N.B.D.DOOR P24 2'X8'11" (2)
207		1	1	4080 L.R.N. 50'7" X 81'1/2"	DOUBLE H.N.B.D.DOOR P24 2'X8'7" (2)
209		2	1	5460 L.R.N. 68'7" X 81'1/2"	DOUBLE H.N.B.D.DOOR P24 2'X8'7" (2)
284		1	1	2870 L.N. 32'7" X 81'1/2"	ENT. H.N.B.D.DOOR P1 2'X8'7" (2)
288		1	1	2868 R.N. 31'11" X 81'1/2"	ENT. H.N.B.D.DOOR P1 2'X8'11" (2)
288		1	1	3070 R.N. 34'7" X 81'1/2"	ENT. H.N.B.D.DOOR P1 2'X8'7" (2)
287		1	1	2868 L.N. 34'7" X 81'1/2"	ENT. H.N.B.D.DOOR P1 2'X8'7" (2)
288		1	1	3070 L.R. 32'11" X 88'1/2"	DOUBLE P.O.O.T.DOOR P1 2'X8'11" (2)
288		1	1	3070 ENSTNG	SHRABE-SHRABE DOOR P22 2'X8'7" (2)
240		1	1	2868 R.N. 32'7" X 81'1/2"	H.N.B.D.DOOR P1 2'X8'7" (2)
241		1	1	5670 68'7" X 81'1/2"	M.L.L.D.L.N.T. 2'X8'7" (2)

1st Floor Door Schedule

NO.	SYMBOL	QUANTITY	UNIT	DESCRIPTION	REMARKS
W01		3	2	2060CH ENSTNG	DOUBLE HUNG 2'X8'7" (2)
W02		3	2	2060CH NEW	DOUBLE HUNG 2'X8'7" (2)
W03		1	2	2040CH ENSTNG	DOUBLE HUNG 2'X8'7" (2)
W07		2	2	2040CH ENSTNG	DOUBLE HUNG 2'X8'7" (2)
W08		3	2	2040CH ENSTNG	DOUBLE HUNG 2'X8'7" (2)
W02		1	2	4080N NEW	F.N.B.D.GLASS 2'X8'7" (2)
W02		1	2	4080N NEW	F.N.B.D.GLASS 2'X8'7" (2)

2nd Floor Window Schedule

5.7 SQ.FT. MIN. OPEN. AT ALL BEDROOMS

NO.	SYMBOL	QUANTITY	UNIT	DESCRIPTION	REMARKS
W05		2	1	2080 ENST.	DOUBLE HUNG 2'X8'7" (2)
W07		2	1	2080 ENST.	DOUBLE HUNG 2'X8'7" (2)
W08		1	1	2080CH NEW	DOUBLE HUNG 2'X8'7" (2)
W09		1	1	2080CH ENST.	DOUBLE HUNG 2'X8'7" (2)
W0		1	1	2080CH NEW	DOUBLE HUNG 2'X8'7" (2)
W1		1	1	2240CH RELOCATE FOR SHOWER	DOUBLE HUNG 2'X8'3" (2)
W2		6	1	2880CH ENST.	DOUBLE HUNG 2'X8'4" (2)
W3		1	1	2880CH NEW	DOUBLE HUNG 2'X8'7" (2)
W7		4	1	4028N ENST.	F.N.B.D.GLASS 2'X8'7" (2)
W8		2	1	4080N ENST.	F.N.B.D.GLASS 2'X8'7" (2)
W9		1	1	4080CH ENST.	DOUBLE HUNG 2'X8'7" (2)
W20		1	1	6080L ENSTNG	LEFT BLIND 2'X8'7" (2)
W21		2	1	7028N ENST.	F.N.B.D.GLASS 2'X8'7" (2)
W22		2	1	7070N ENST.	F.N.B.D.GLASS 2'X8'7" (2)
W3		1	1	2080CH ENST.	DOUBLE HUNG 2'X8'7" (2)

1st Floor Window Schedule

5.7 SQ.FT. MIN. OPEN. AT ALL BEDROOMS

800 Wilcrest Dr. Suite 120
 Houston, Texas 77042
 Office 713-759-8262
 Cell 713-806-1998

ENVISION
 Design/Build
 Creating the Future... Today

DRAWINGS PROVIDED BY:

DATE:


2/8/2023

SCALE:


1/4"=1'-0"

SHEET:

A-13

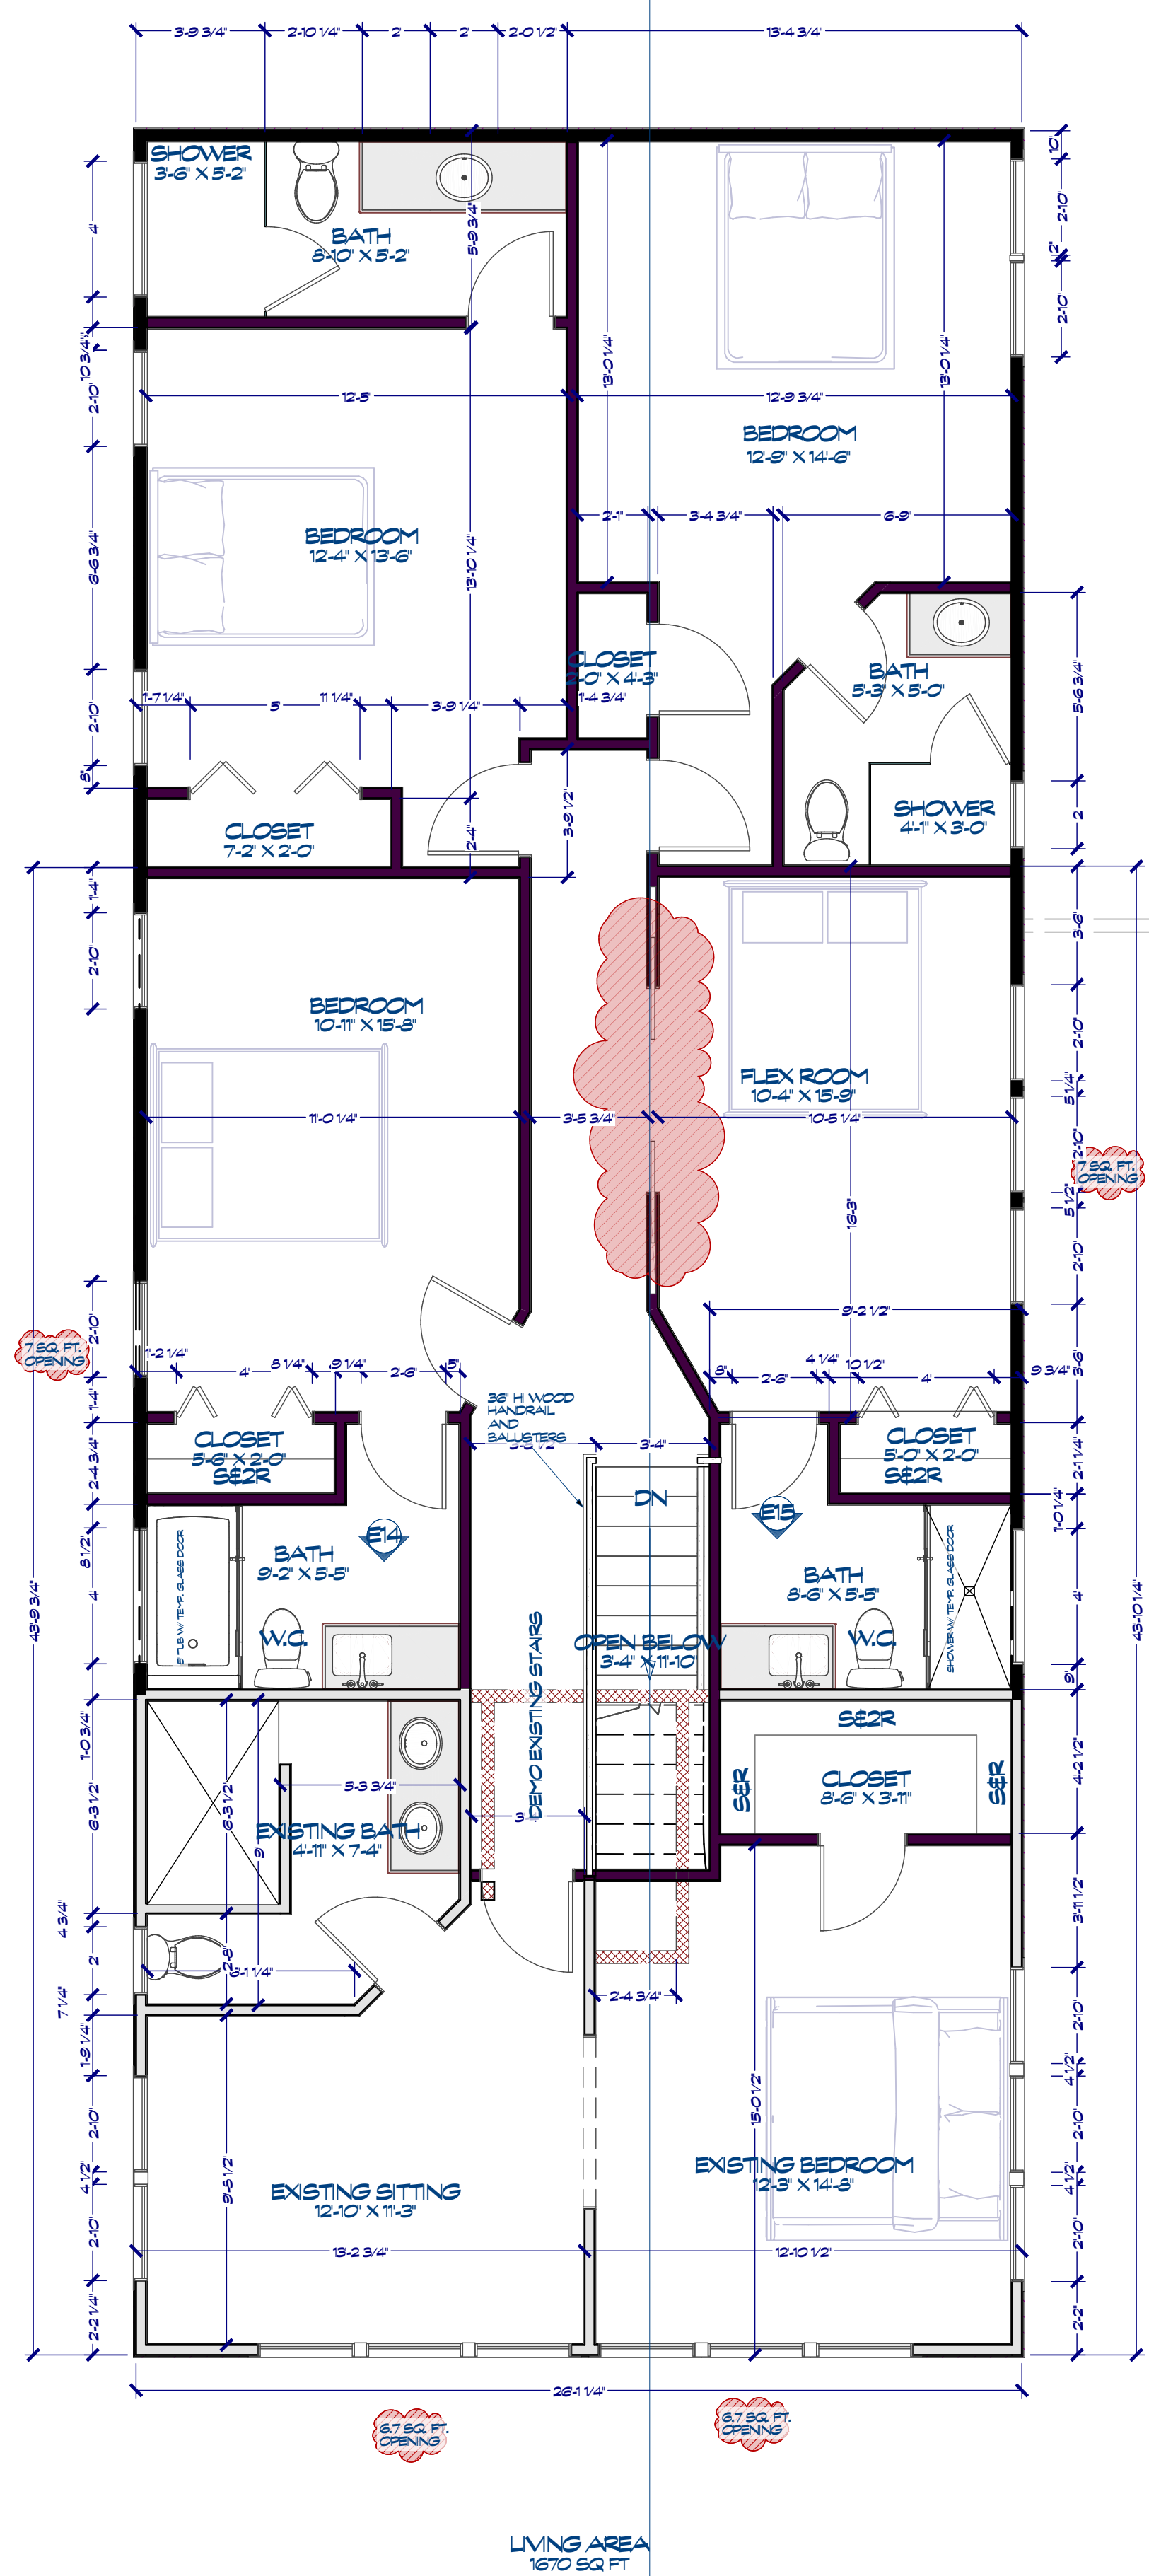

Floor Plan View Dimensioned

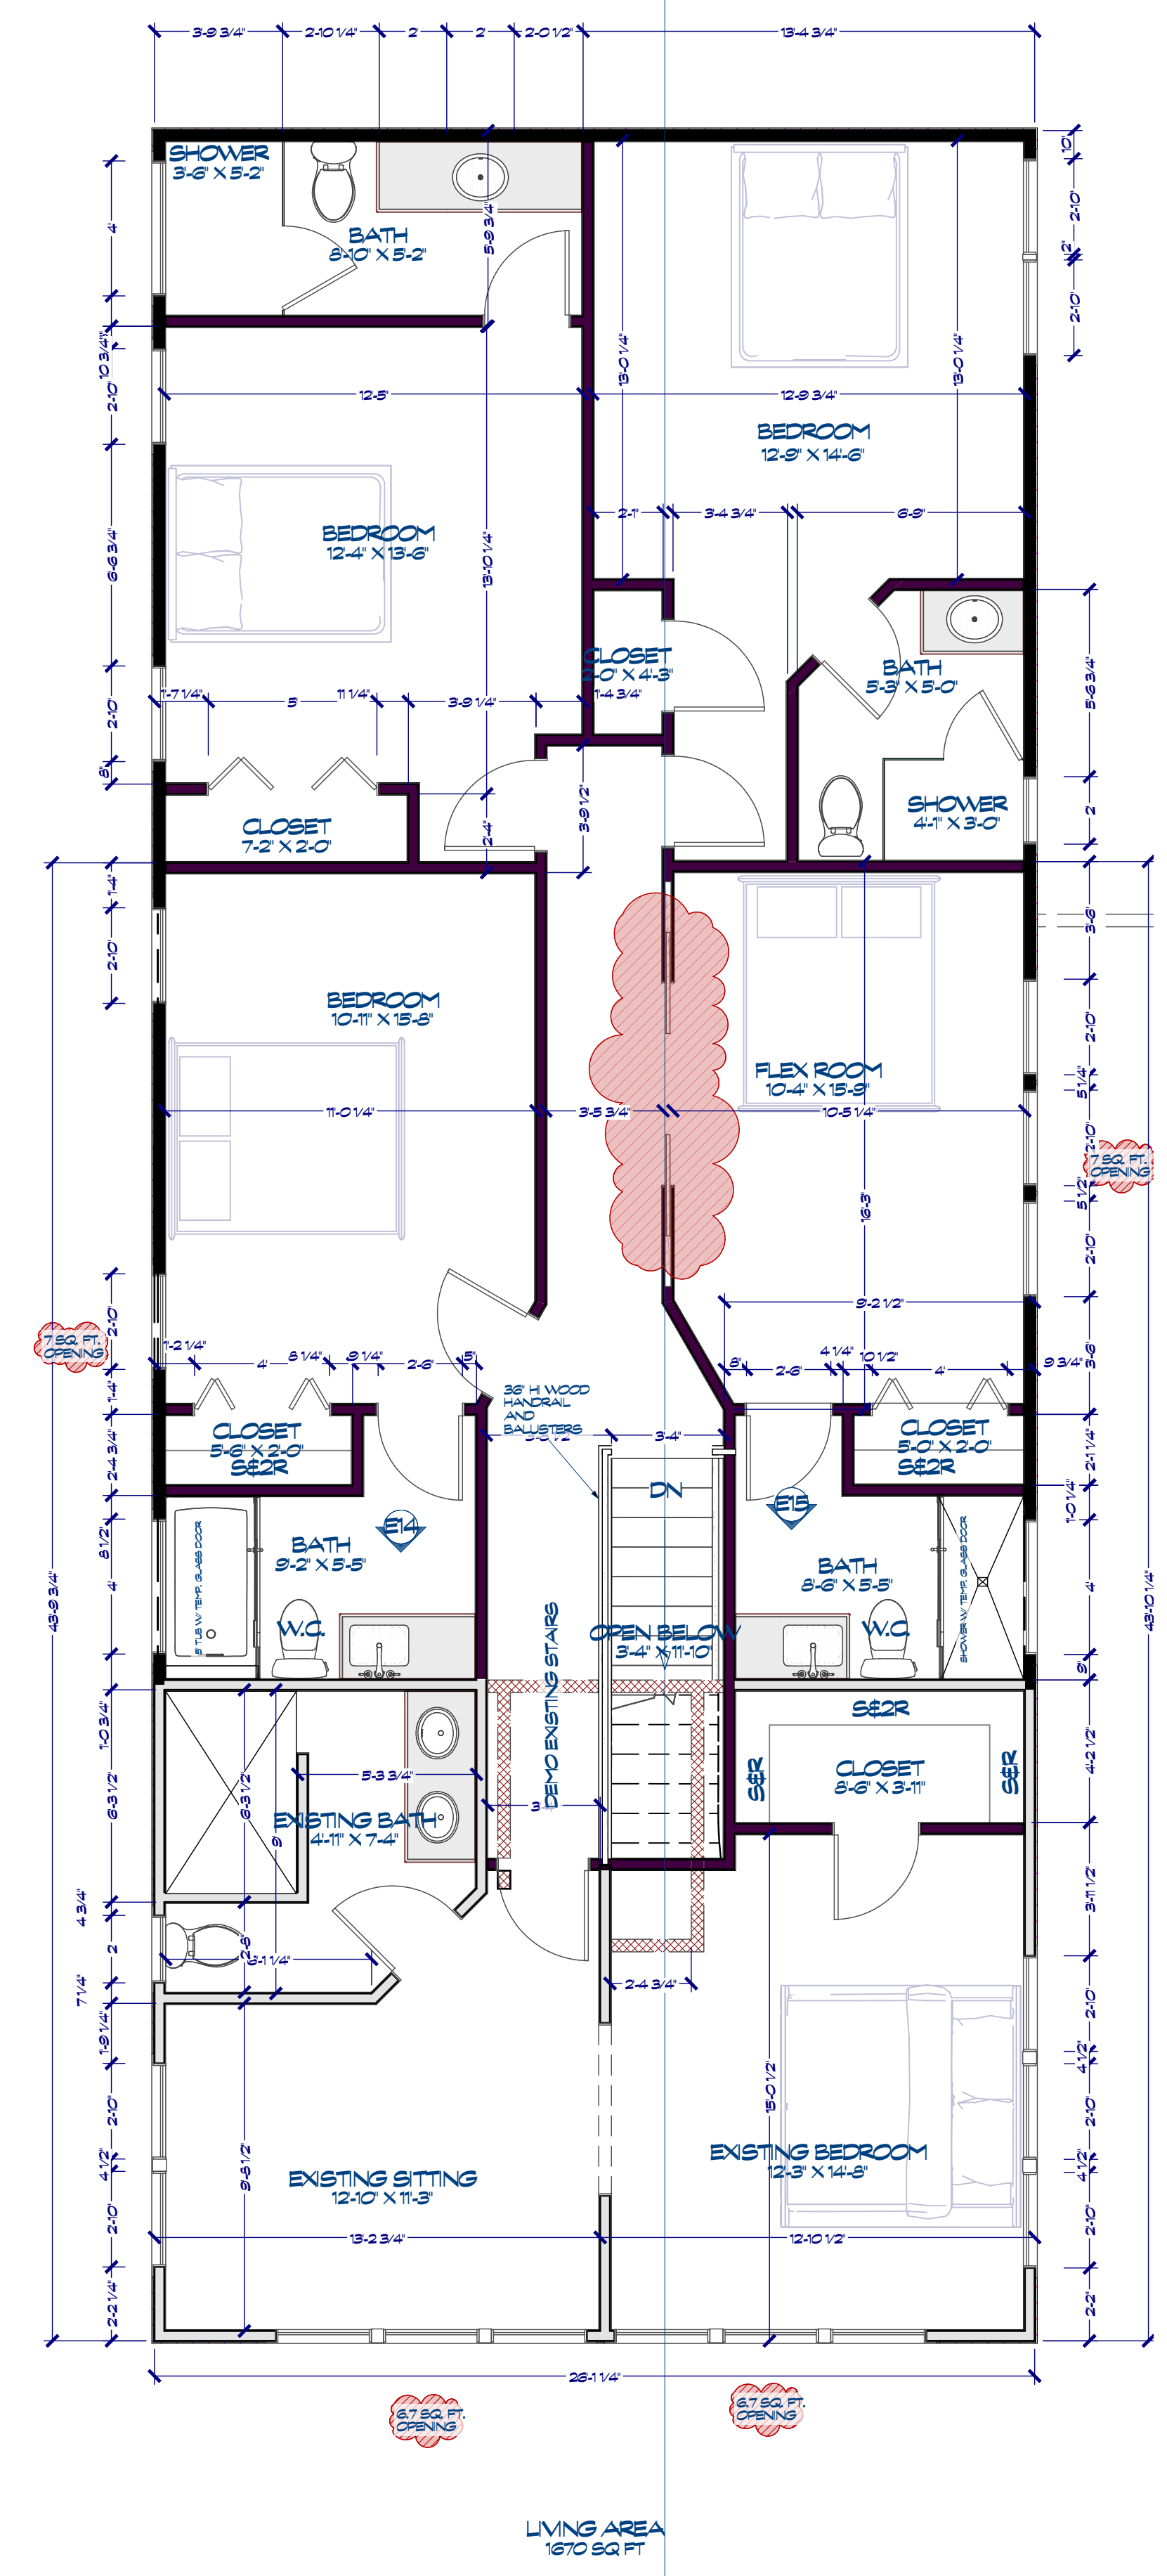

2nd Floor
 Added 2 Bedrooms and 2 Baths

800 Wilcrest Dr. Suite 120
 Houston, Texas 77042
 Office 713-759-8262
 Cell 713-806-1996

ENVISION
 Design/Build
 Creating the Future... Today

DRAWINGS PROVIDED BY:

DATE:
 2/8/2023

SCALE:
 1/4"=1'-0"

SHEET:
 A-14

