


A NEW RESIDENCE FOR:

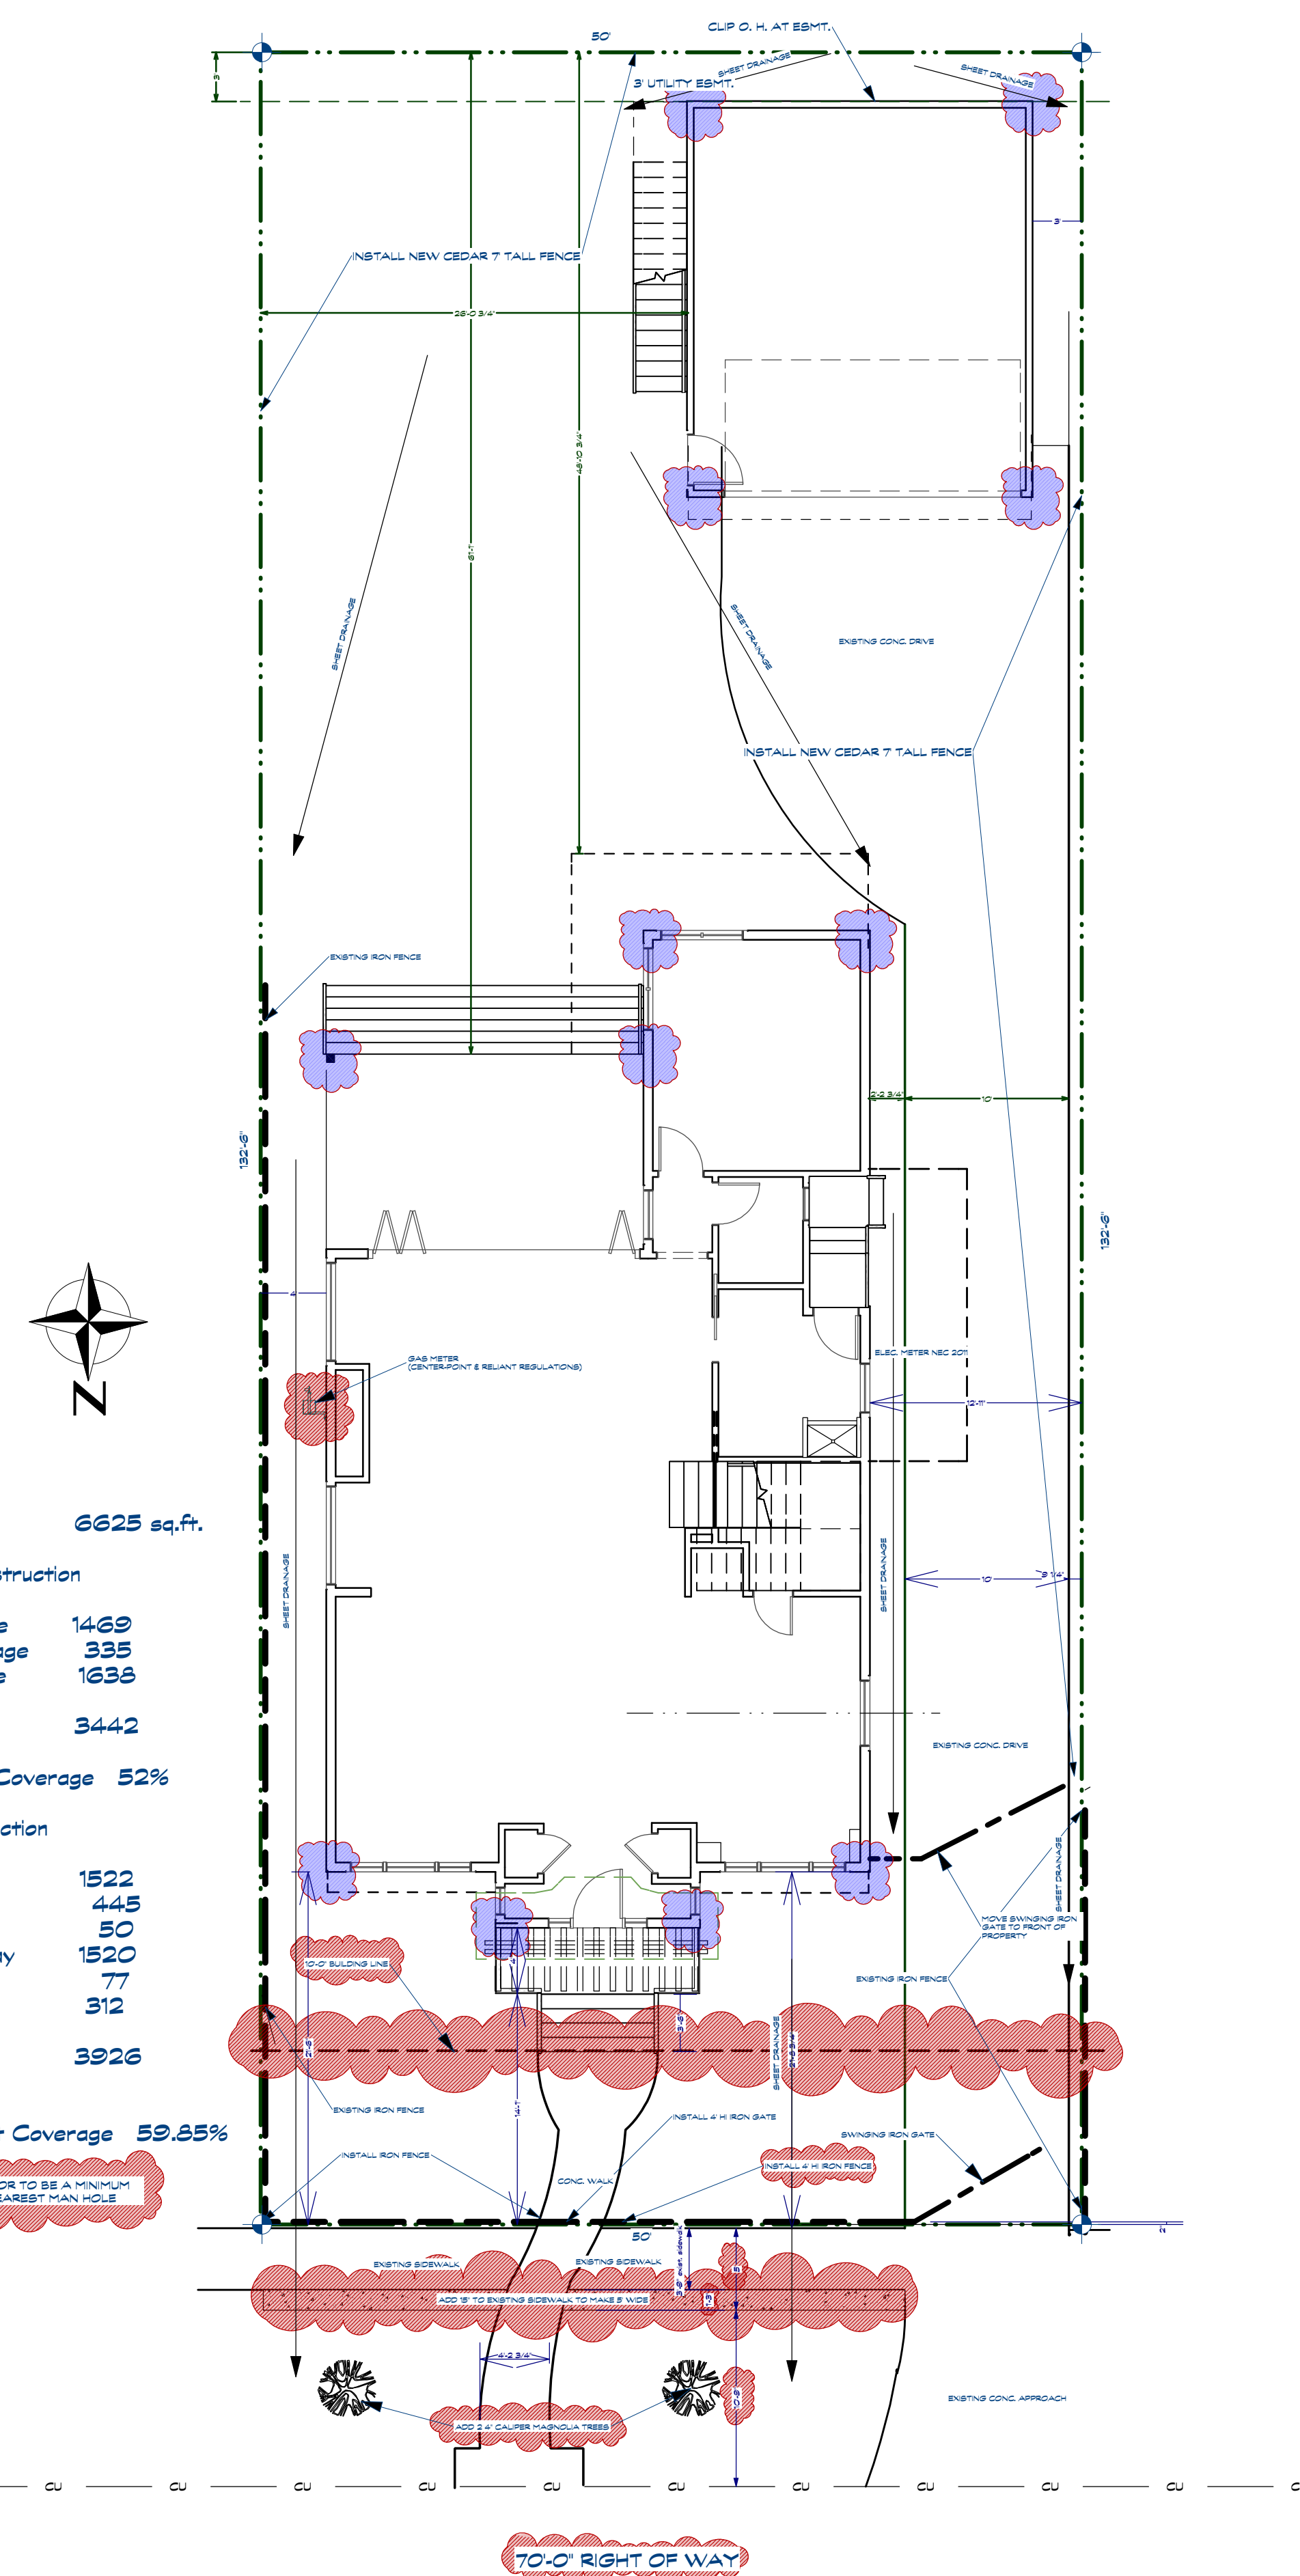

Site	6625 sq.ft.
Existing Construction	
Existing Home	1469
Existing Garage	335
Existing Drive	1638
Total	3442
Existing Lot Coverage	52%
New Construction	
New Home	1522
New Garage	445
Front Porch	50
New Driveway	1520
New Walk	77
Rear Porch	312
Total	3926
Proposed Lot Coverage	59.85%

FINISHED FLOOR TO BE A MINIMUM OF 12" ABOVE NEAREST MAN HOLE


Plot Plan View
scale 1/8"=1'-0"

NUMBER	DATE	REVISION TABLE	DESCRIPTION	CITY REV.
1	8-18-2021			

ENTISION
Design/Build
Creating the Future... Today

800 Wilcrest Dr. suite 120
Houston, Texas 77042
Office 713-789-5262
Cell 713-606-1996

DATE:	2/11/2022
SCALE:	1/4" = 1'-0"
SHEET:	A - 1

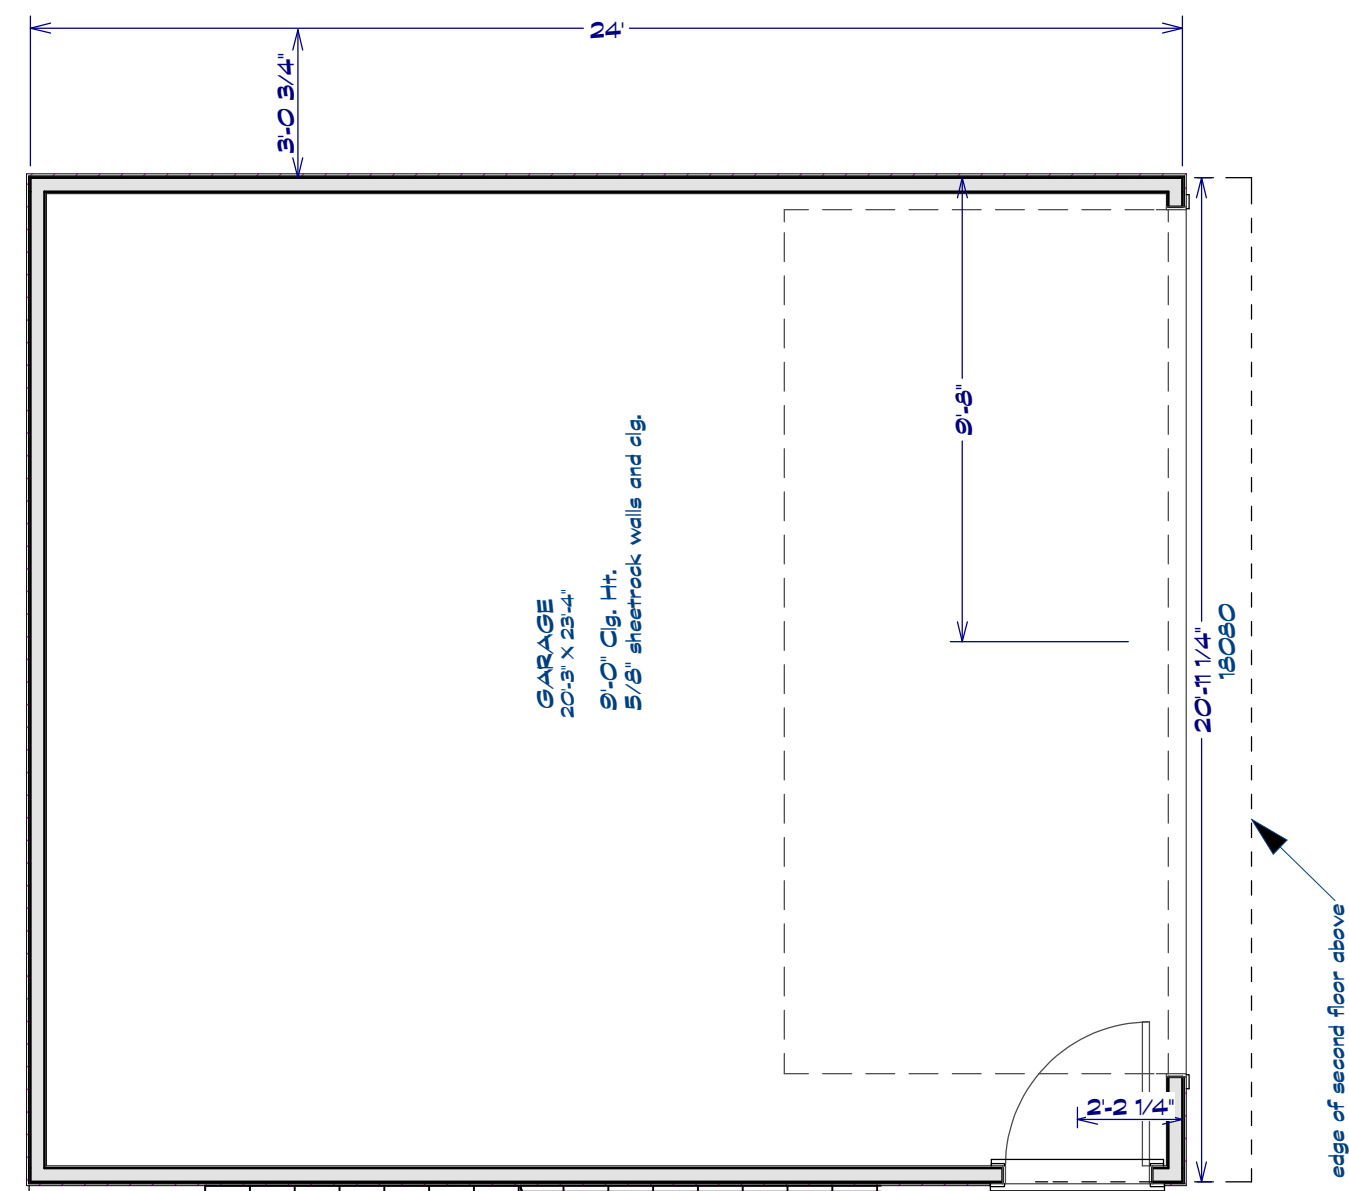


GENERAL NOTES:

- 10' ceiling at first floor
- 9' ceiling at second floor
- 9'-0" Hd. Ht. at First Flr.
- 8'-6" Hd. Ht. at Second Flr.
- 1 3/8" s.c. int. doors
- 1 3/4" fiberglass exterior doors
- 1"x6" baseboards at fir. flr.
- 1"x6" baseboards at sec. flr.
- 1"x4" casing at doors and windows w/ 1"x6" header and 1"x2" abv.
- Anderson 100 series windows Low E 202 IRC R310.1


THIS PROJECT WILL COMPLY WITH:

- 2012 IRC with COH amendments
- 2012 UMC
- 2012 UPC
- 2017 NEC
- 2012 IRC
- 2015 international energy conservation code or ASHRAE 90.1-2013

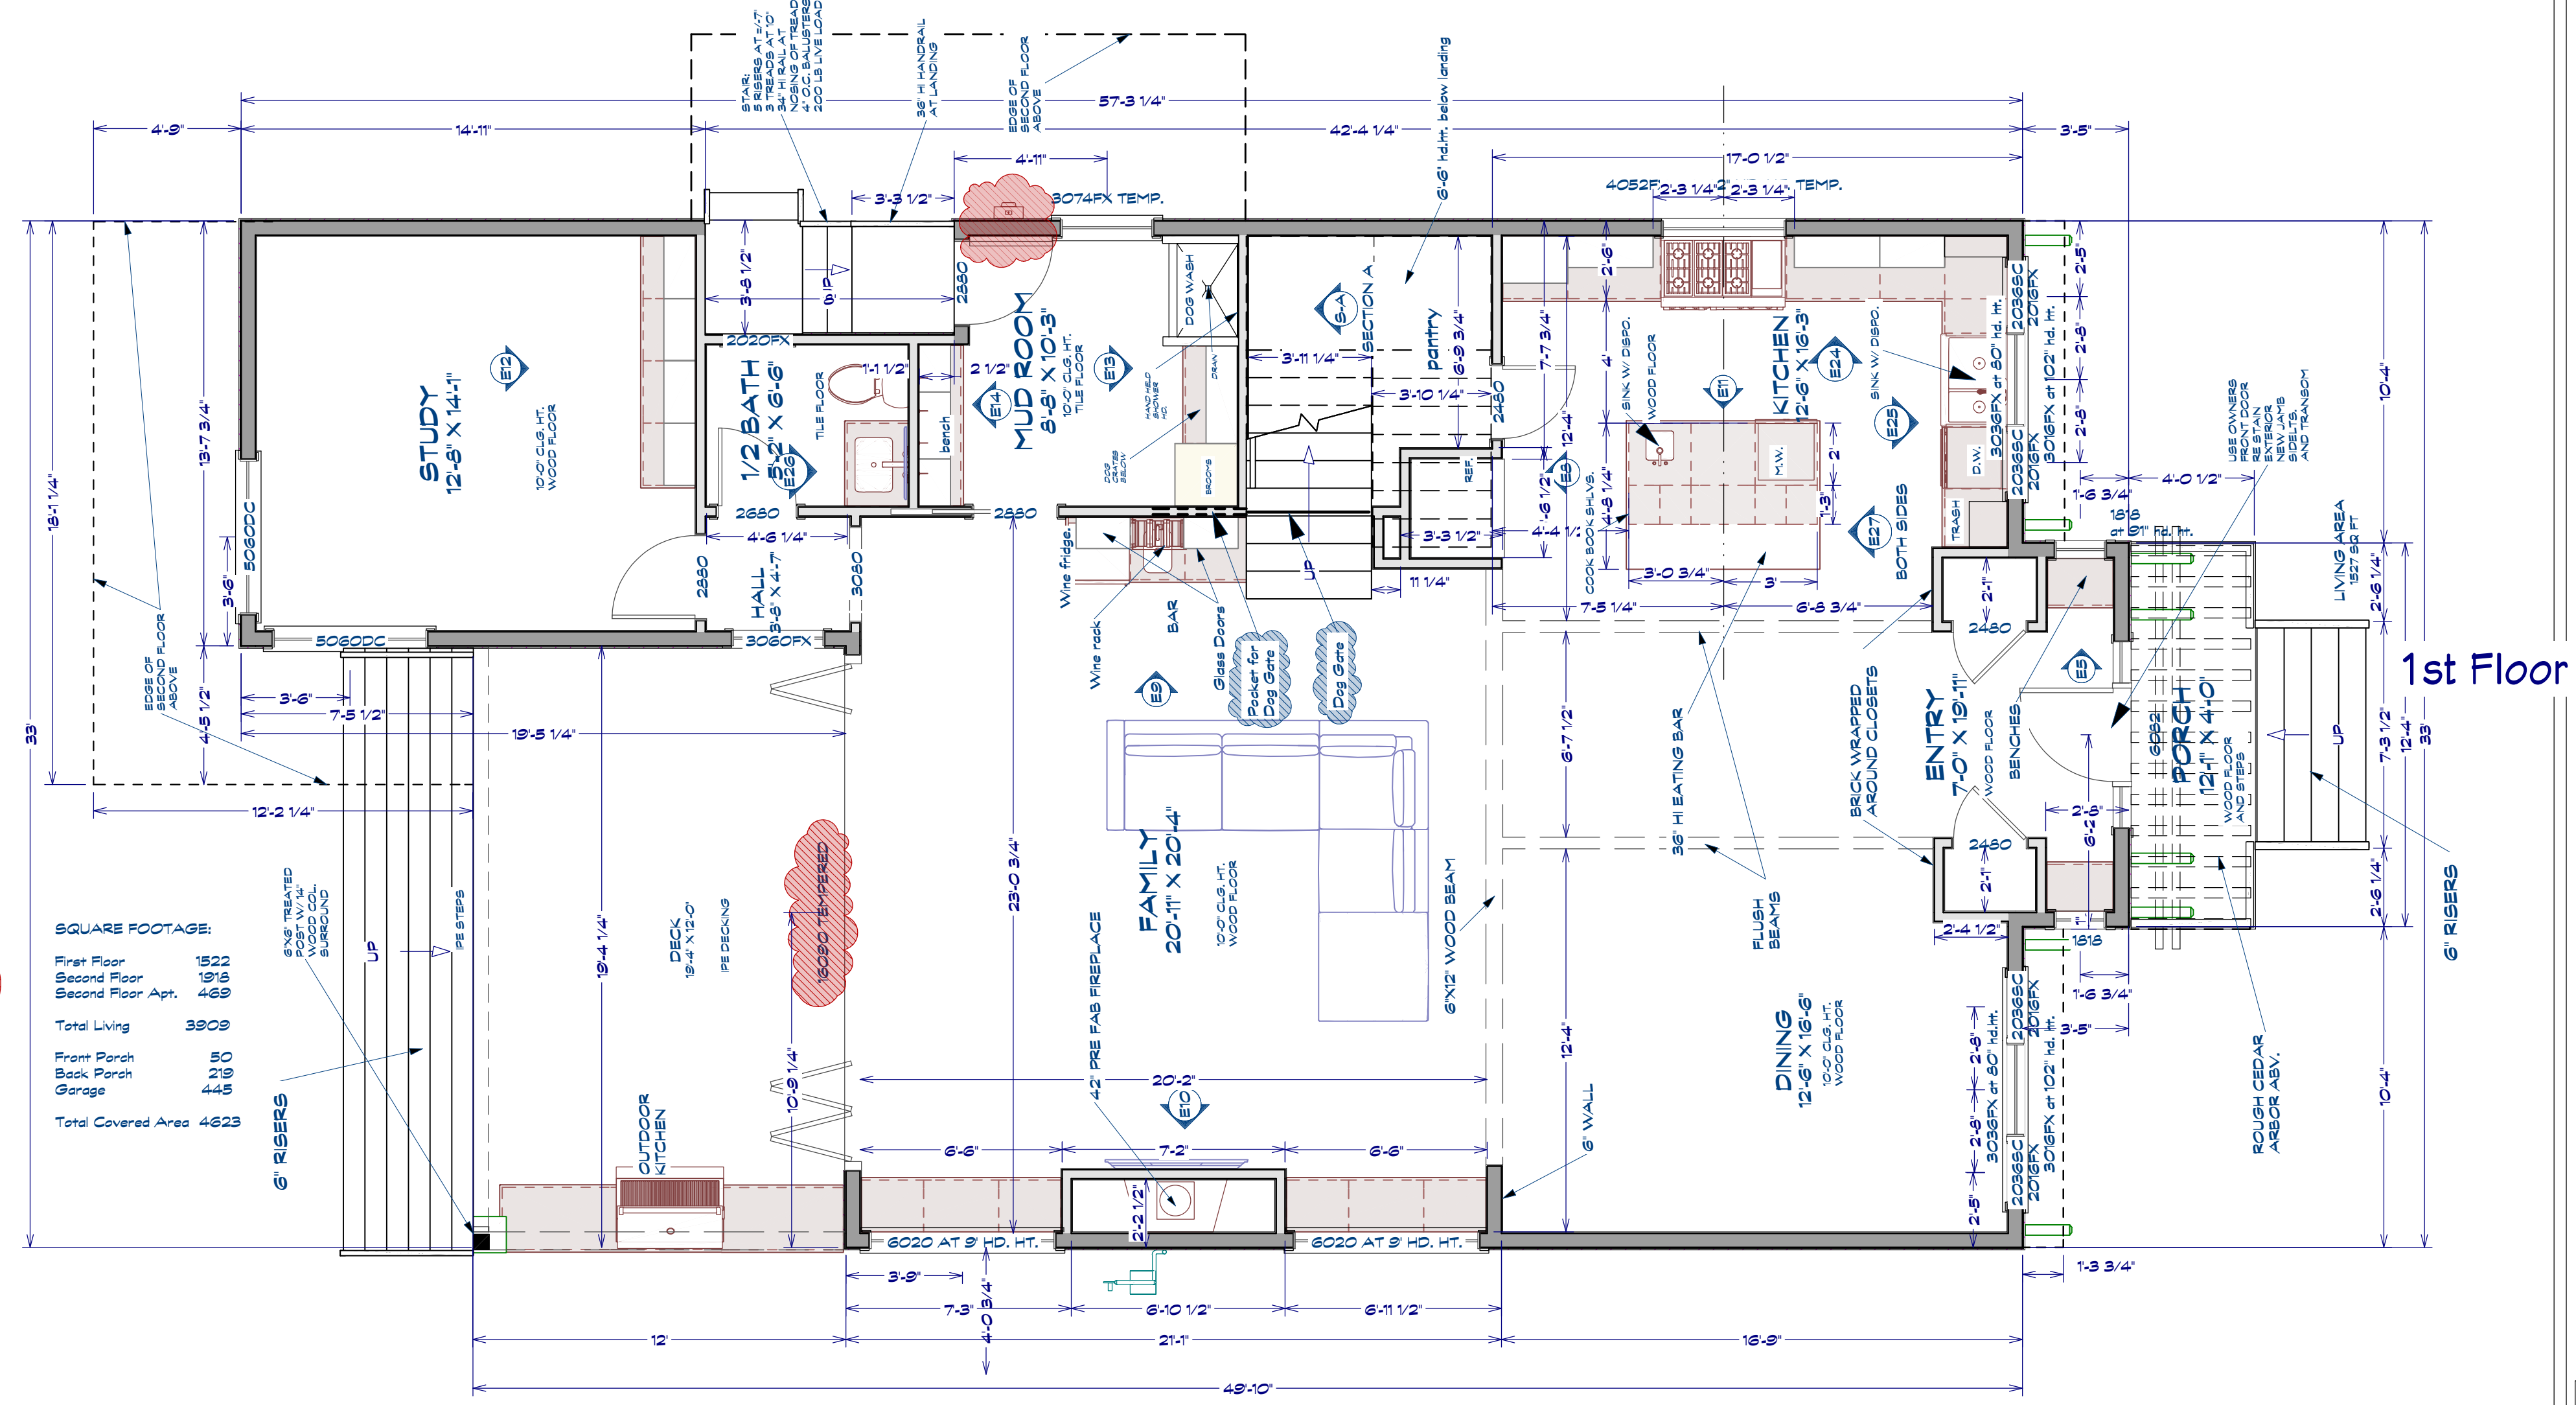

SQUARE FOOTAGE:

First Floor	1522
Second Floor	1818
Second Floor Apt.	488
Total Living	3308
Front Porch	50
Back Porch	218
Garage	448
Total Covered Area	4623

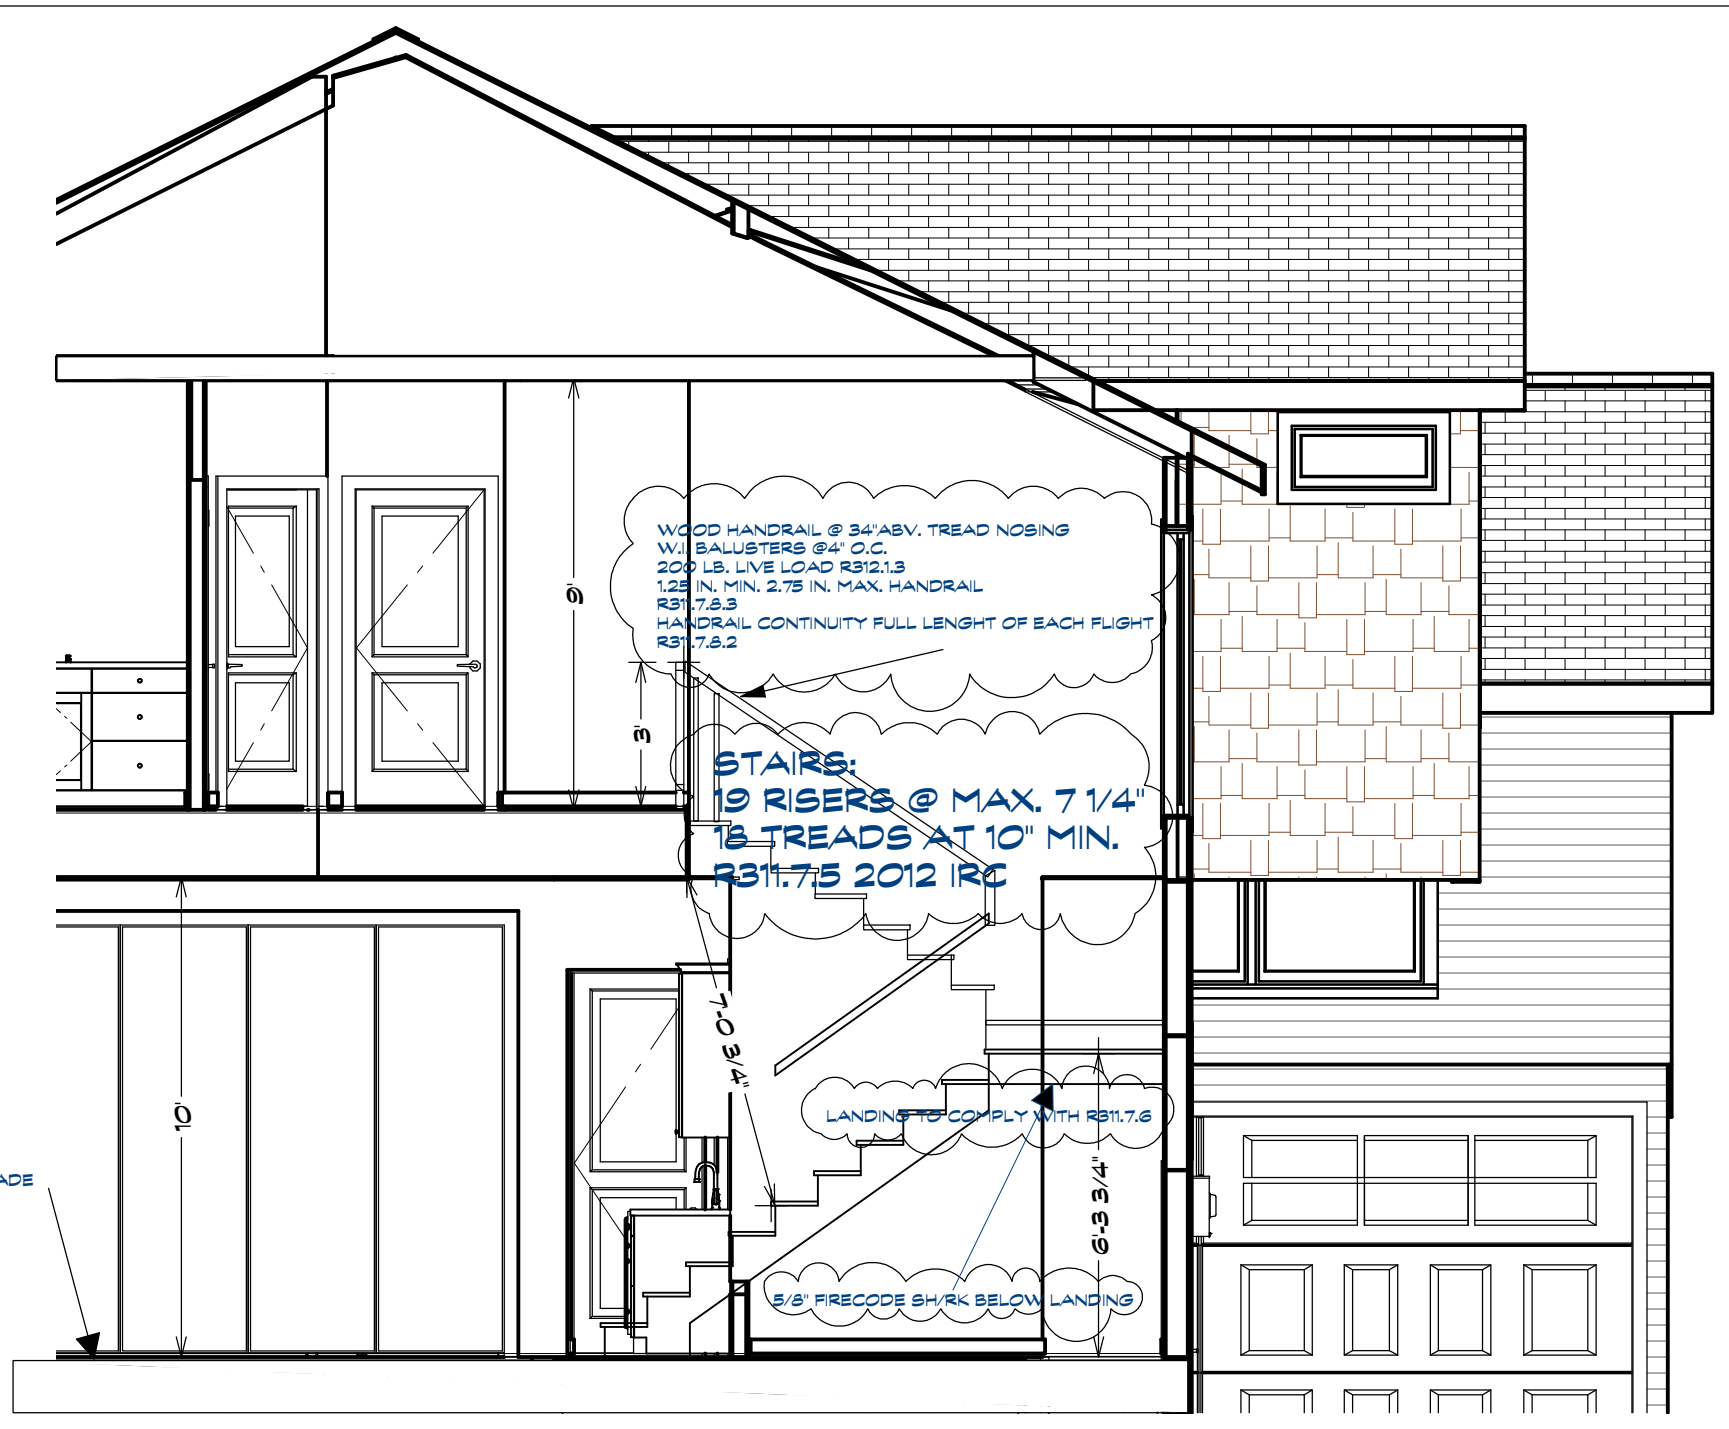


SECTION A

REVISION TABLE

NUMBER	DATE	REVISION BY	DESCRIPTION
1	8-16-2021		CITY REV.



500 Wilcrest Dr. Suite 120
Houston, Texas 77042
Office 713-789-5262
Cell 713-606-1996

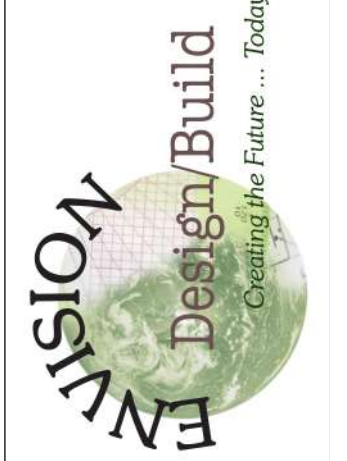

DATE:
2/11/2022

SCALE:
1/4" = 1'-0"

SHEET:
A - 2

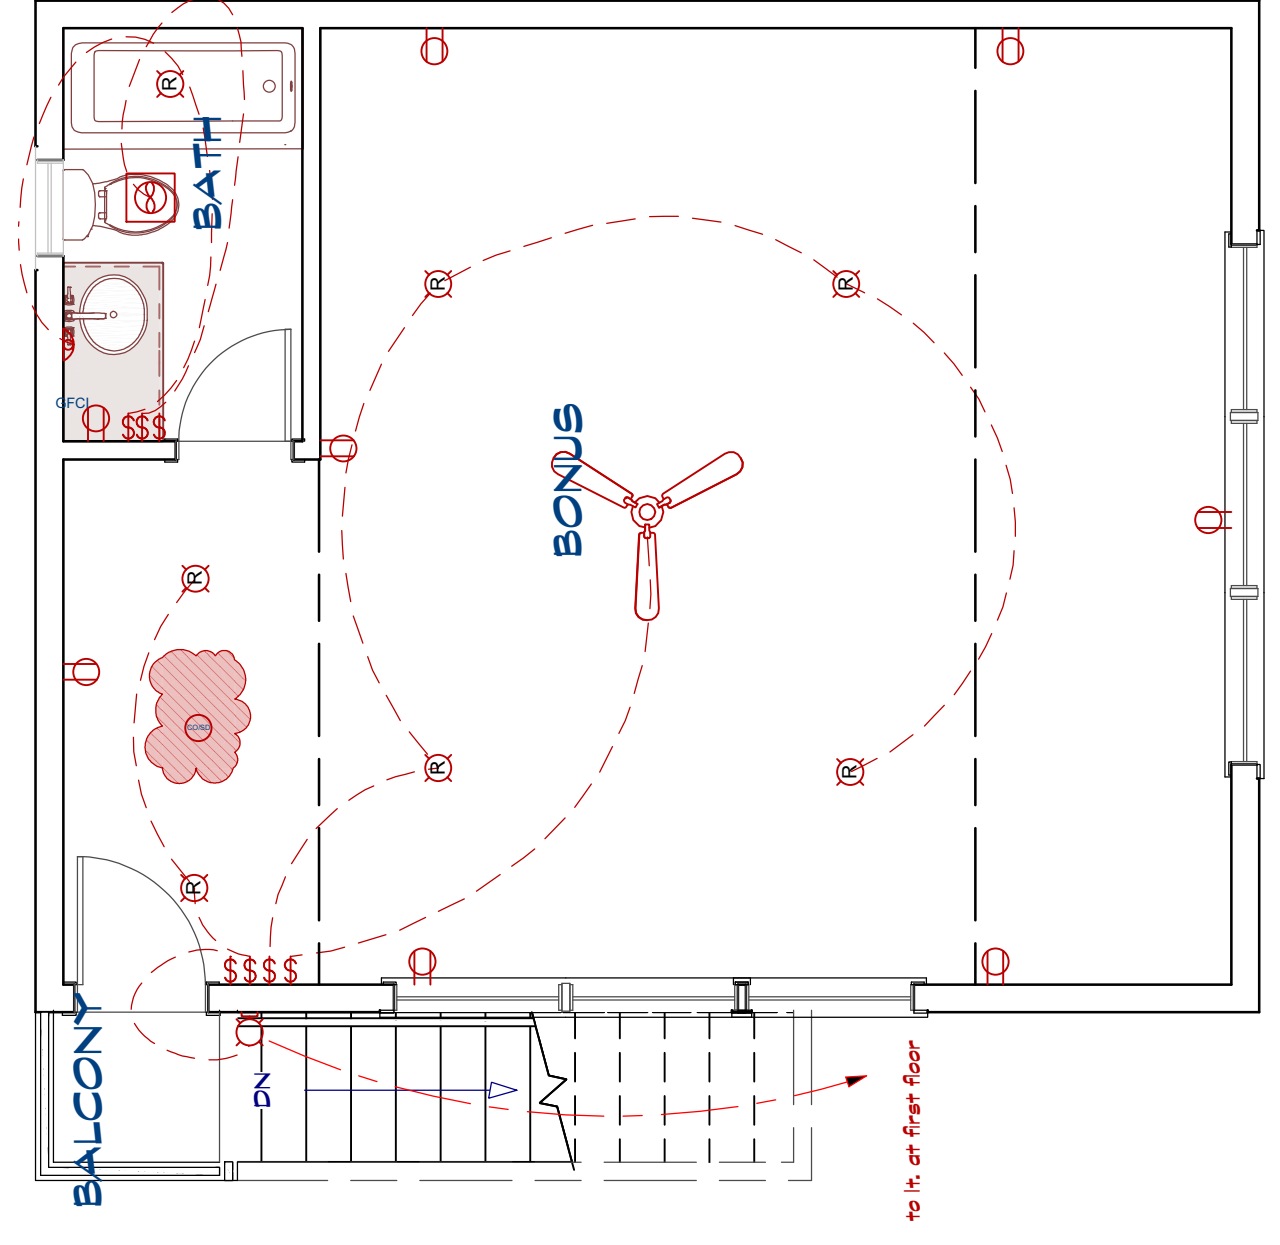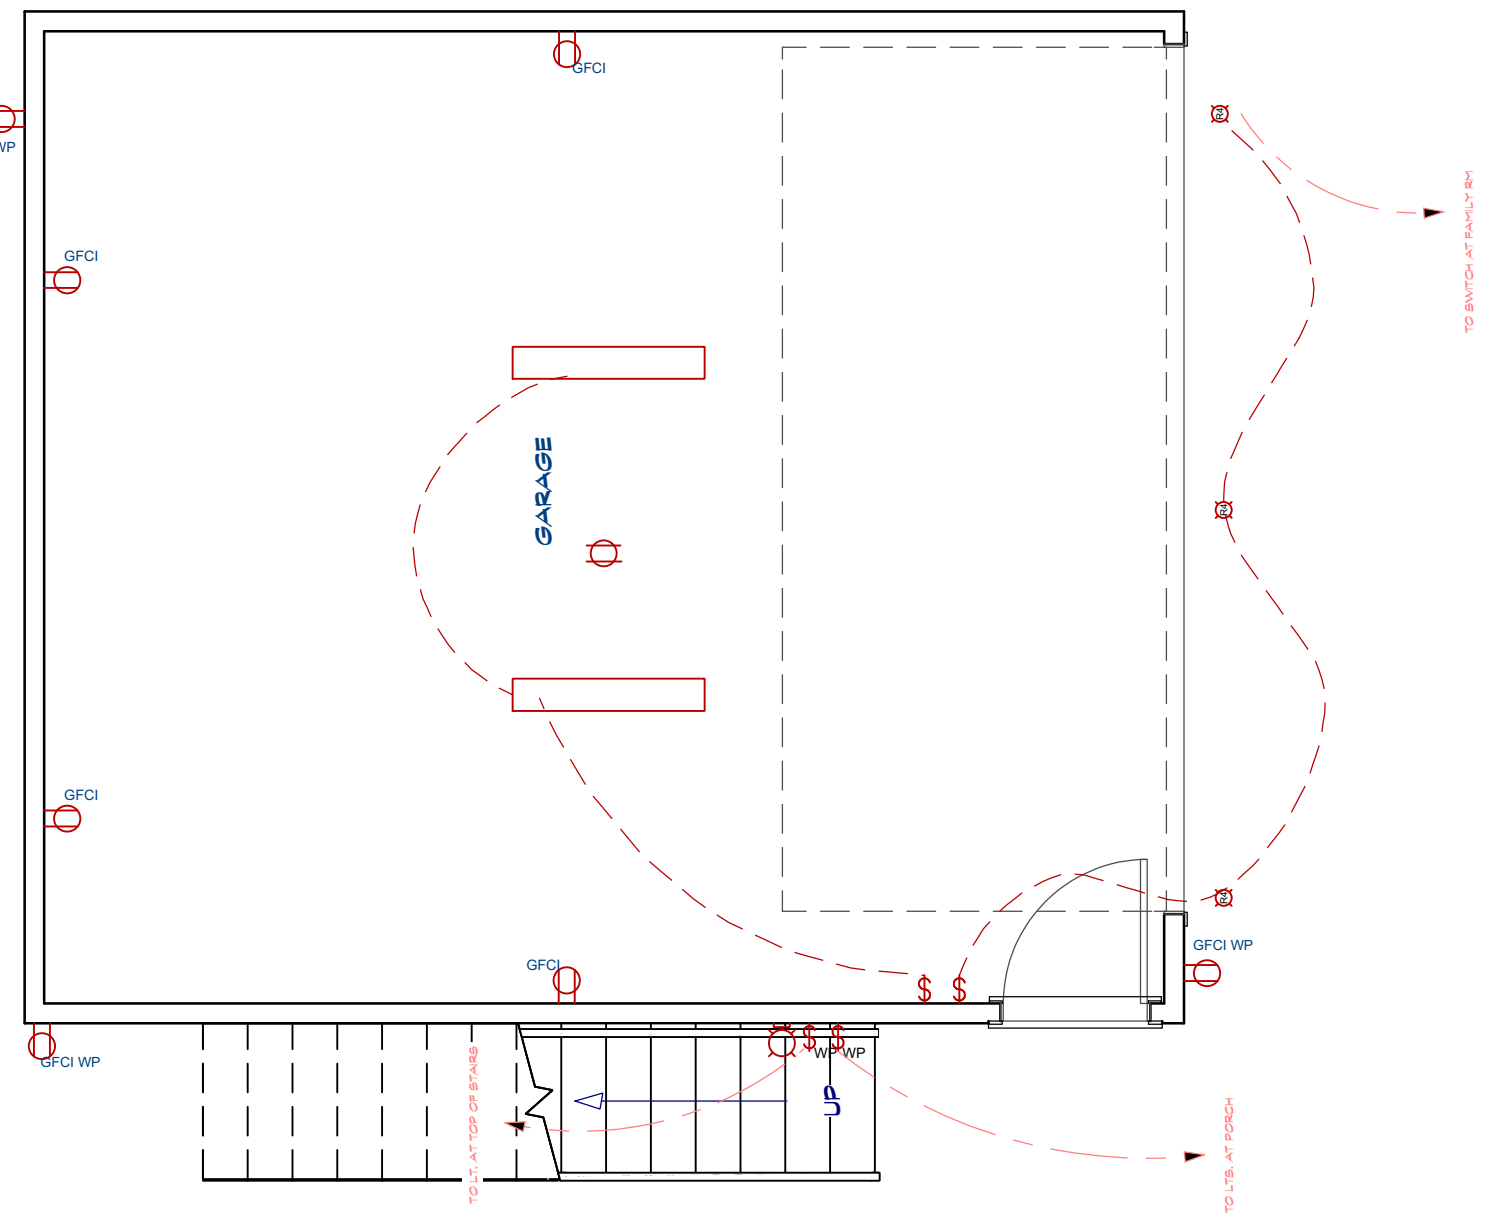

LIVING AREA
530 SQ FT

SYMBOL	DESCRIPTION
(Symbol)	120V
(Symbol)	240V
(Symbol)	3-Phase
(Symbol)	3-Phase 4-Wire
(Symbol)	3-Phase 3-Wire
(Symbol)	3-Phase 2-Wire
(Symbol)	3-Phase 1-Wire
(Symbol)	3-Phase 0-Wire
(Symbol)	3-Phase 1-Wire 2-Phase
(Symbol)	3-Phase 2-Wire 2-Phase
(Symbol)	3-Phase 3-Wire 2-Phase
(Symbol)	3-Phase 100-Wire 2-Phase

ELECTRICAL NOTES:
 ALL PLUGS WHERE APPLICABLE TO BE HORIZONTAL IN BASEBOARDS
 ALL SHOCK DET. TO BE 10V W/ BATTERY BACKUP INTERCONNECTED
 ALL APPLIANCES TO BE ON SEPARATE CIRCUITS
 ALL BREAKERS TO BE ON SEPARATE CIRCUITS
 METER TO BE LOCATED ON EXTERIOR WALL OF MUD (WEST SIDE)
 BREAKER PANEL TO BE LOCATED IN MUD ROOM
 ALL LIGHTS TO BE LED
 ALL LIGHTS TO BE LED

TO GARAGE

TO PORCH


TO HALL

TO BATH

TO BEDROOM


TO KITCHEN

TO LIVING AREA

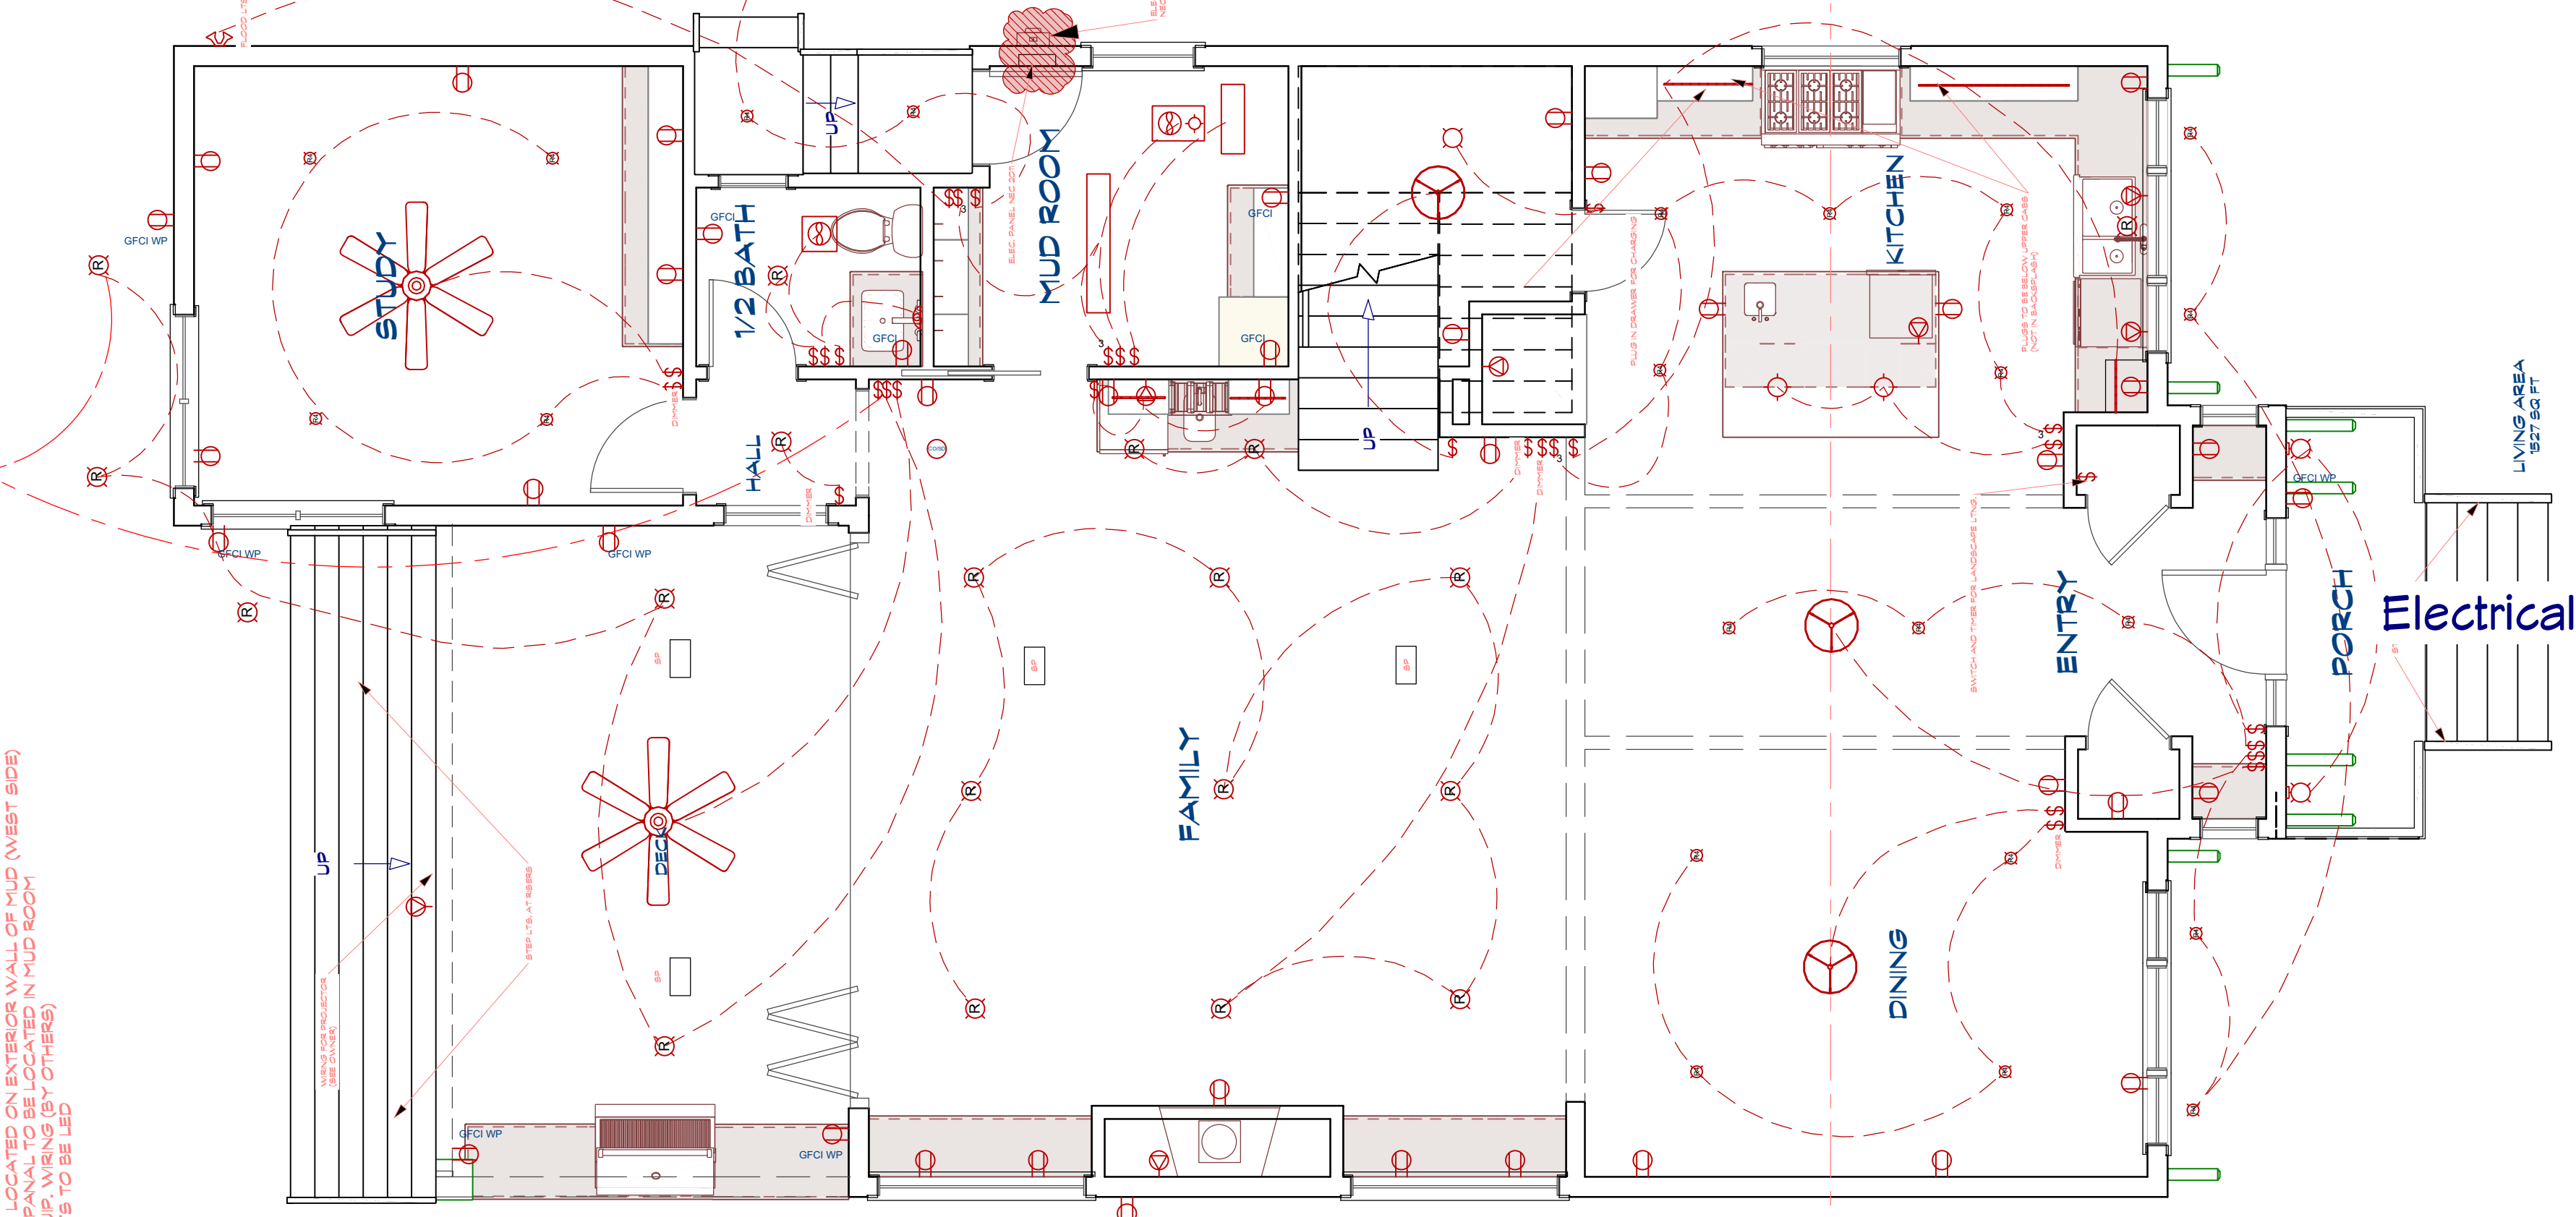

Electrical Plan View

LIVING AREA
1227 SQ FT

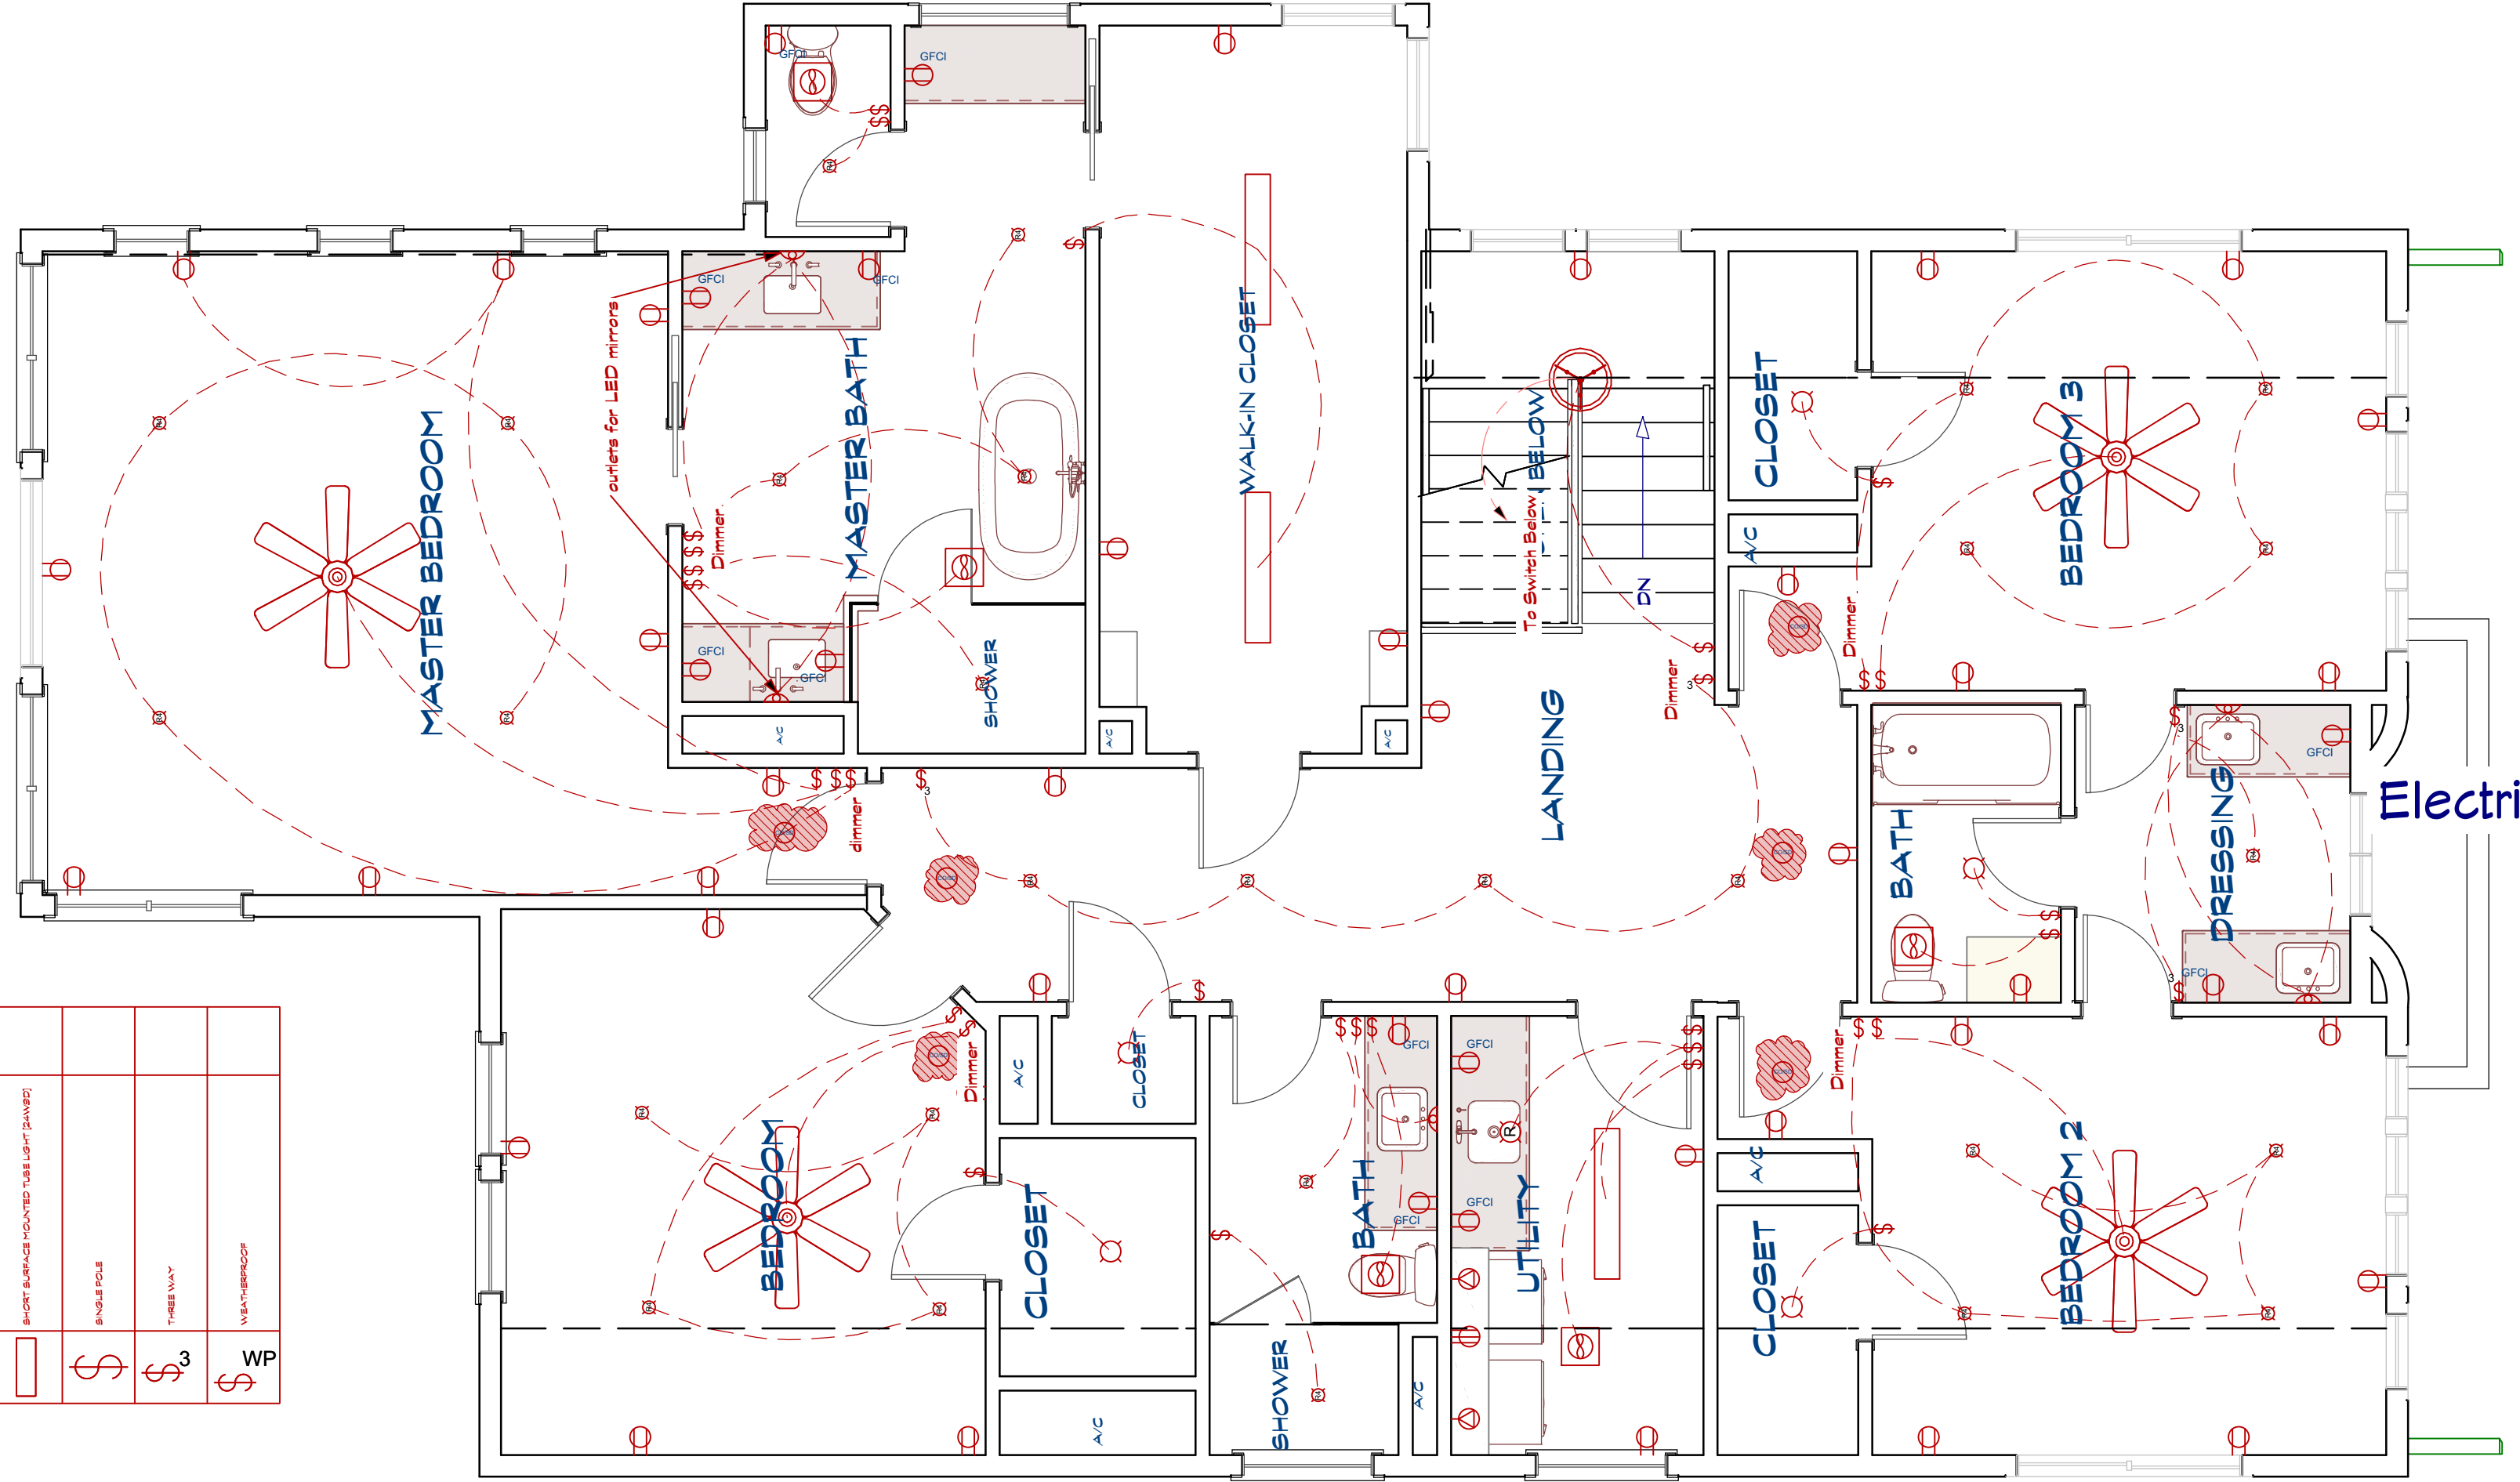



Electrical Plan View

ENTISION
 Design/Build
 Creating the Future... Today


500 Wilcrest Dr. Suite 120
 Houston, Texas 77042
 Office 713-789-5262
 Cell 713-606-1996

REVISION TABLE	DESCRIPTION	CITY REV.
NUMBER	DATE	REVISED BY
1	8-16-2021	


DATE: 2/11/2022
 SCALE: 1/4" = 1'-0"
 SHEET: A-4

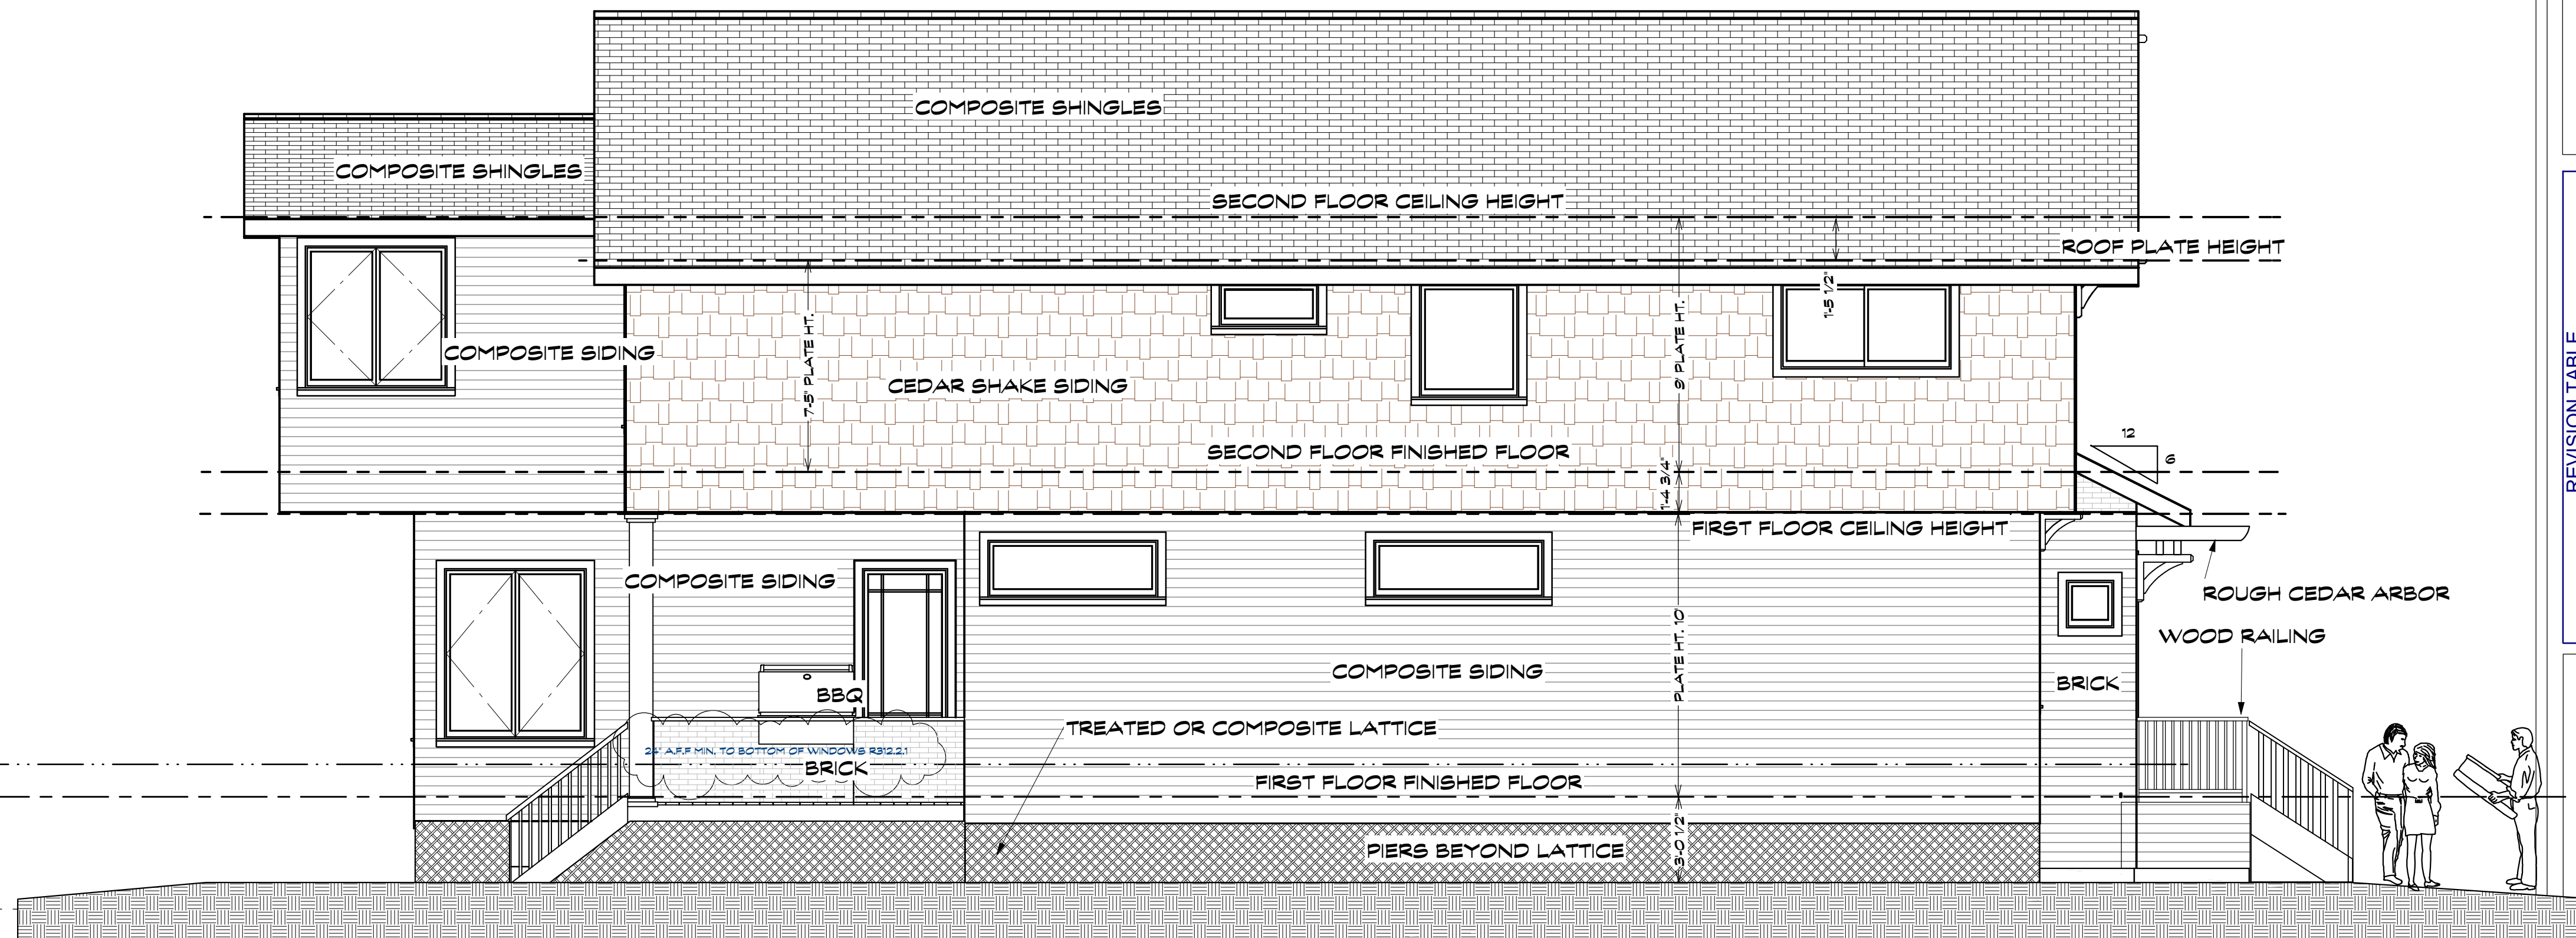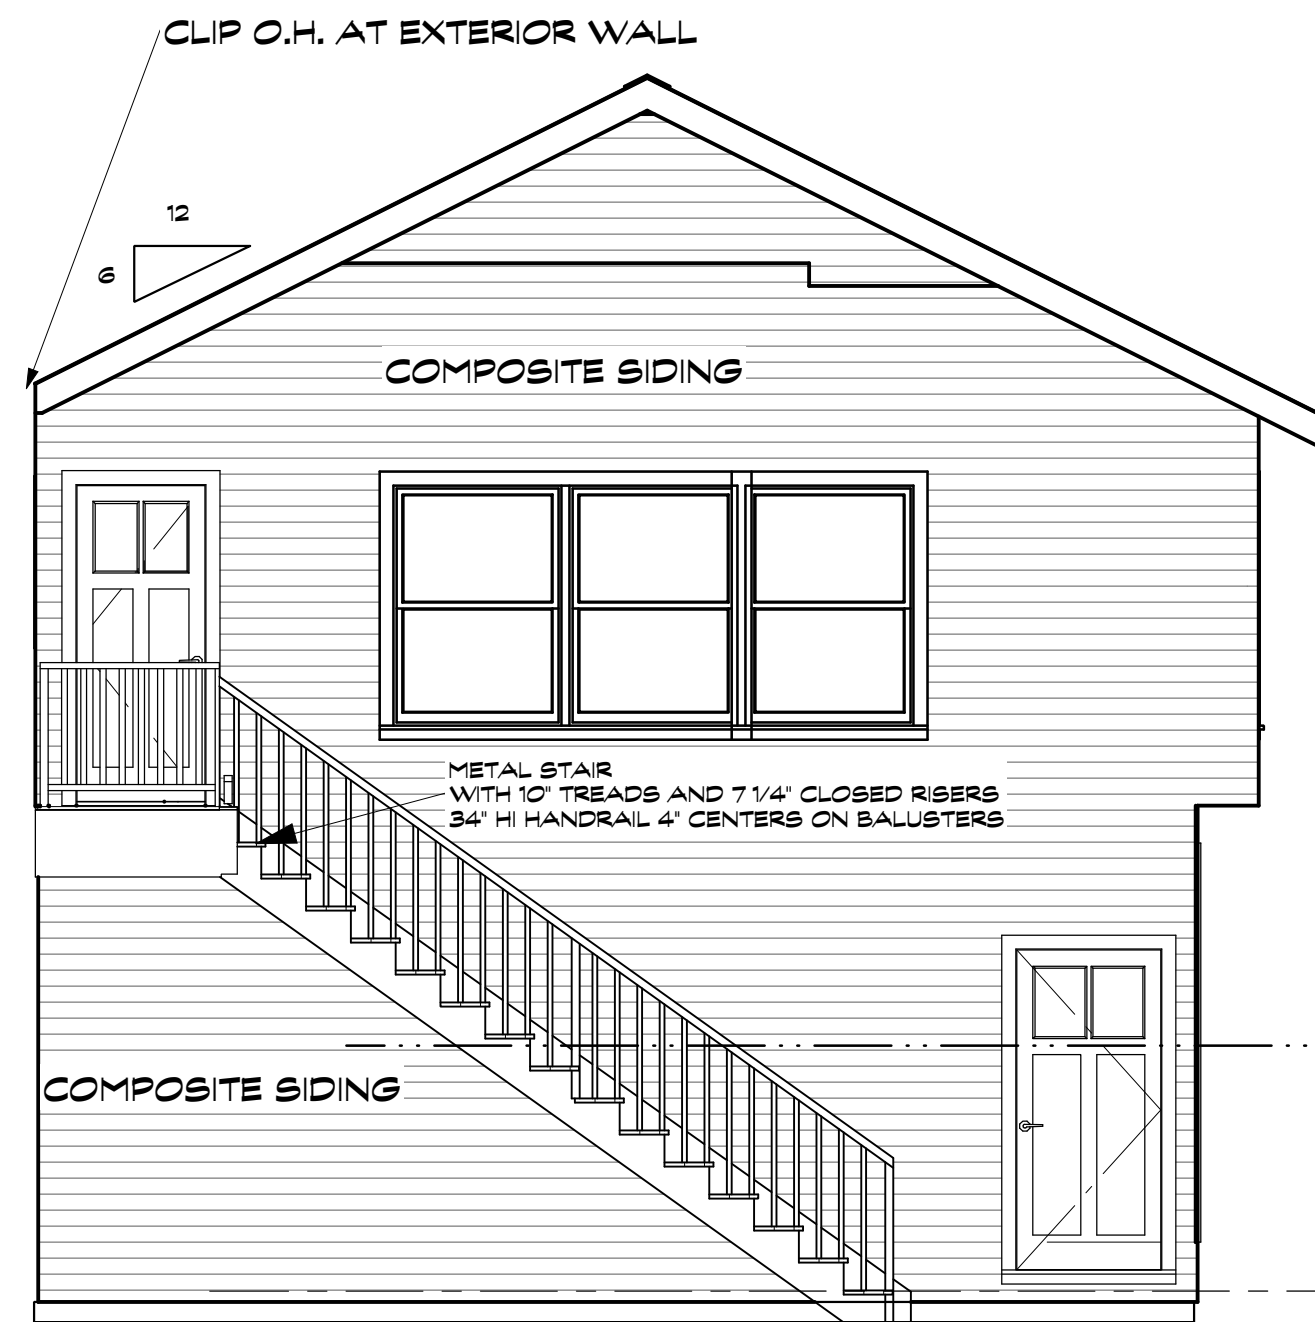


Elevation 3

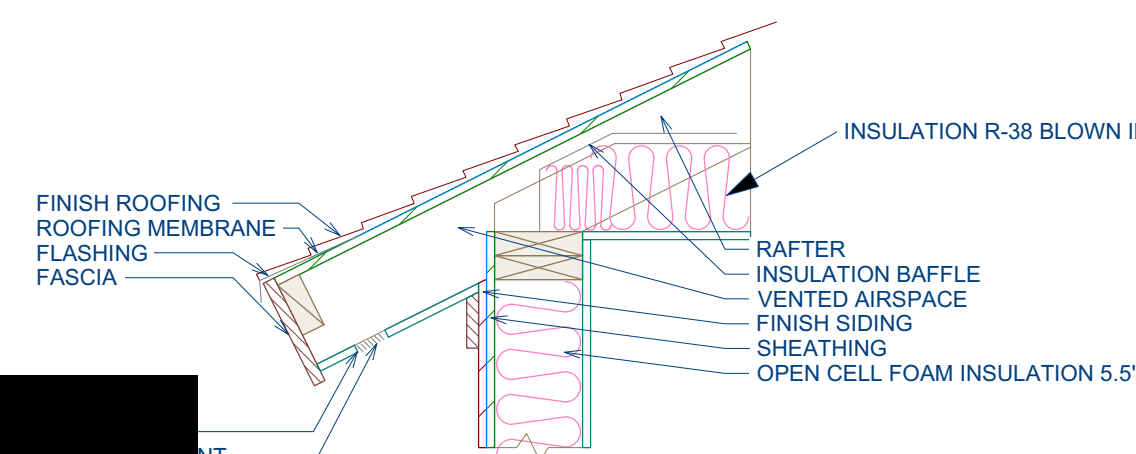


Boxed in Eave
(print at 1"=1')

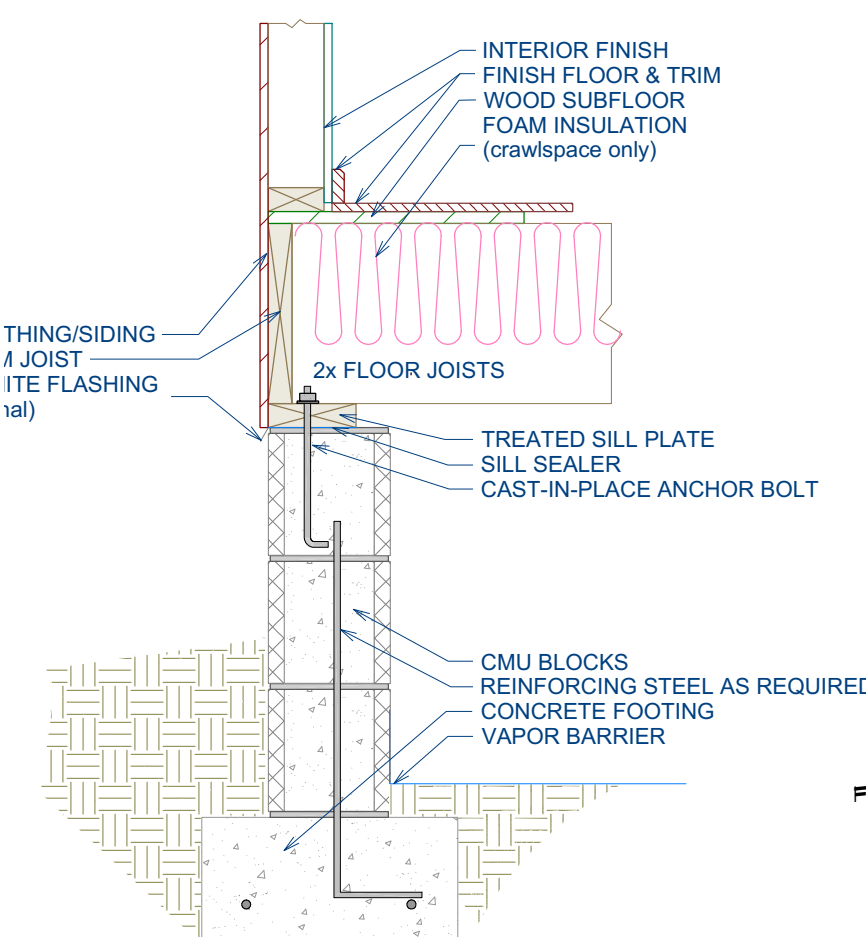

Typical CMU Crawl Space
(print at 1"=1')

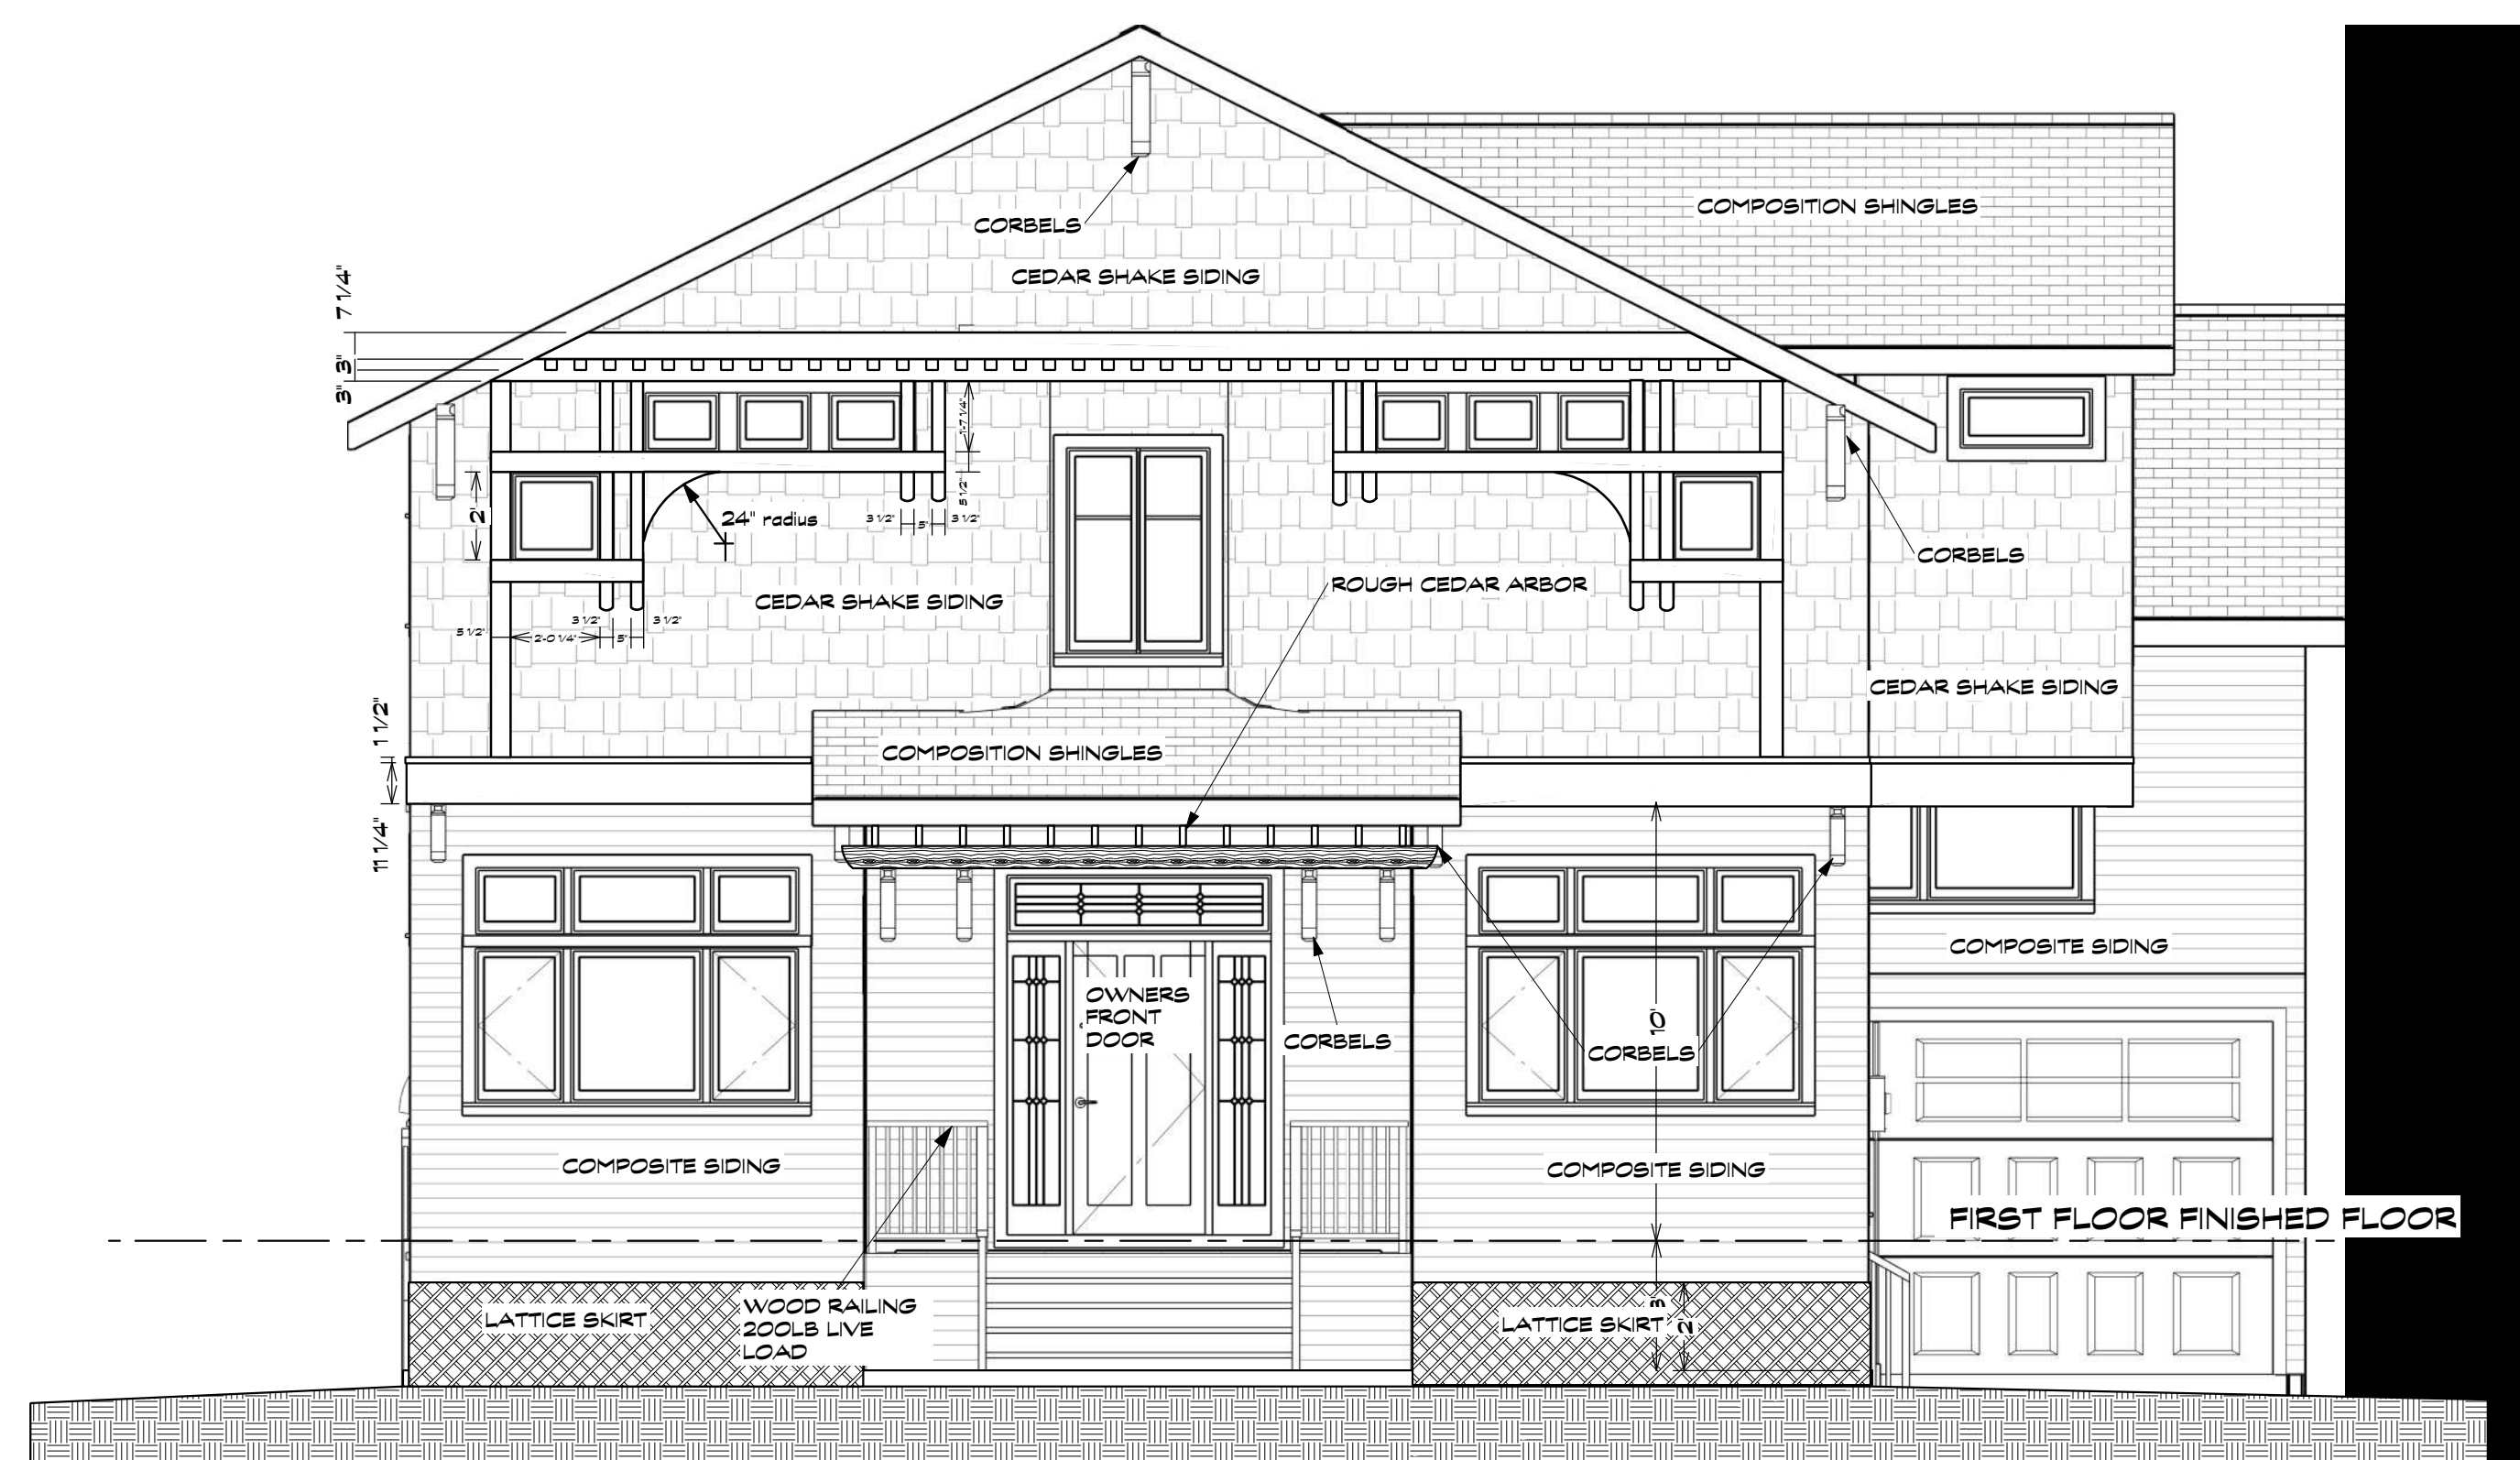

Front Elevation
scale 1/4"=1'-0"

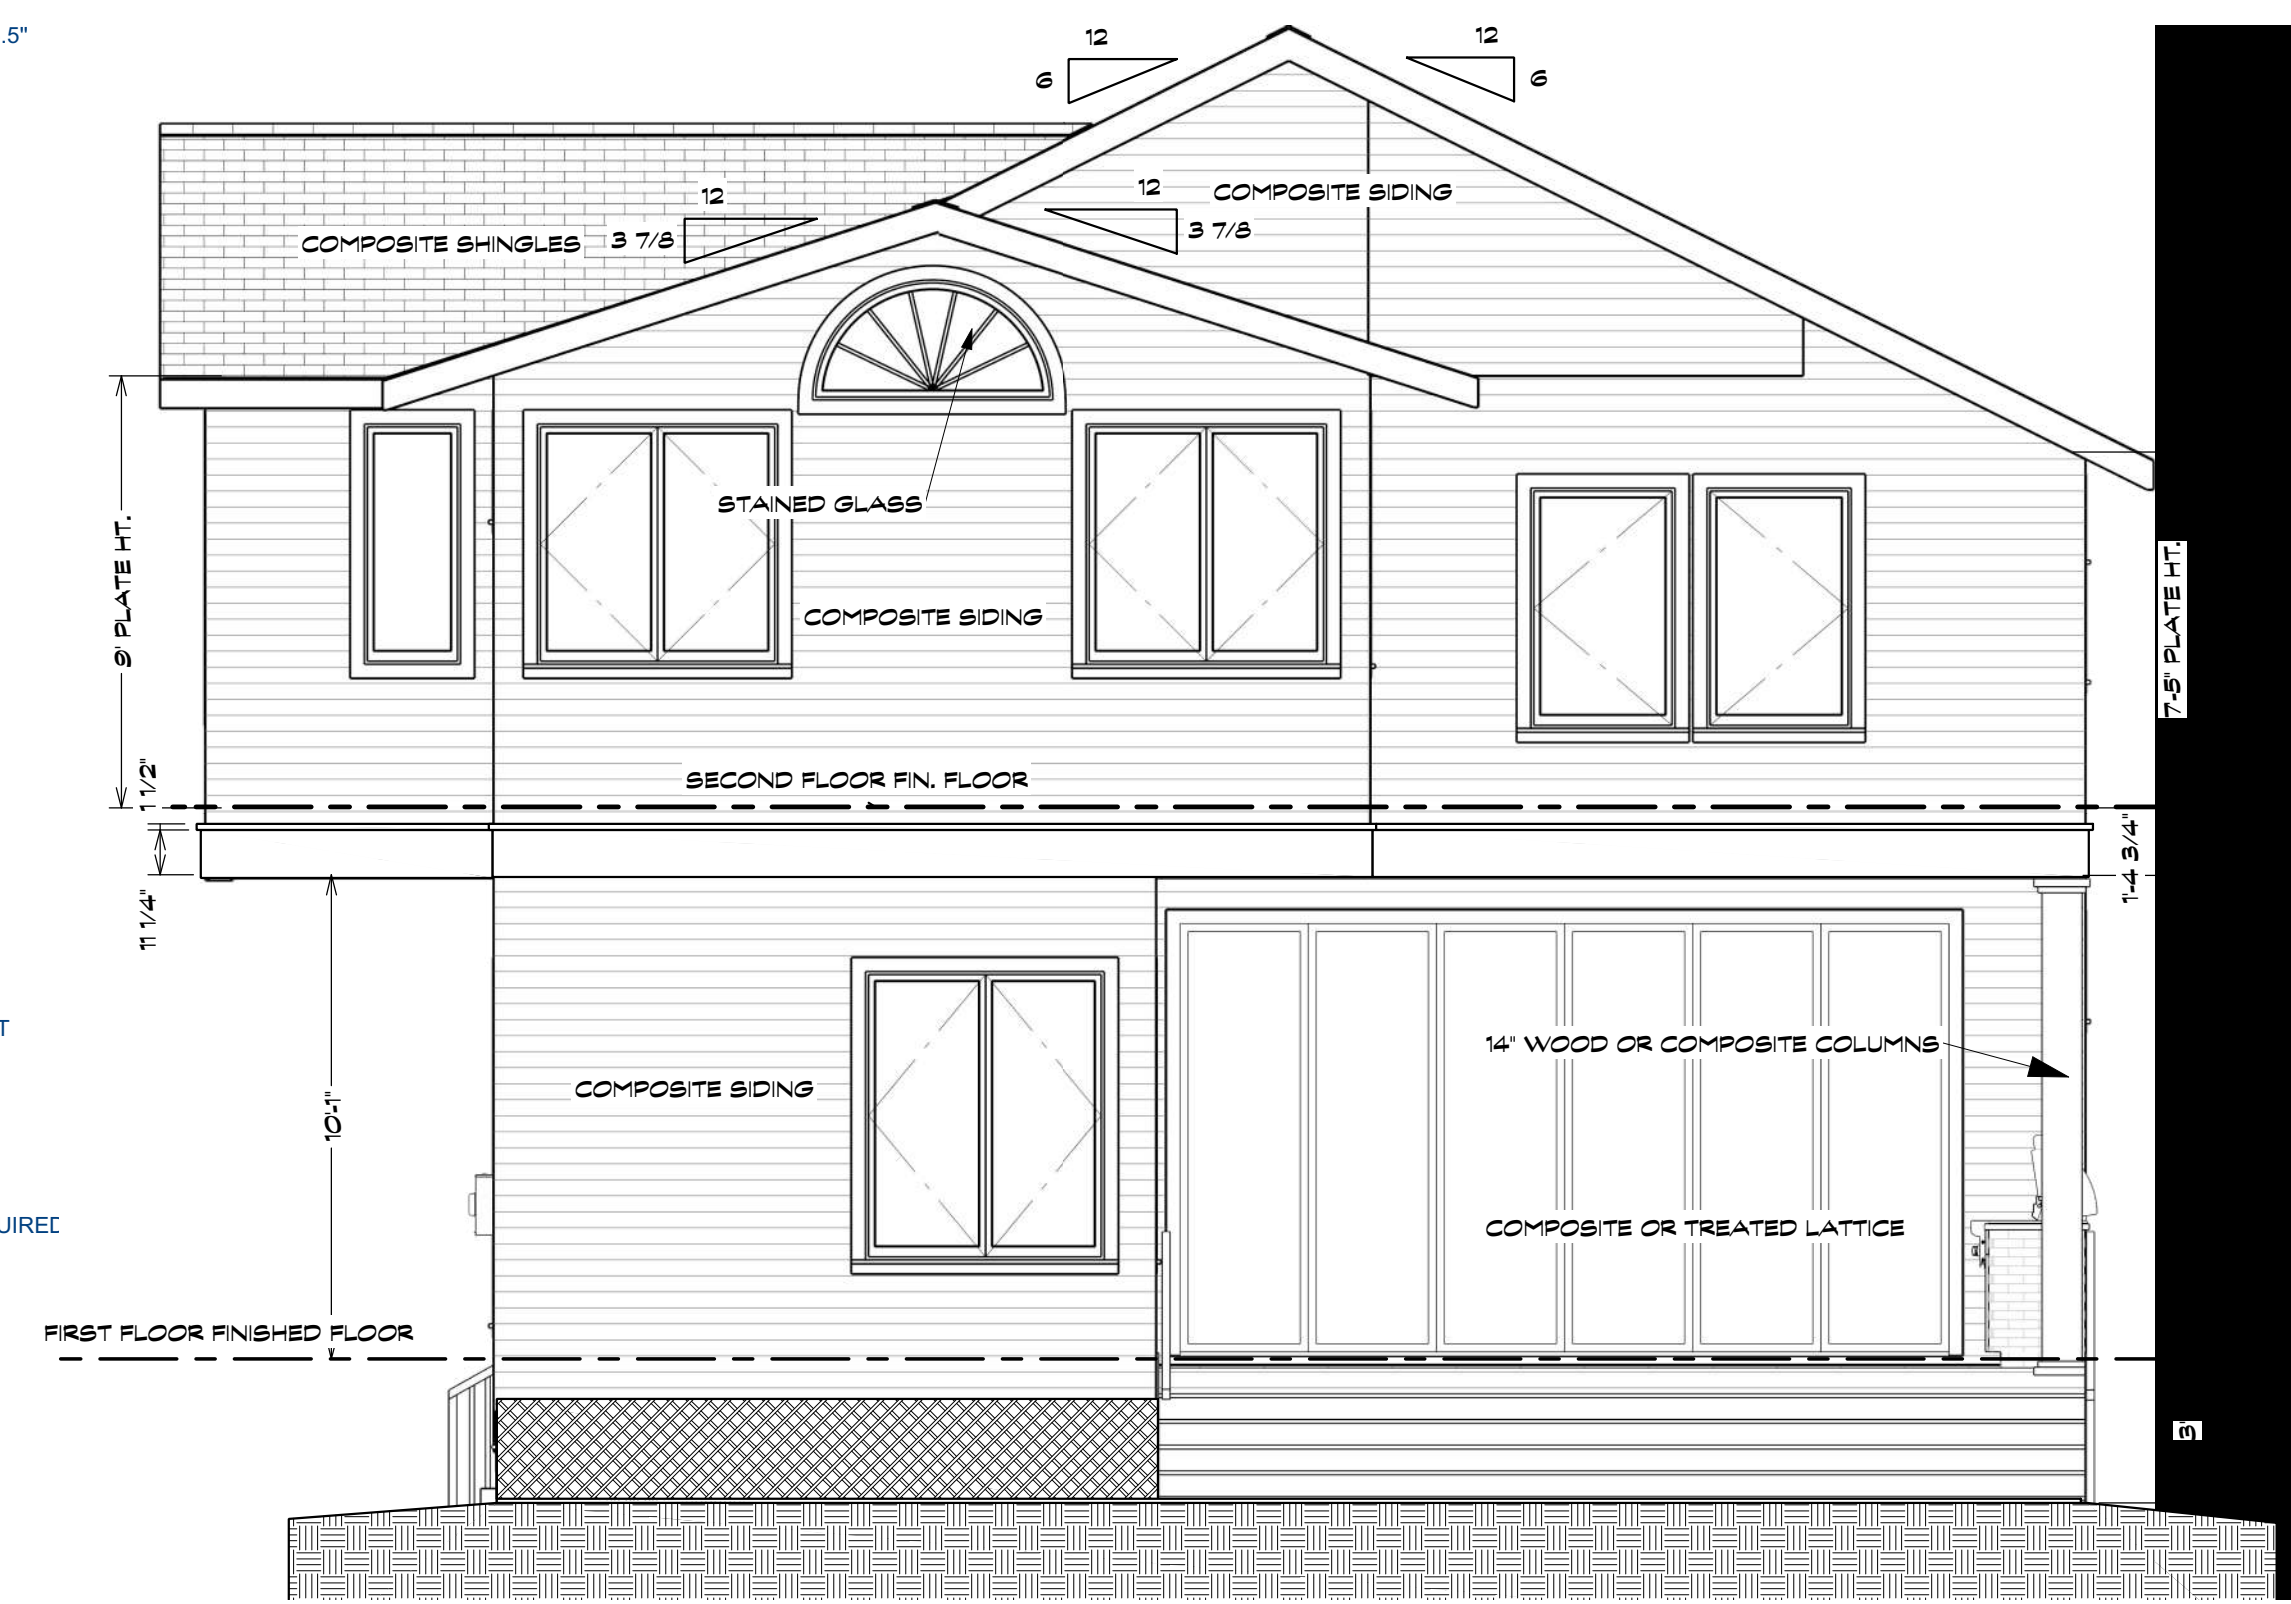

Rear Elevation

REVISION TABLE	REVISION BY	DESCRIPTION
NUMBER DATE	REVISED BY	CITY REV.
8-18-2021		



ENTISION
Design/Build
Creating the Future... Today

500 Wilcrest Dr. Suite 120
Houston, Texas 77042
Office 713-789-5282
Cell 713-606-1998

DATE:
2/11/2022

SCALE:
1/4" = 1'-0"

SHEET:
A-5

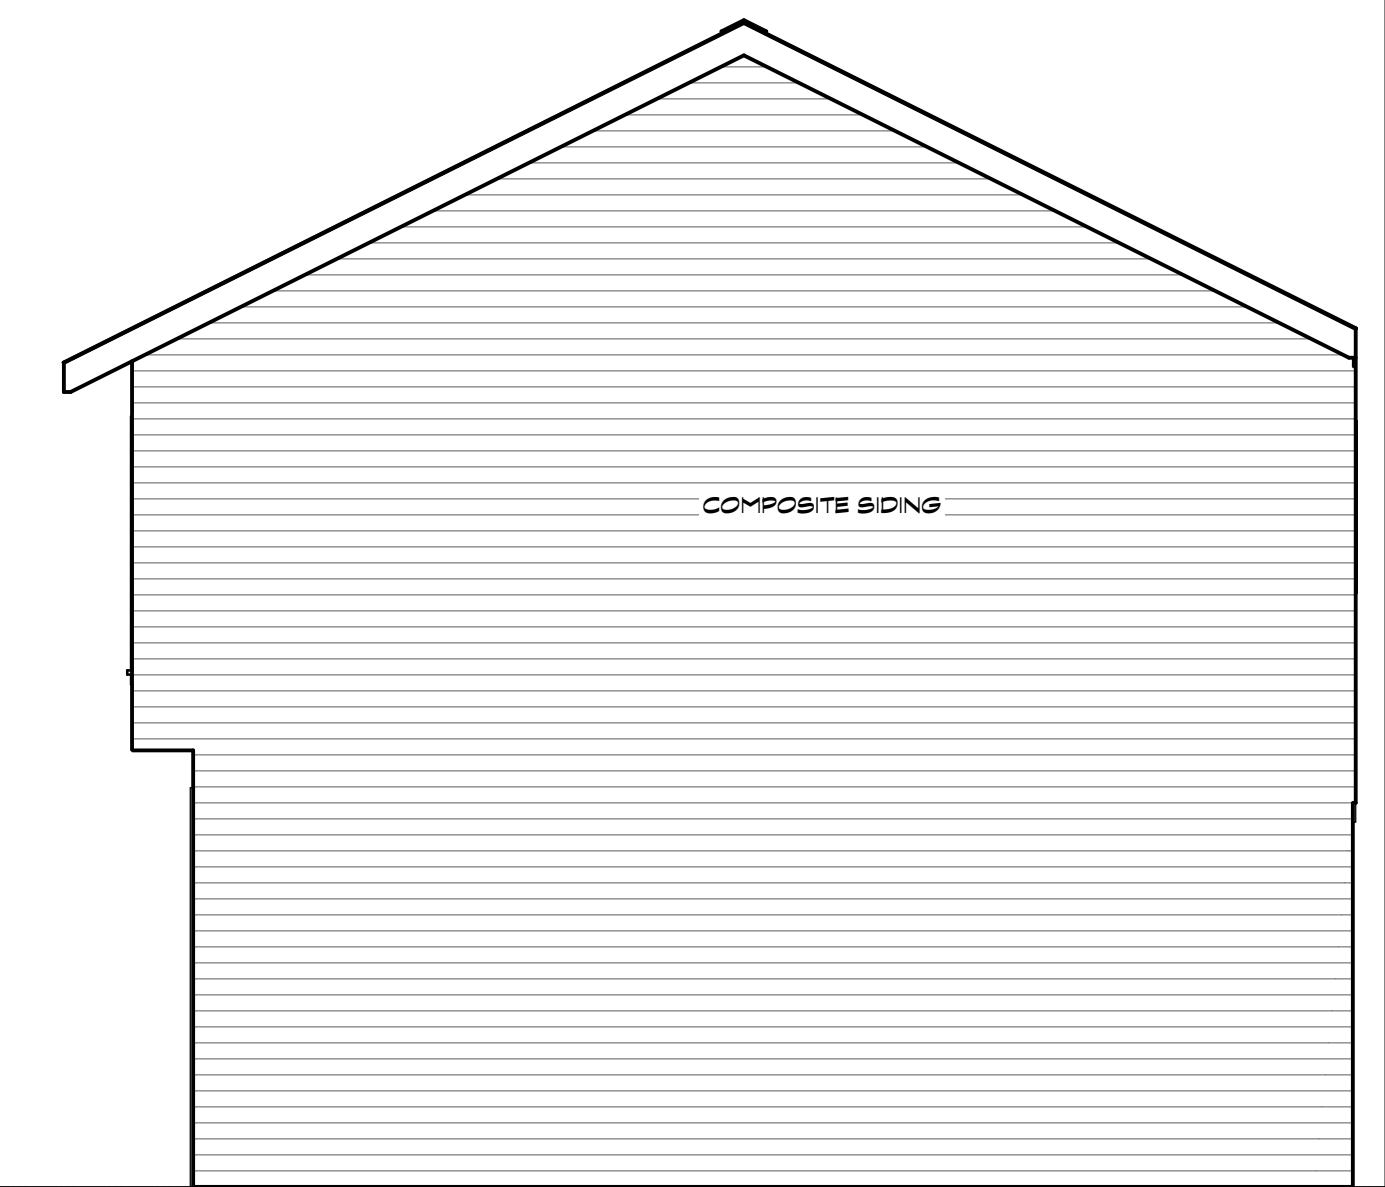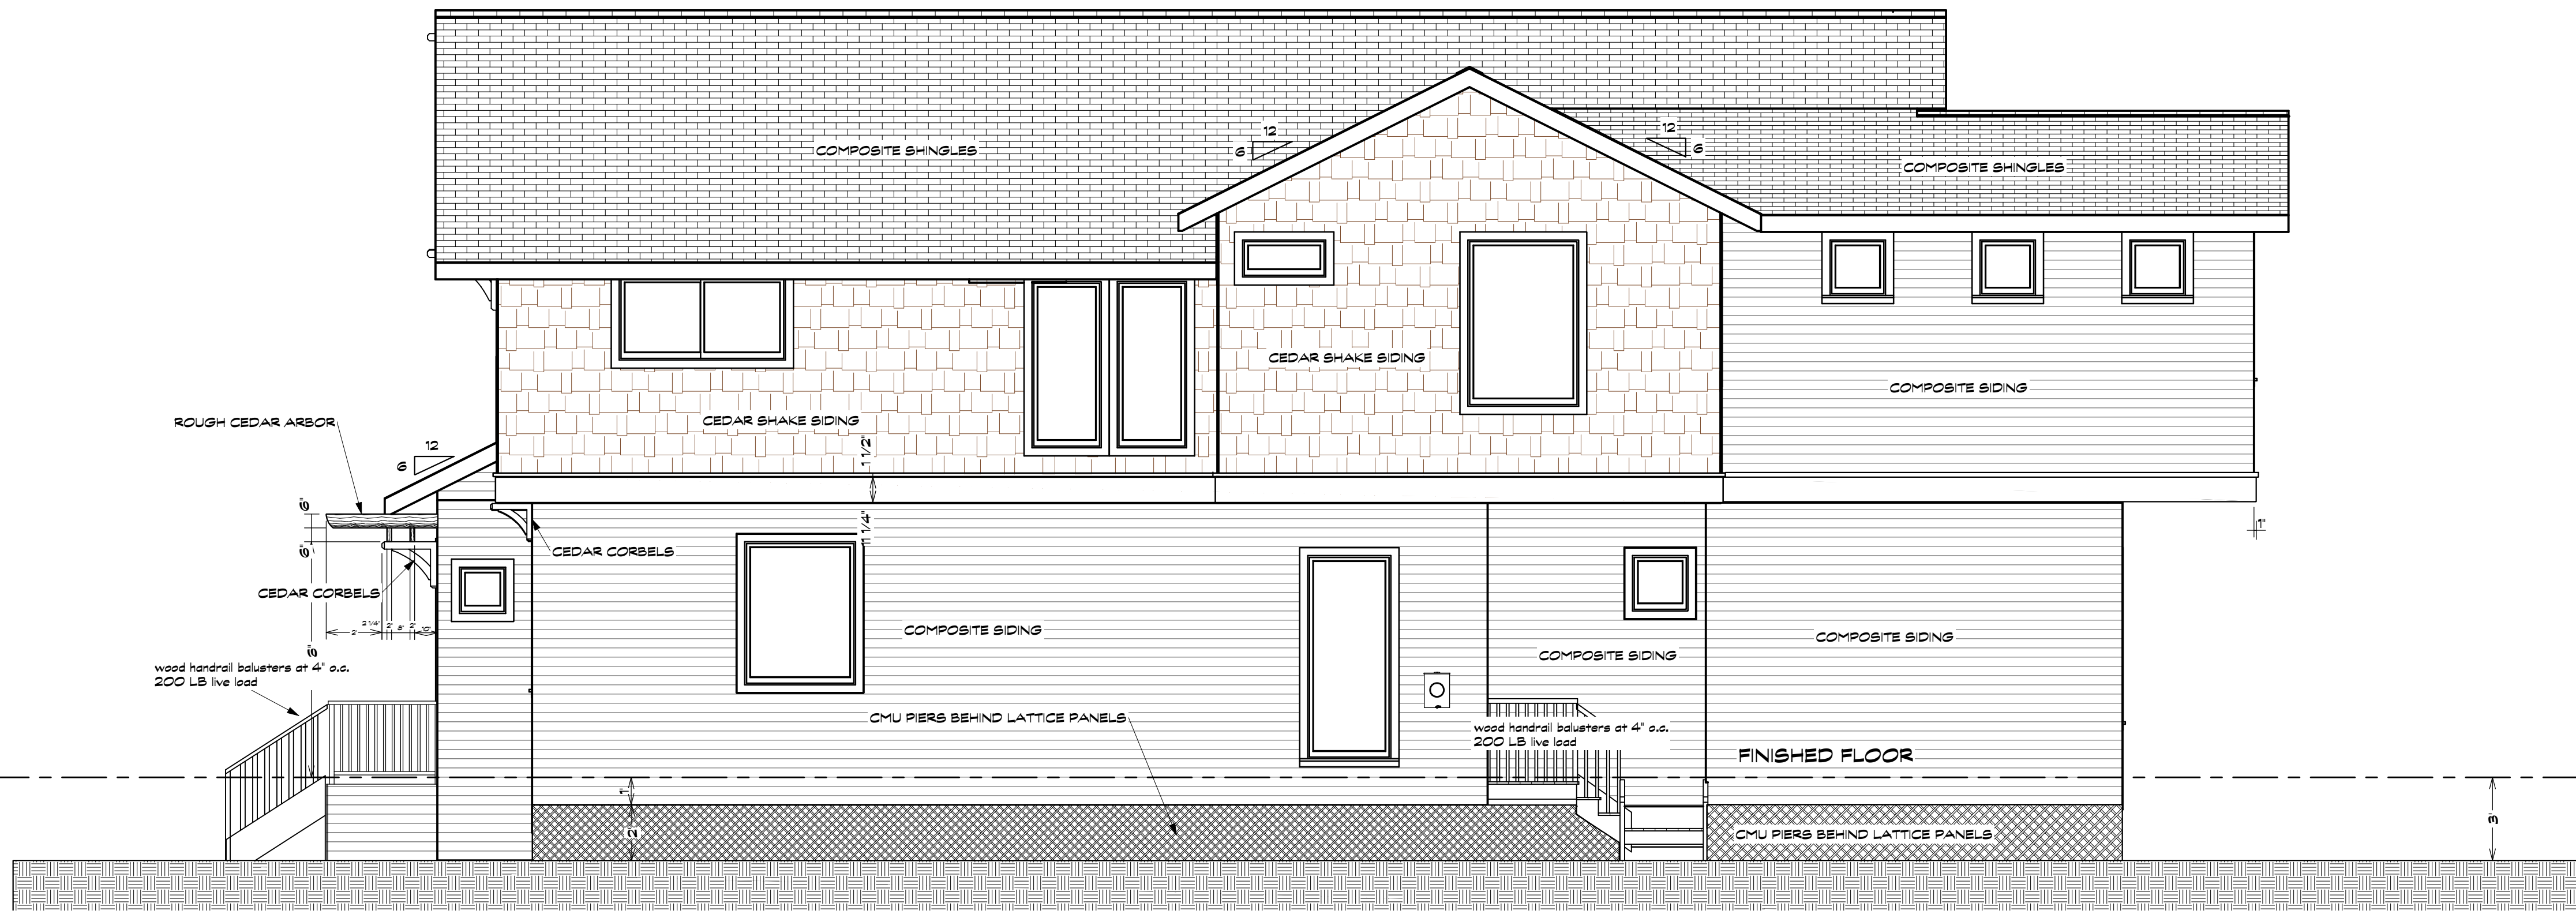


NUMBER	DATE	REVISION TABLE	DESCRIPTION	CITY REV.
1	8-18-2021			


Elevation 2




E 8

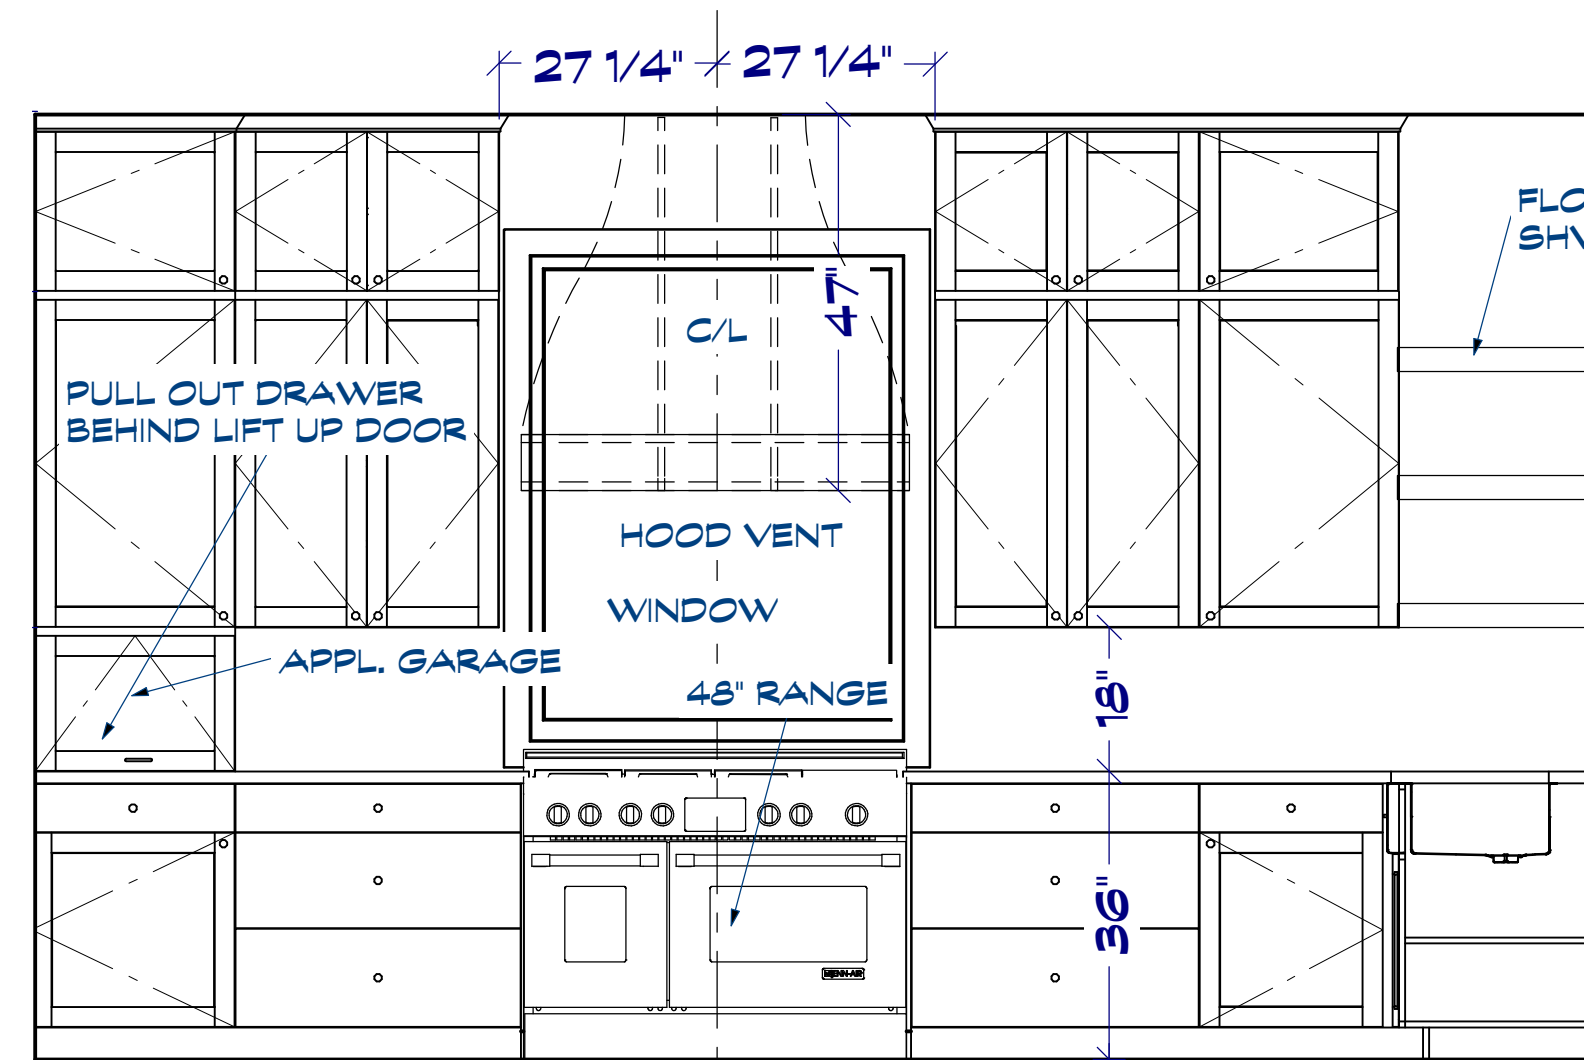

E 24

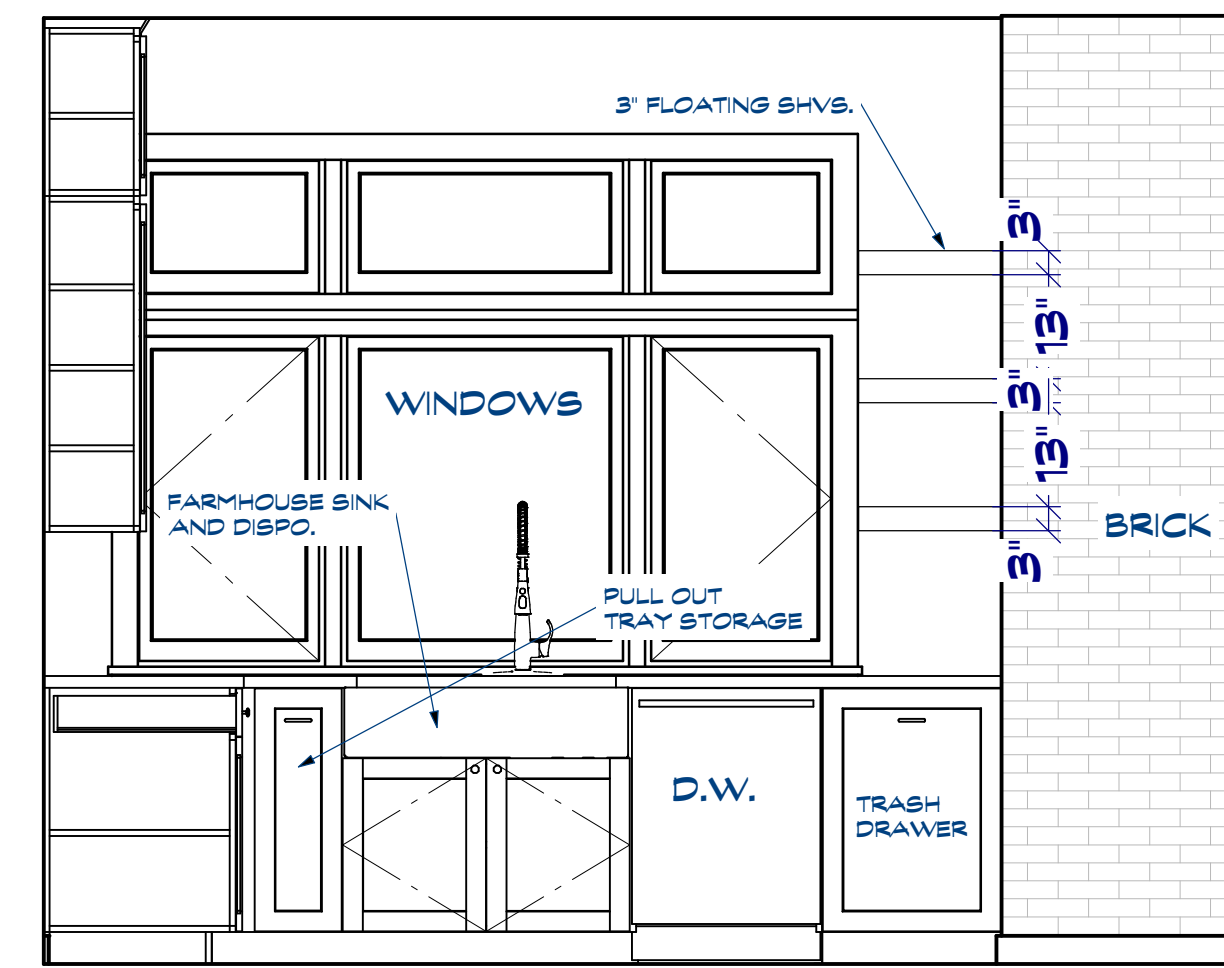


E 25

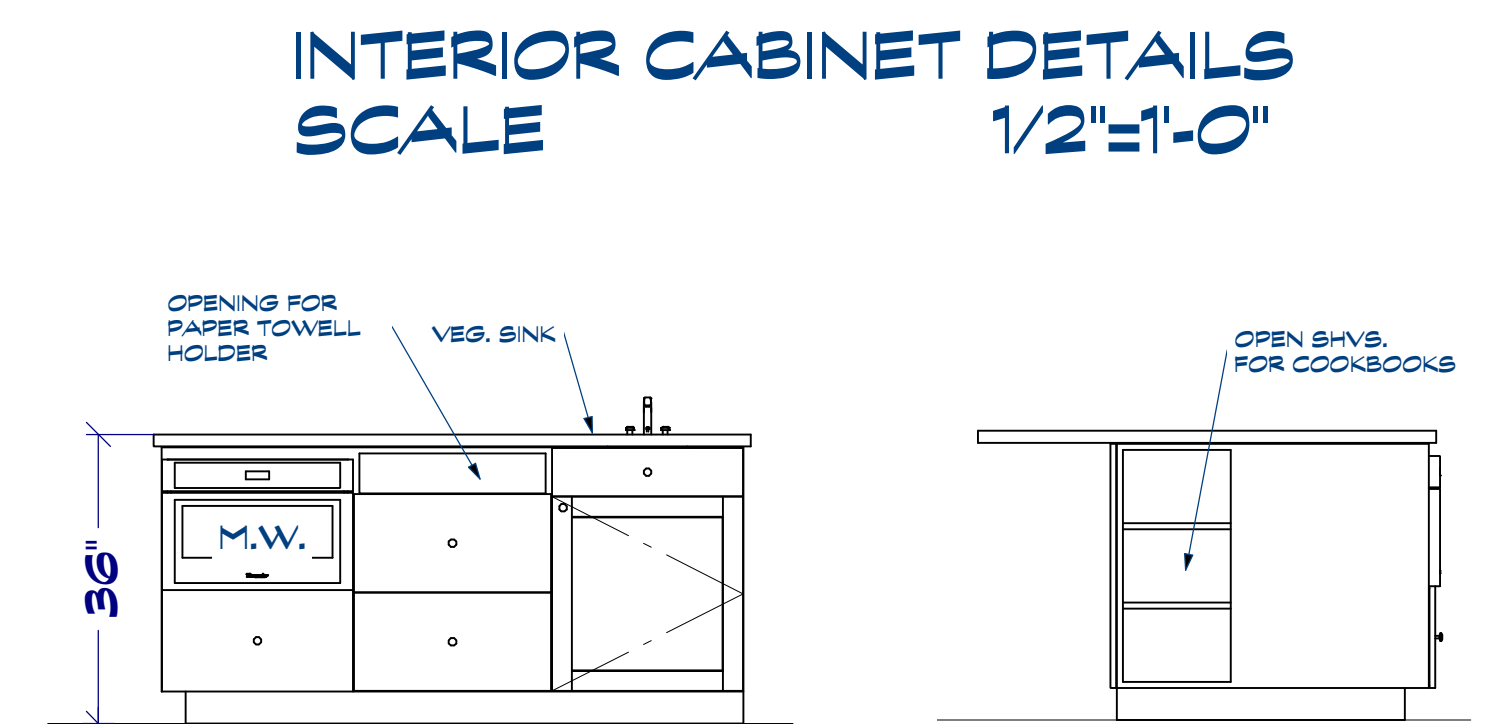


INTERIOR CABINET DETAILS
SCALE 1/2"=1'-0"

E 11


E 27
BOTH SIDES

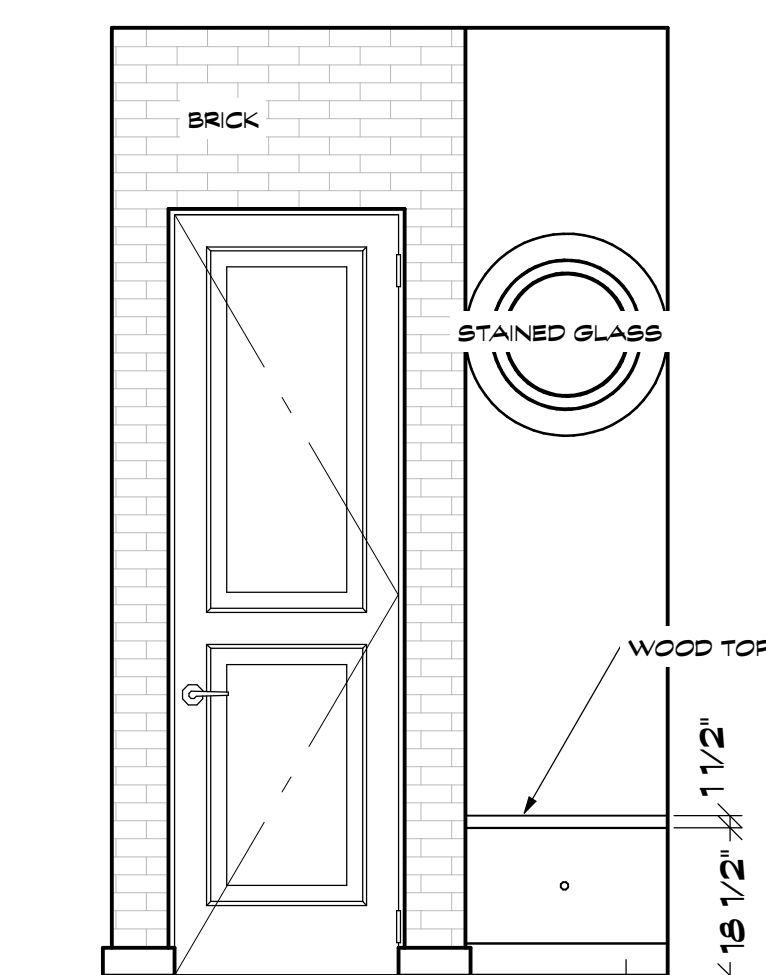


E 5

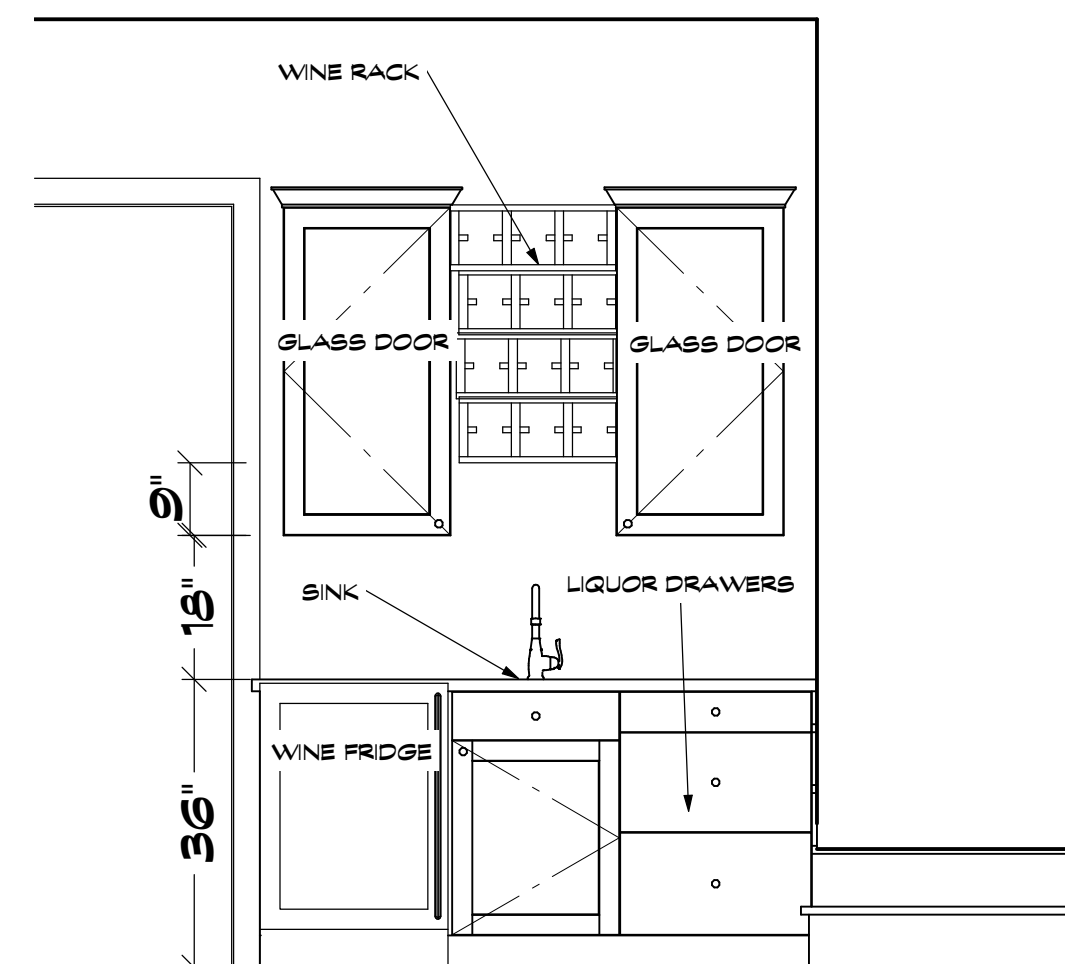

E 9

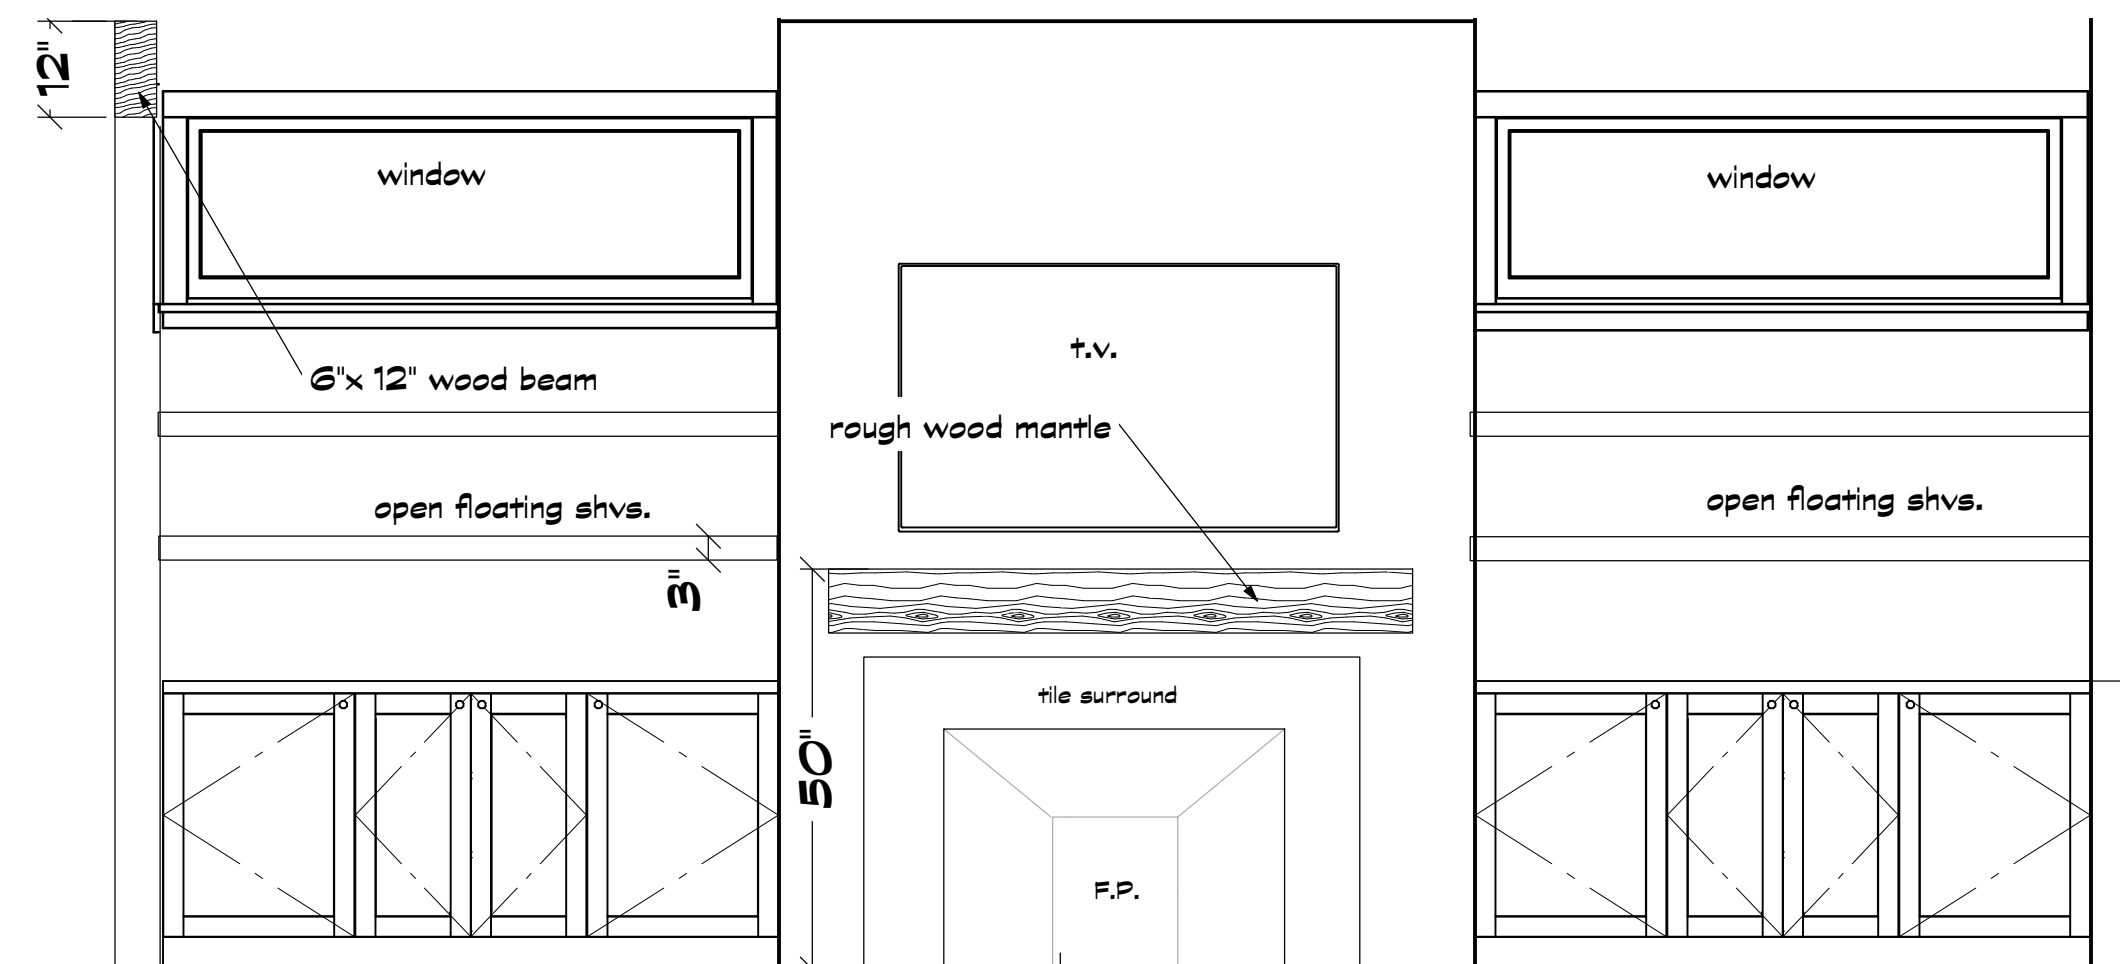


E 10

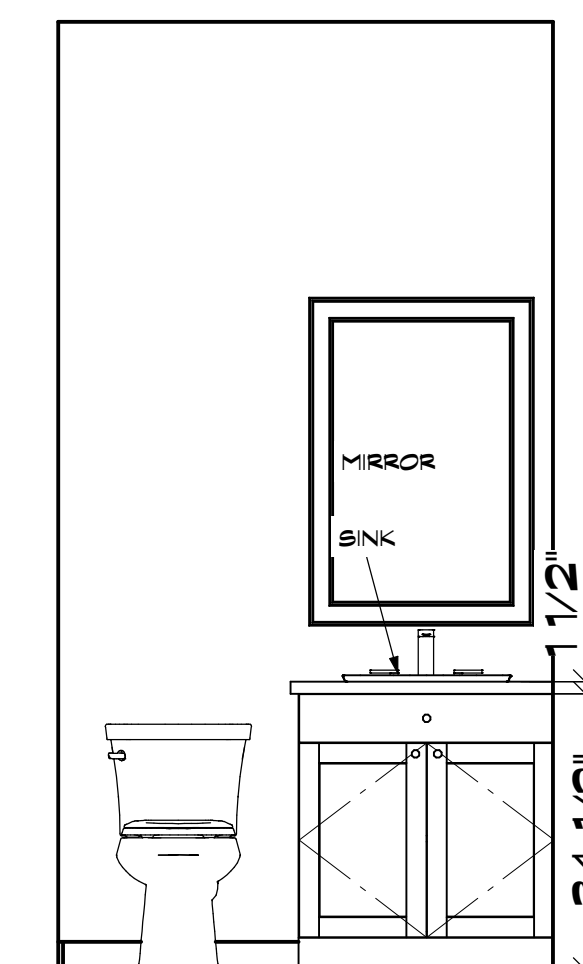

E 26

500 Wilcrest Dr. suite 120
Houston, Texas 77042
Office 713-789-5262
Cell 713-606-1996

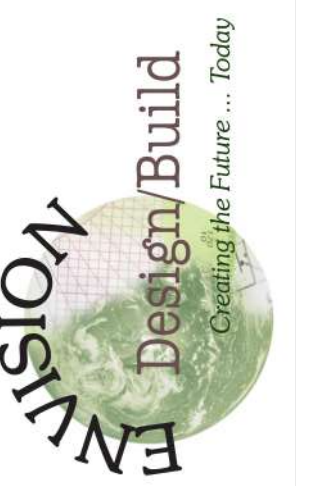

DATE:


2/11/2022

SCALE:


1/4" = 1'-0"

SHEET:


A-6

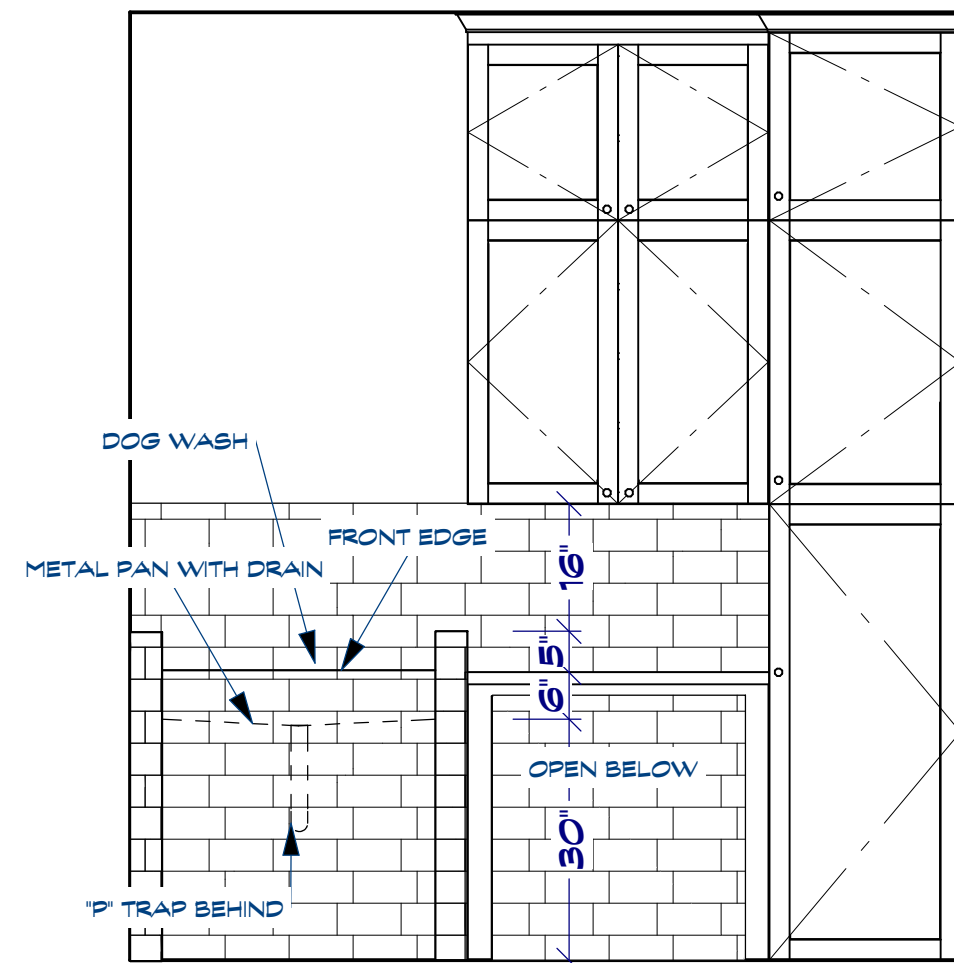


E 13

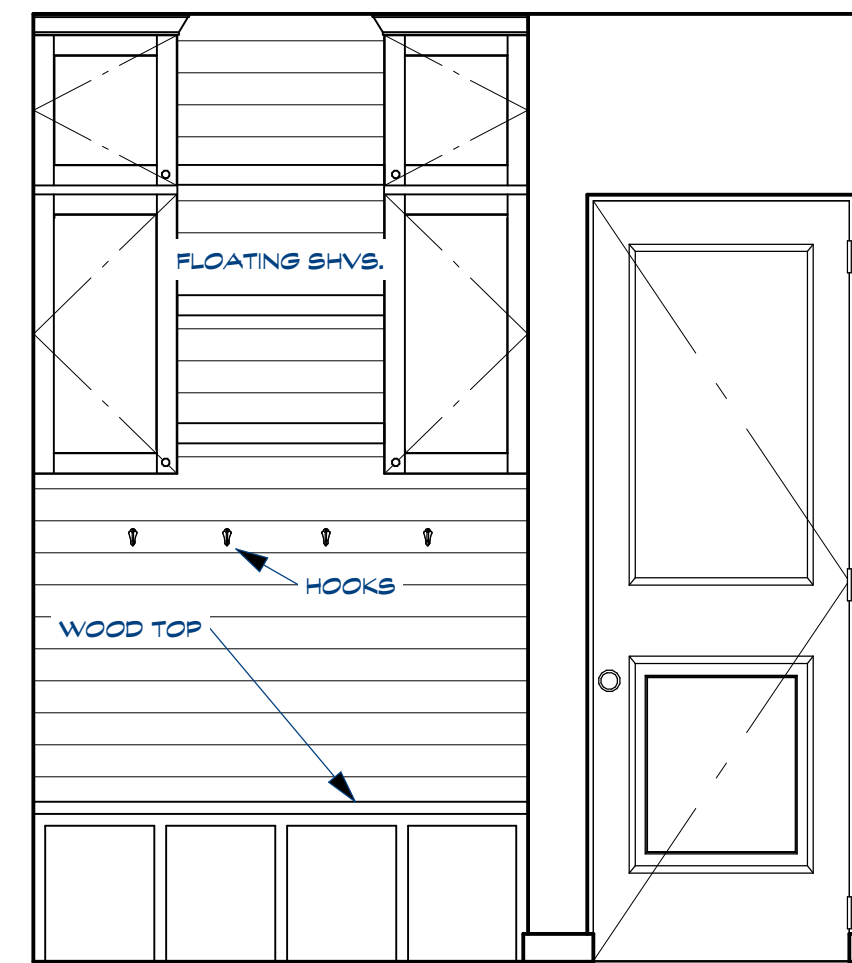


E 14

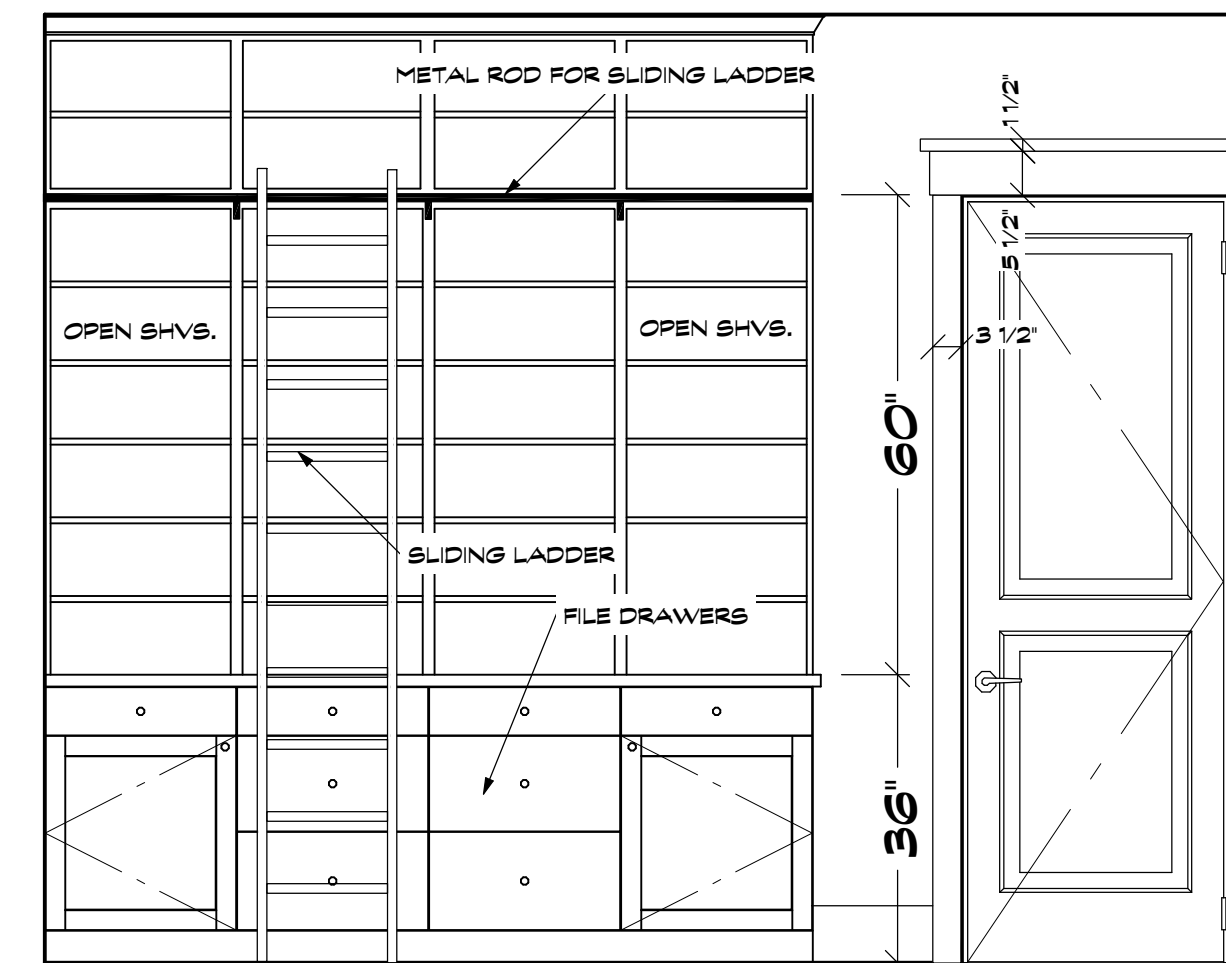


E 12

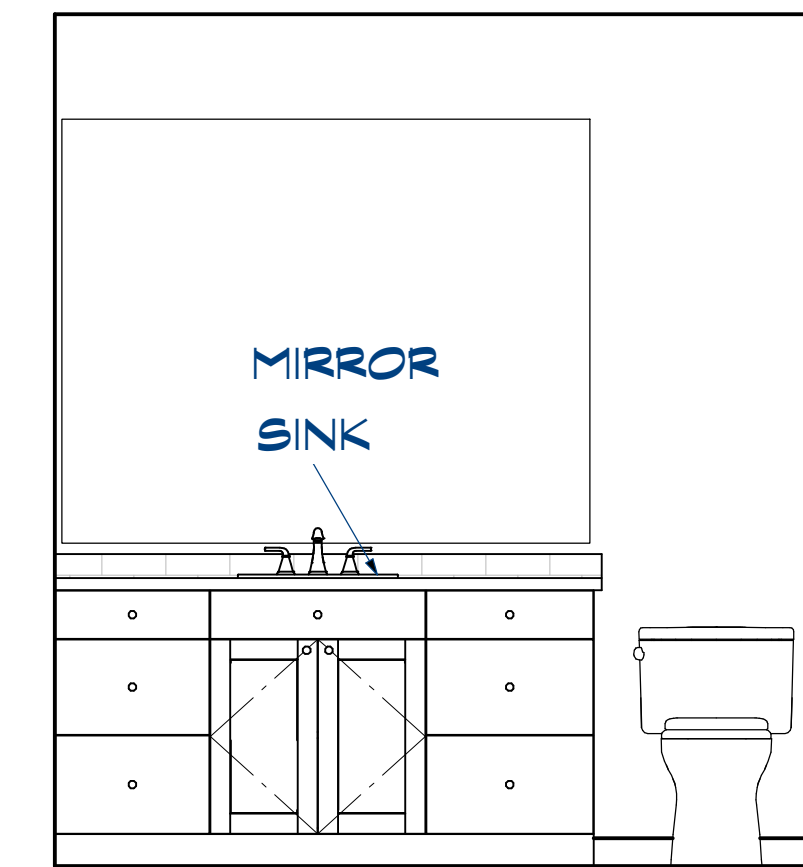


E 17

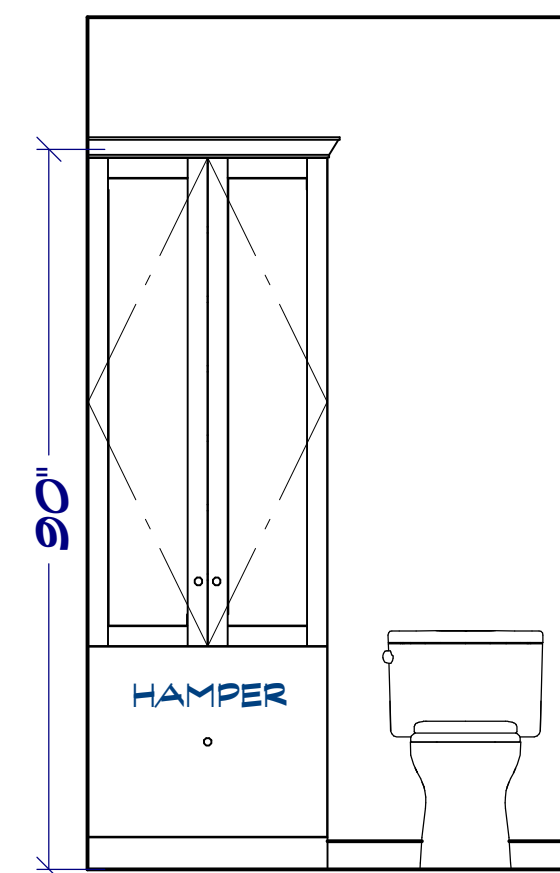


E 21

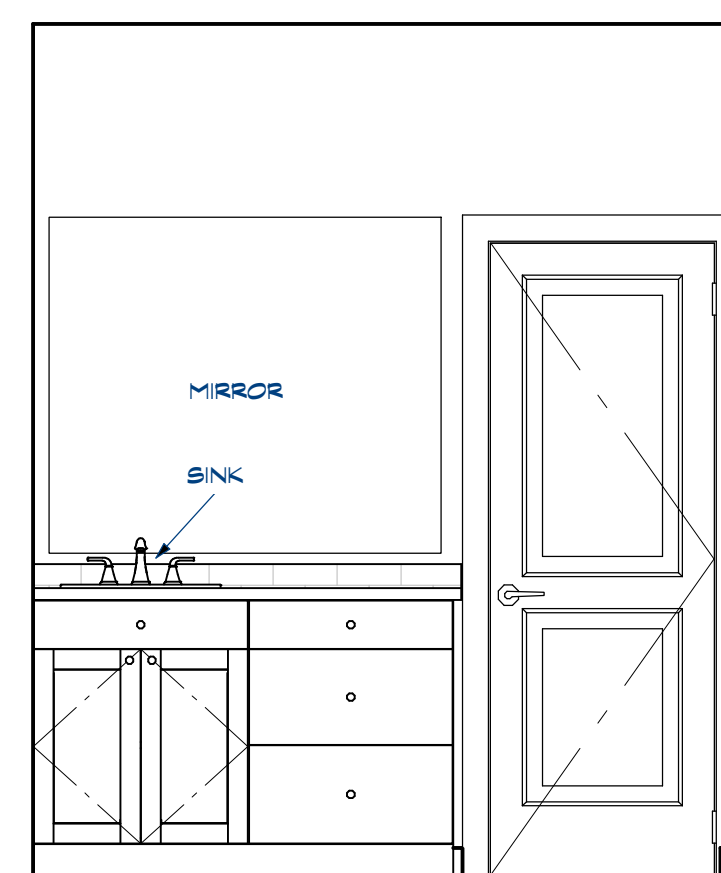


E 19

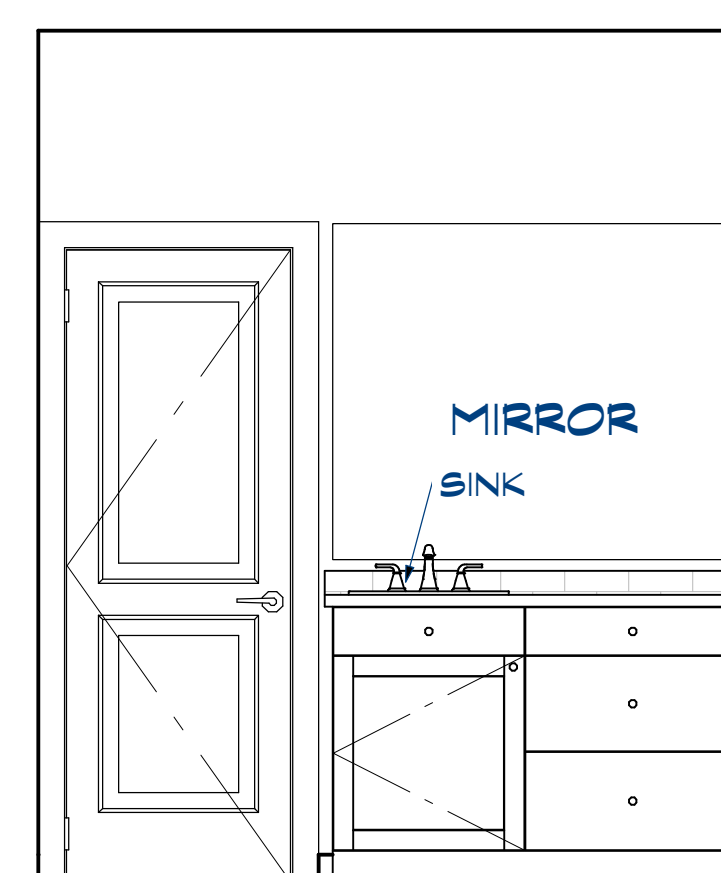


E 20

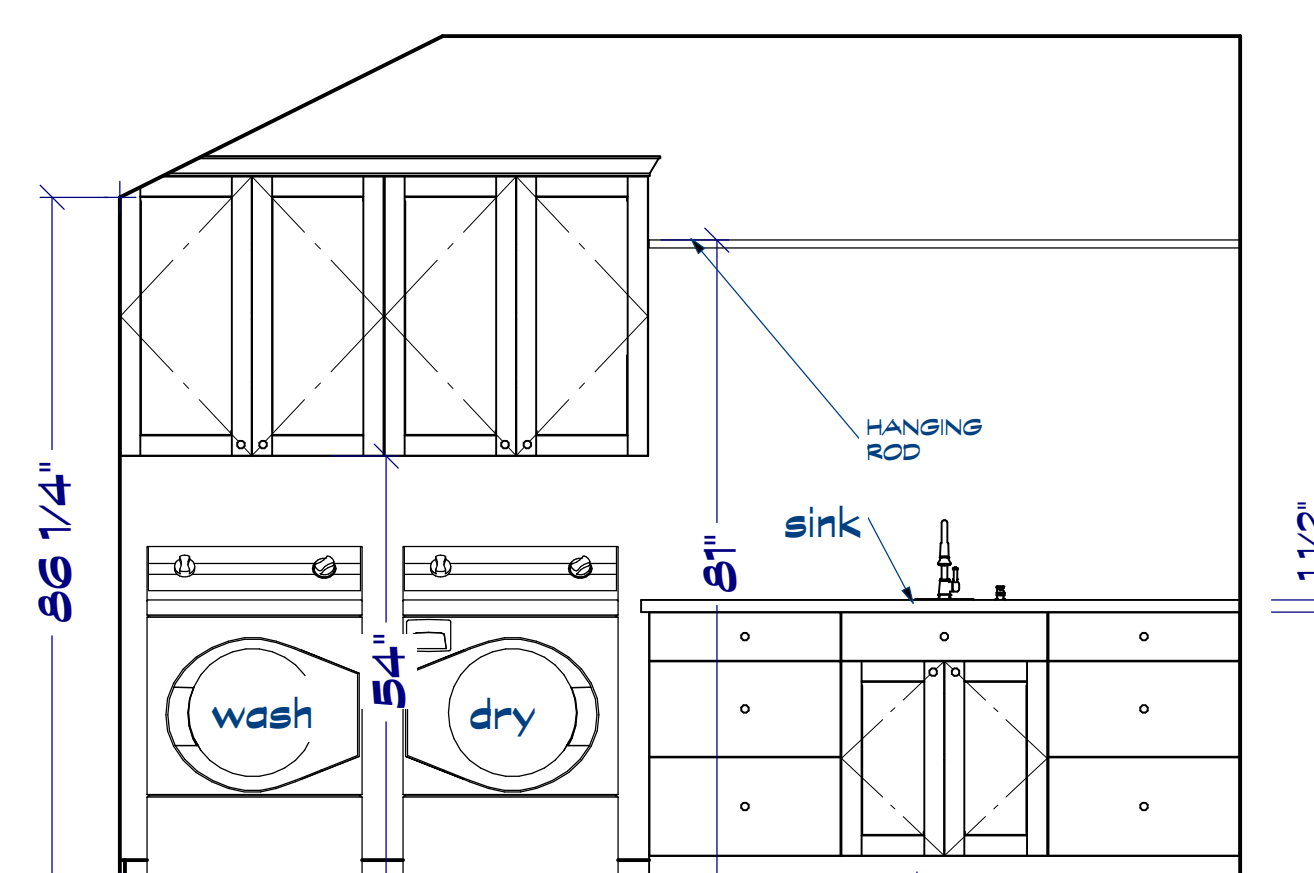


E 18

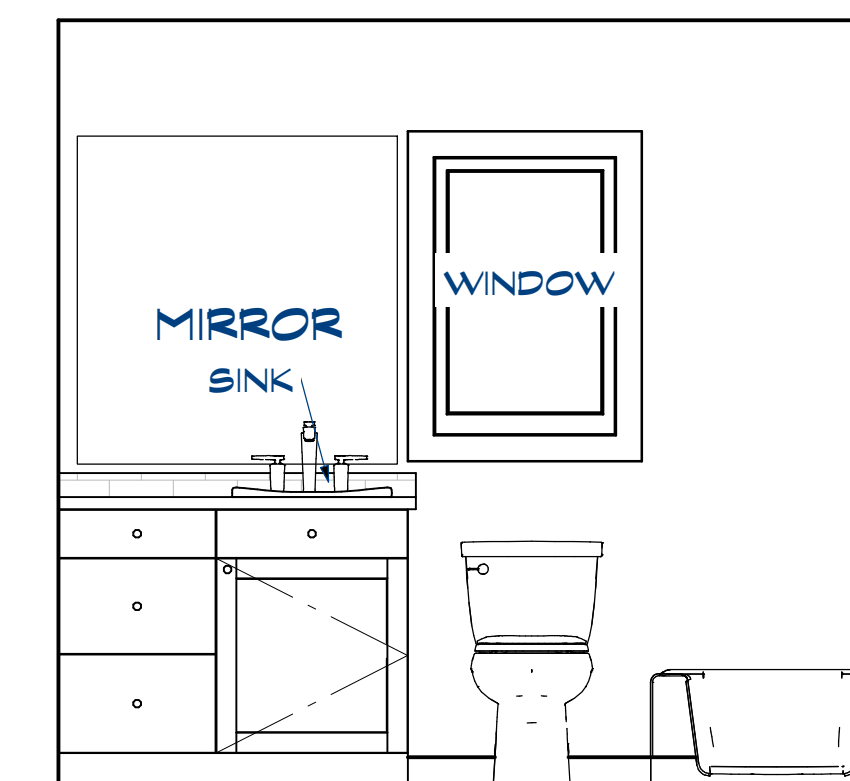


E 23

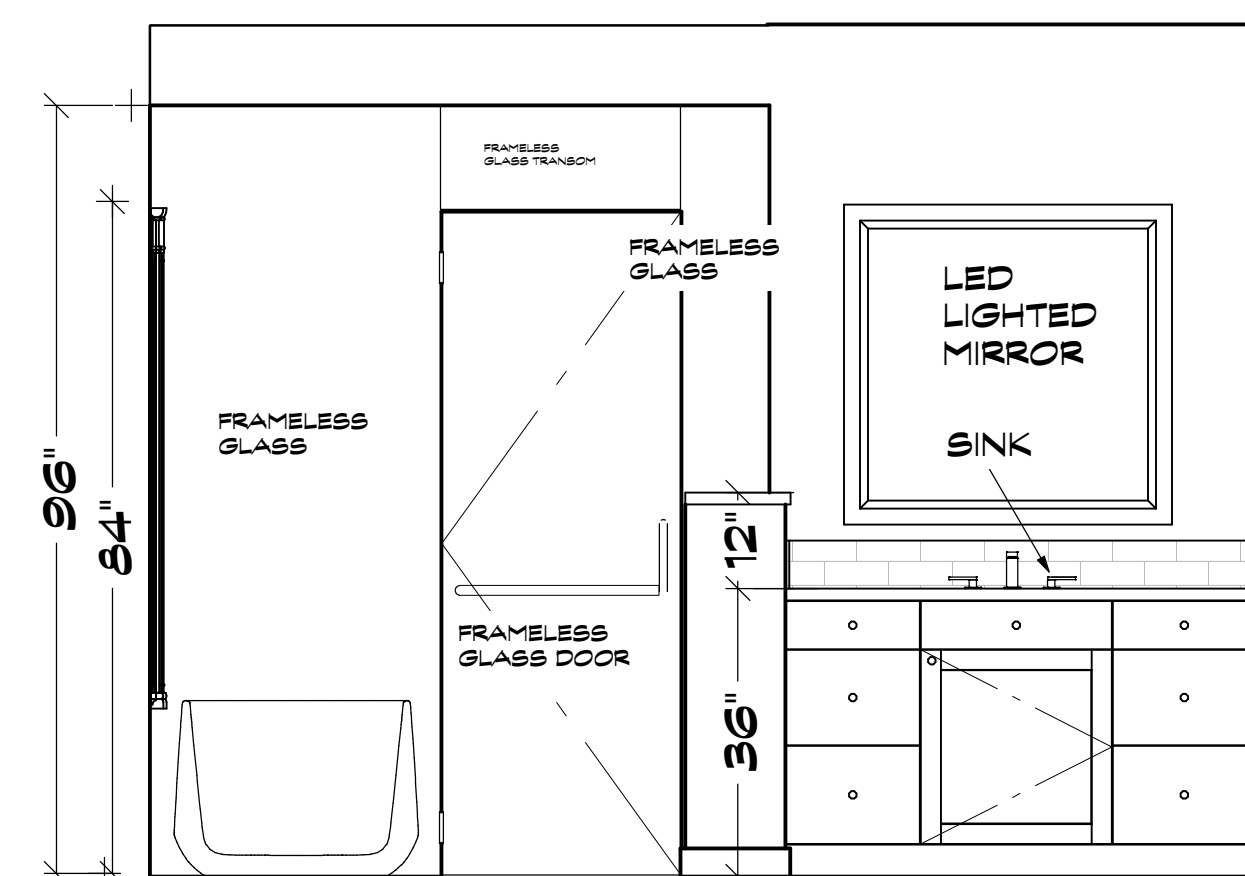

E 15

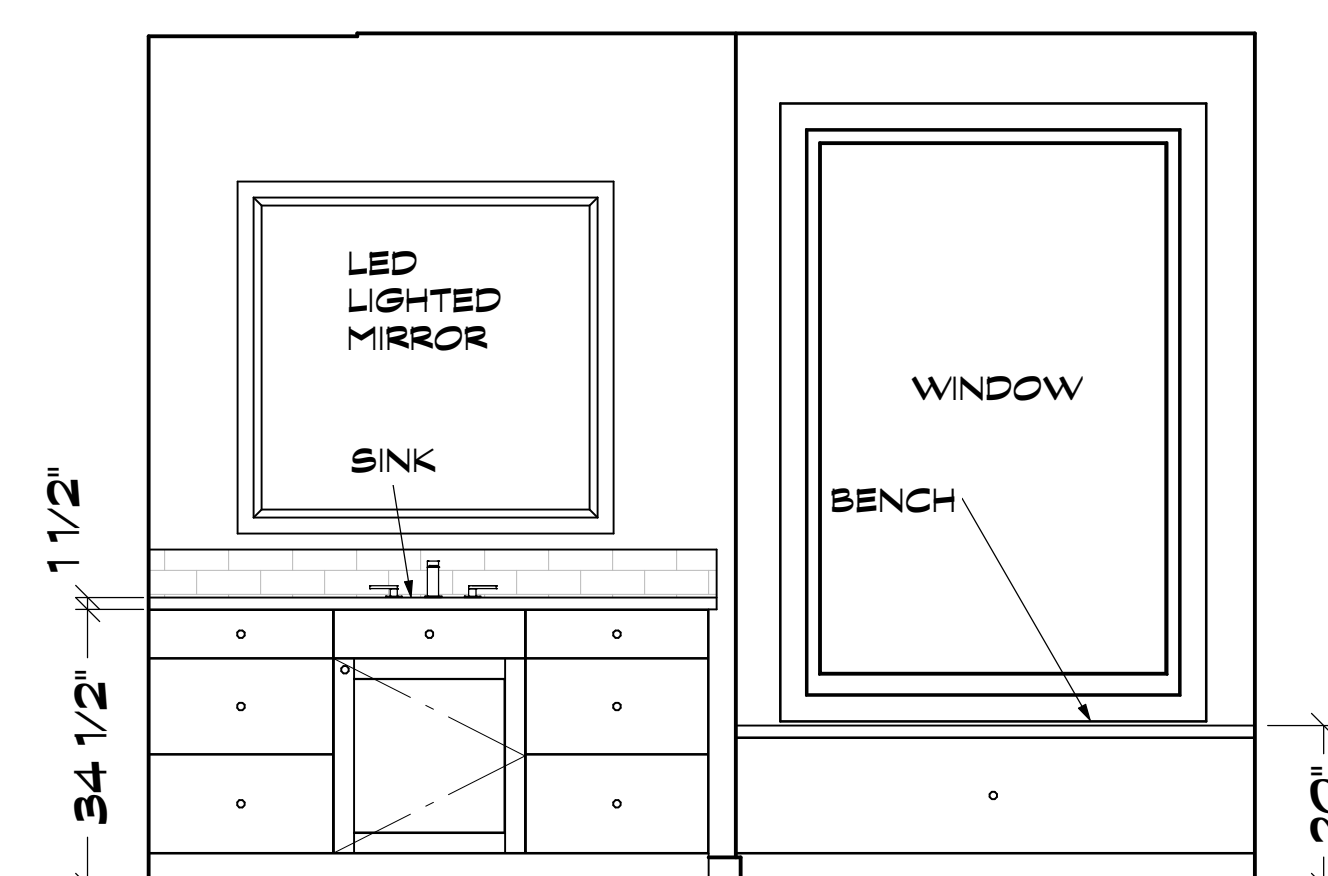

E 16

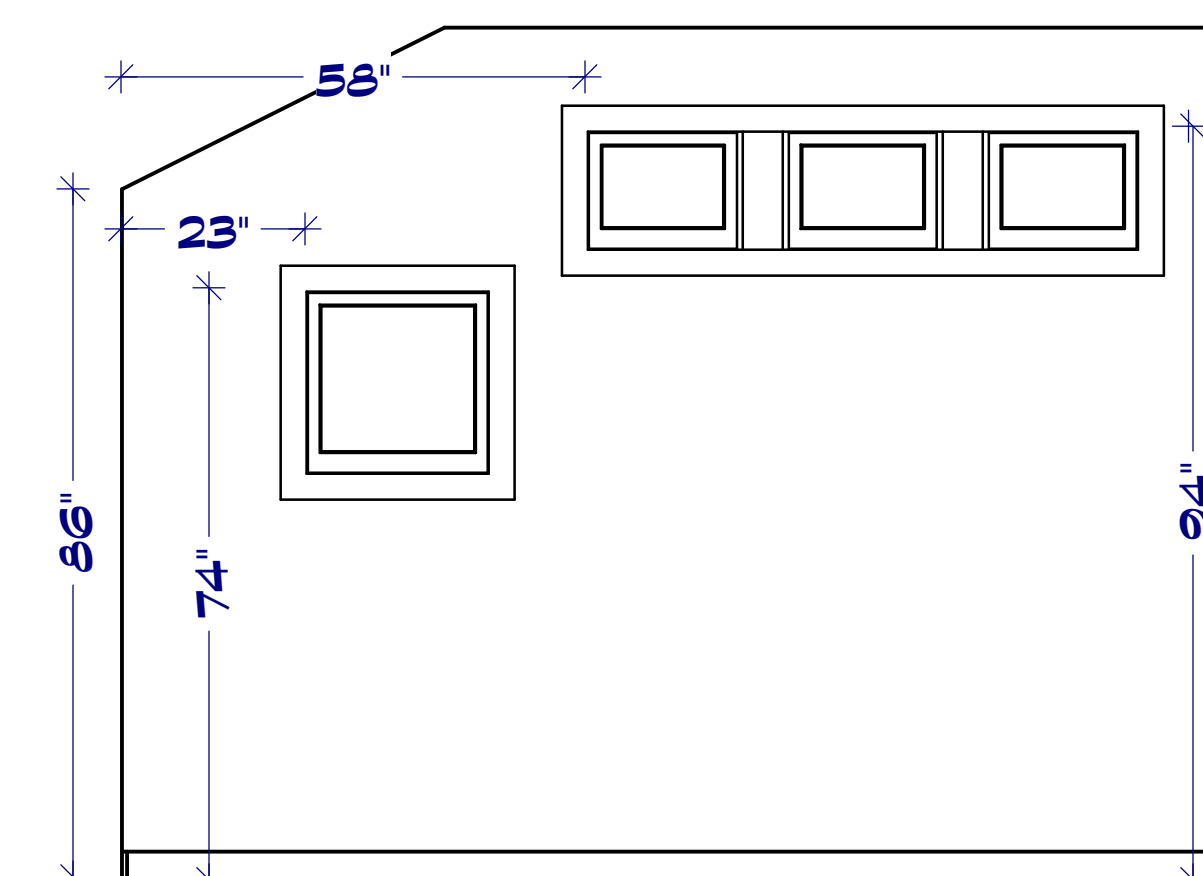

E 22

INTERIOR CABINET DETAILS
SCALE 1/2"=1'-0"

NUMBER	DATE	REVISION TABLE	REVISOR	DESCRIPTION	CITY	REV.
8-18-2021						



ENTISION
Design/Build
Creating the Future... Today

300 Wilcrest Dr. suite 120
Houston, Texas 77042
Office 713-789-5262
Cell 713-606-1996

DATE:
2/11/2022

SCALE:
1/4" = 1'-0"

SHEET:
A-7

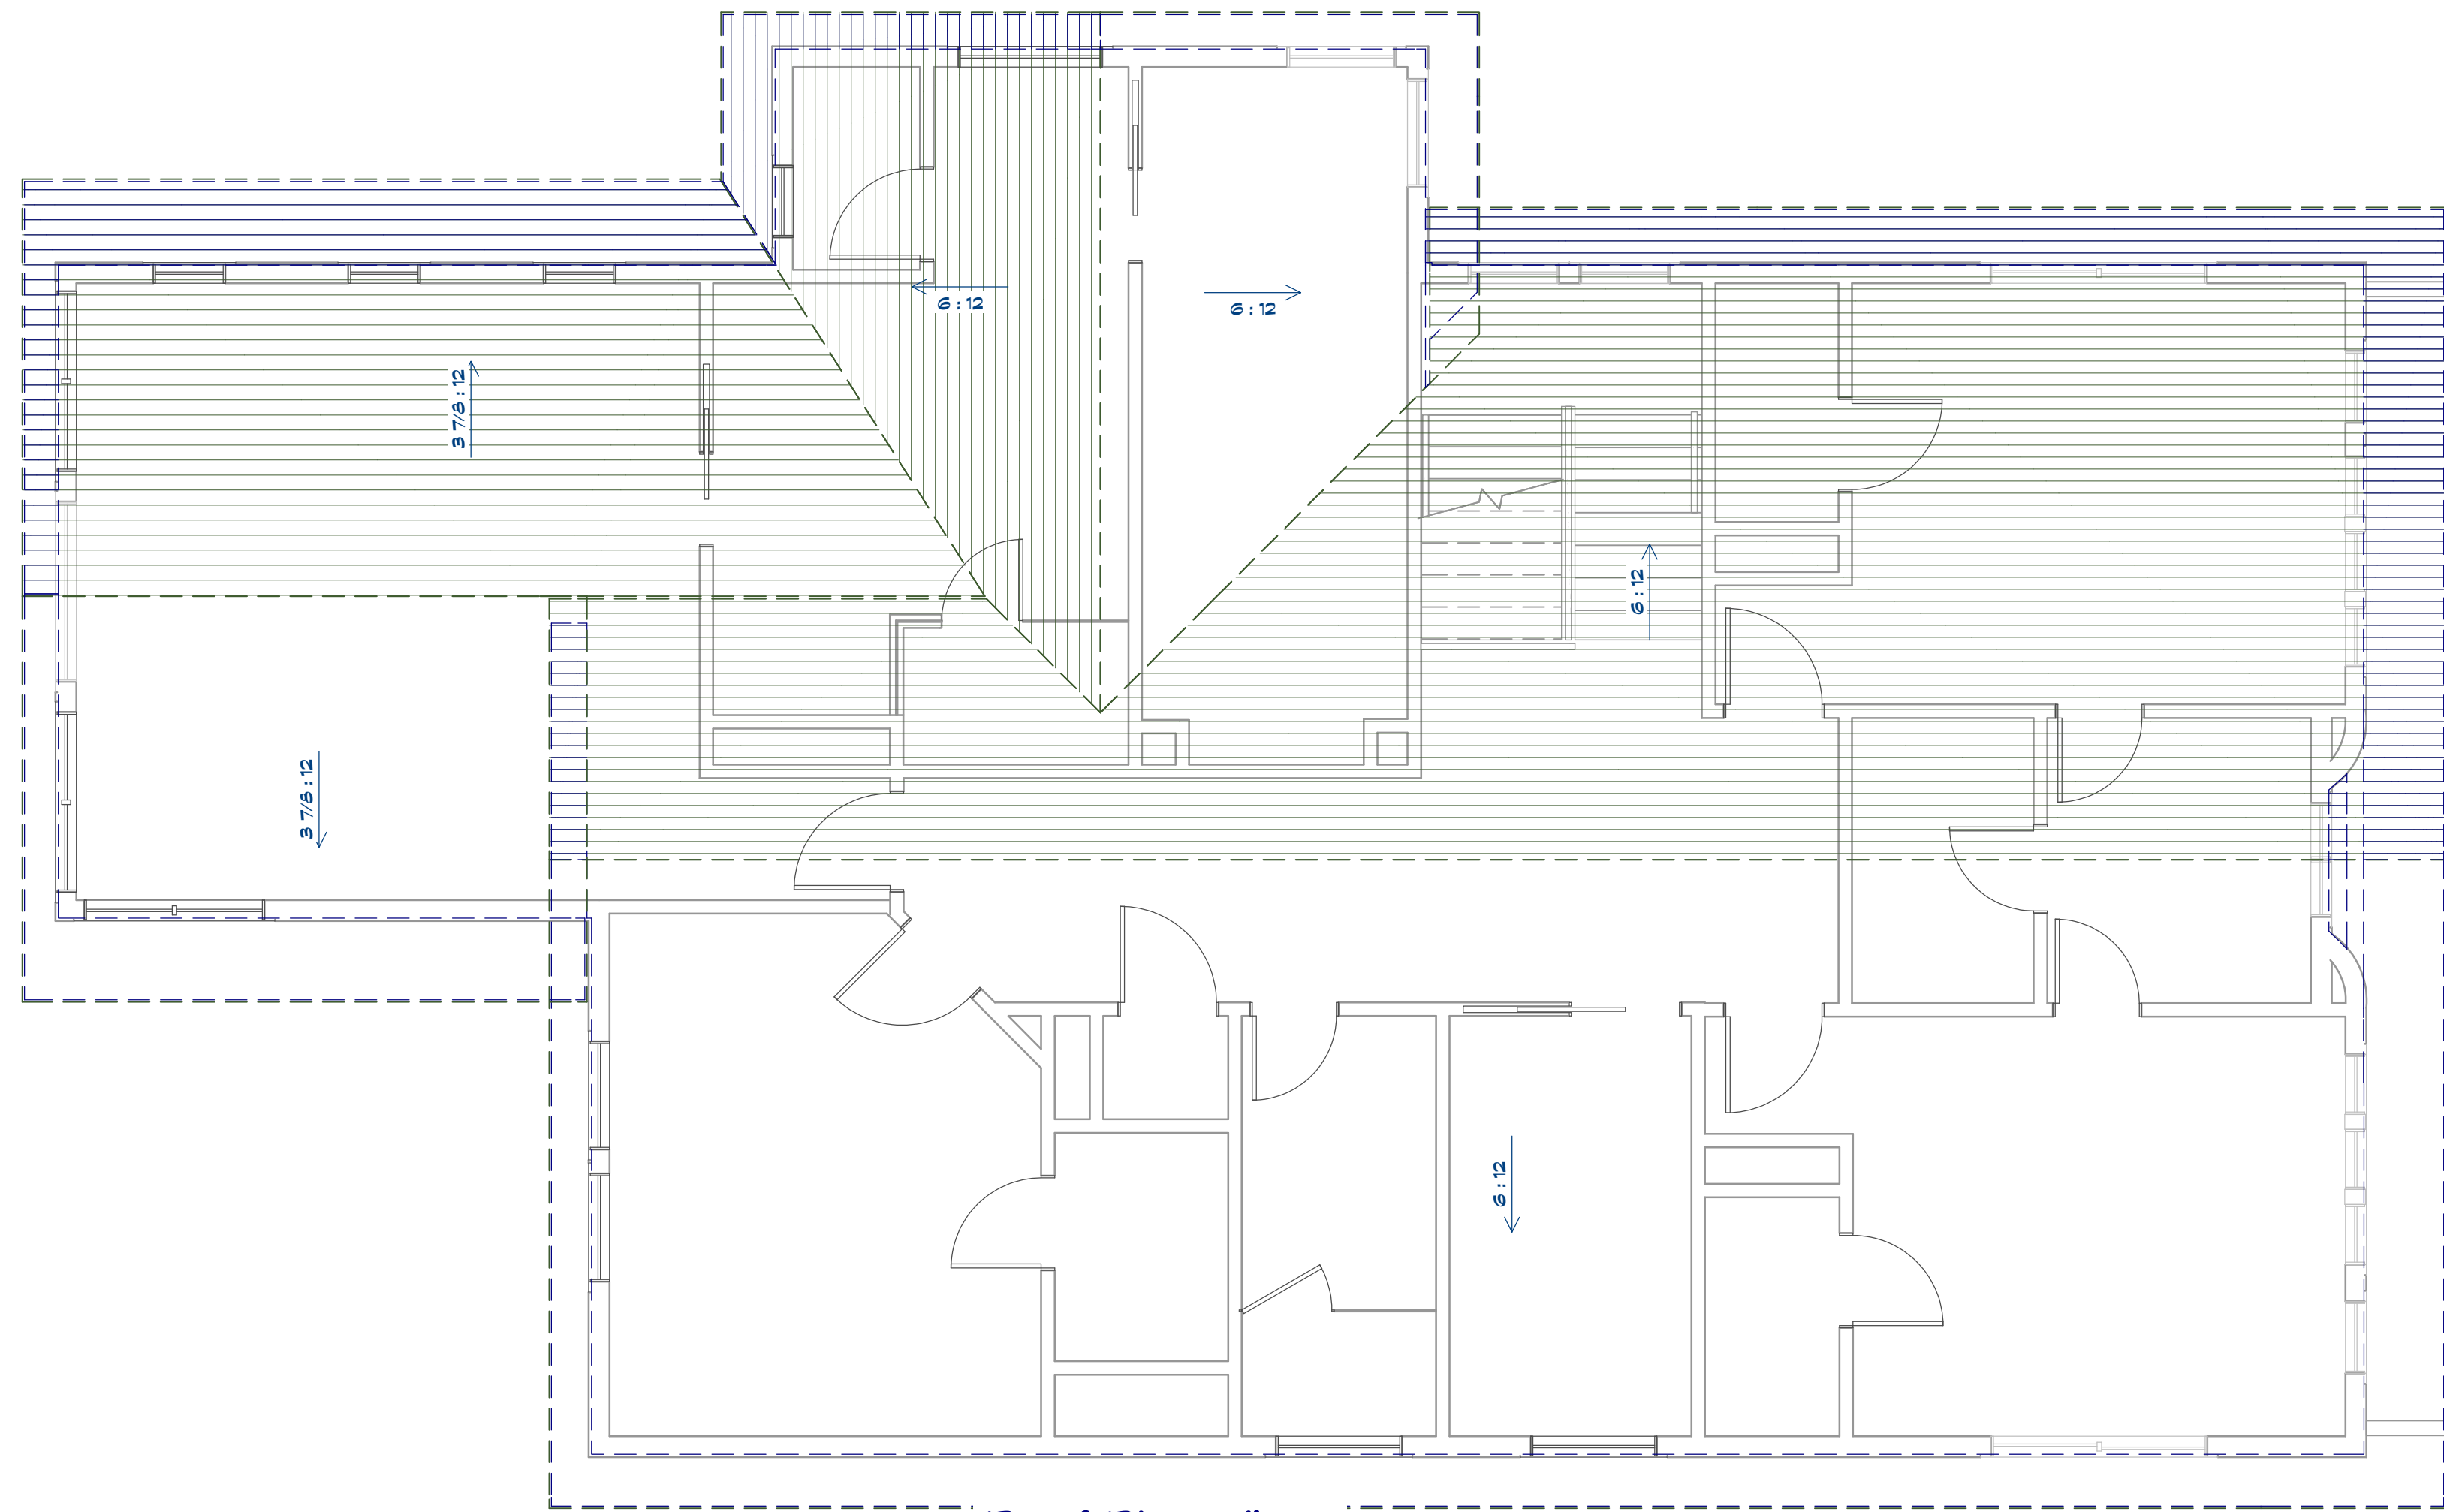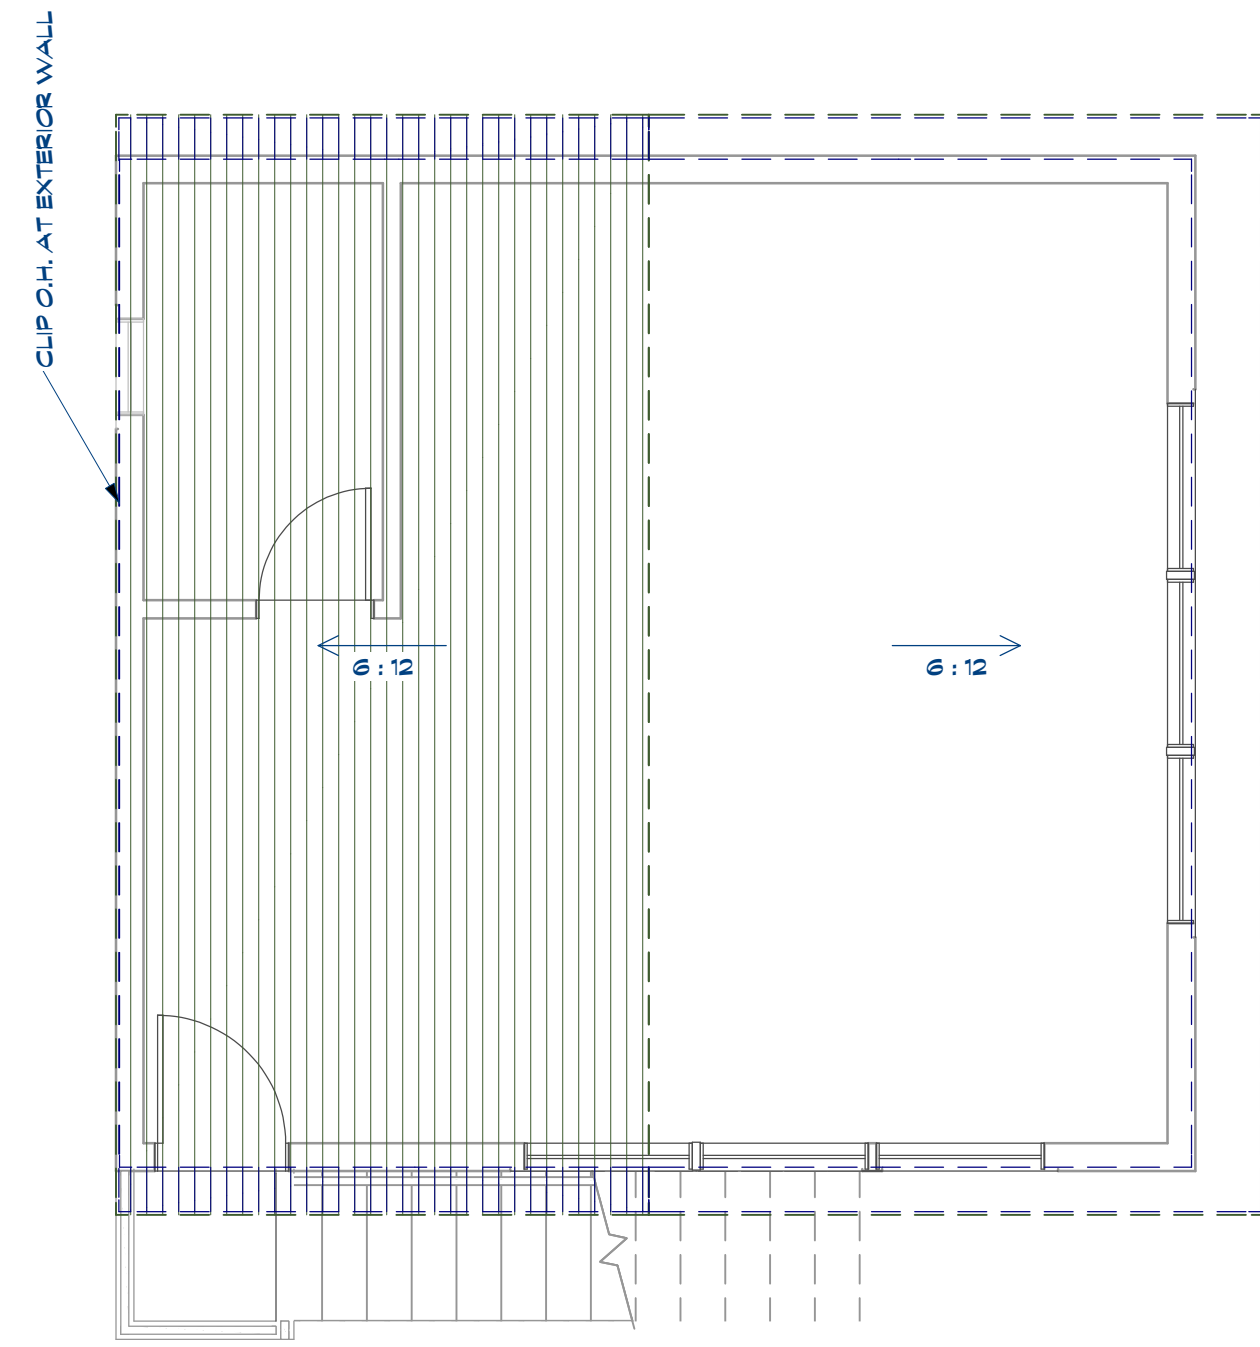

Roof Plan View
scale 1/4"=1'-0"

NUMBER	DATE	REVISION TABLE	REVISOR	DESCRIPTION	CITY	REV.
1	8-18-2021					



 800 Wilcrest Dr. Suite 120
 Houston, Texas 77042
 Office 713-789-5262
 Cell 713-606-1996

DATE:

2/11/2022

SCALE:

1/4" = 1'-0"

SHEET:

A - 8