



# RESIDENCE FOR:

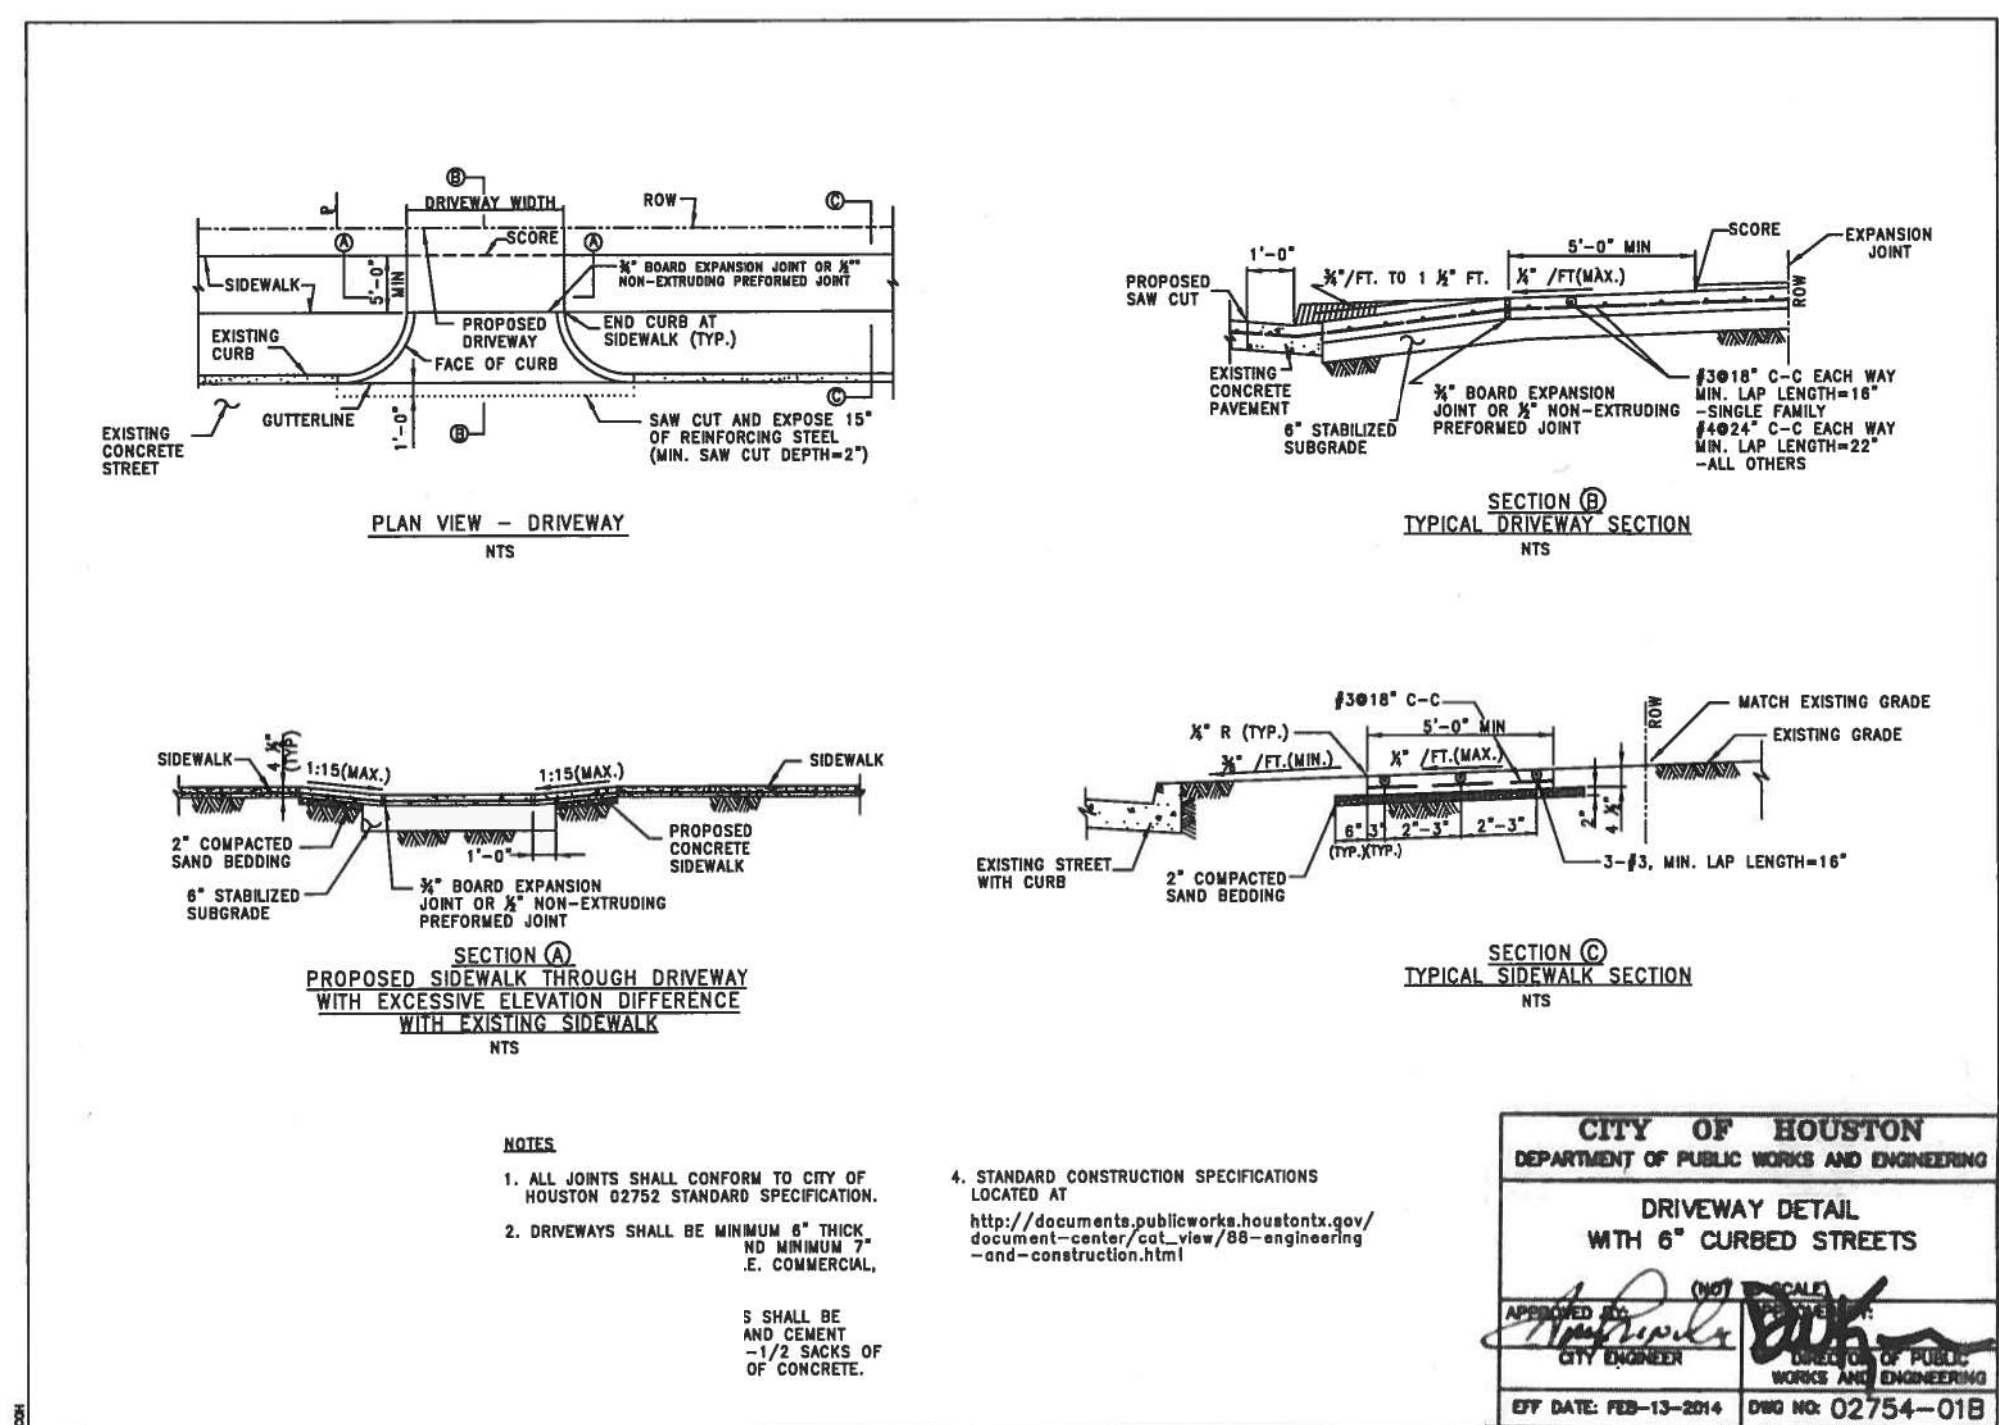

**SQUARE FOOTAGES:**


LOT SIZE	16,177
FIRST LEVEL	4,324
DRIVEWAY	2,236
FRONT WALK	187
POOL	602
TOTAL	7,349

TOTAL IMPERVIOUS 54.56%

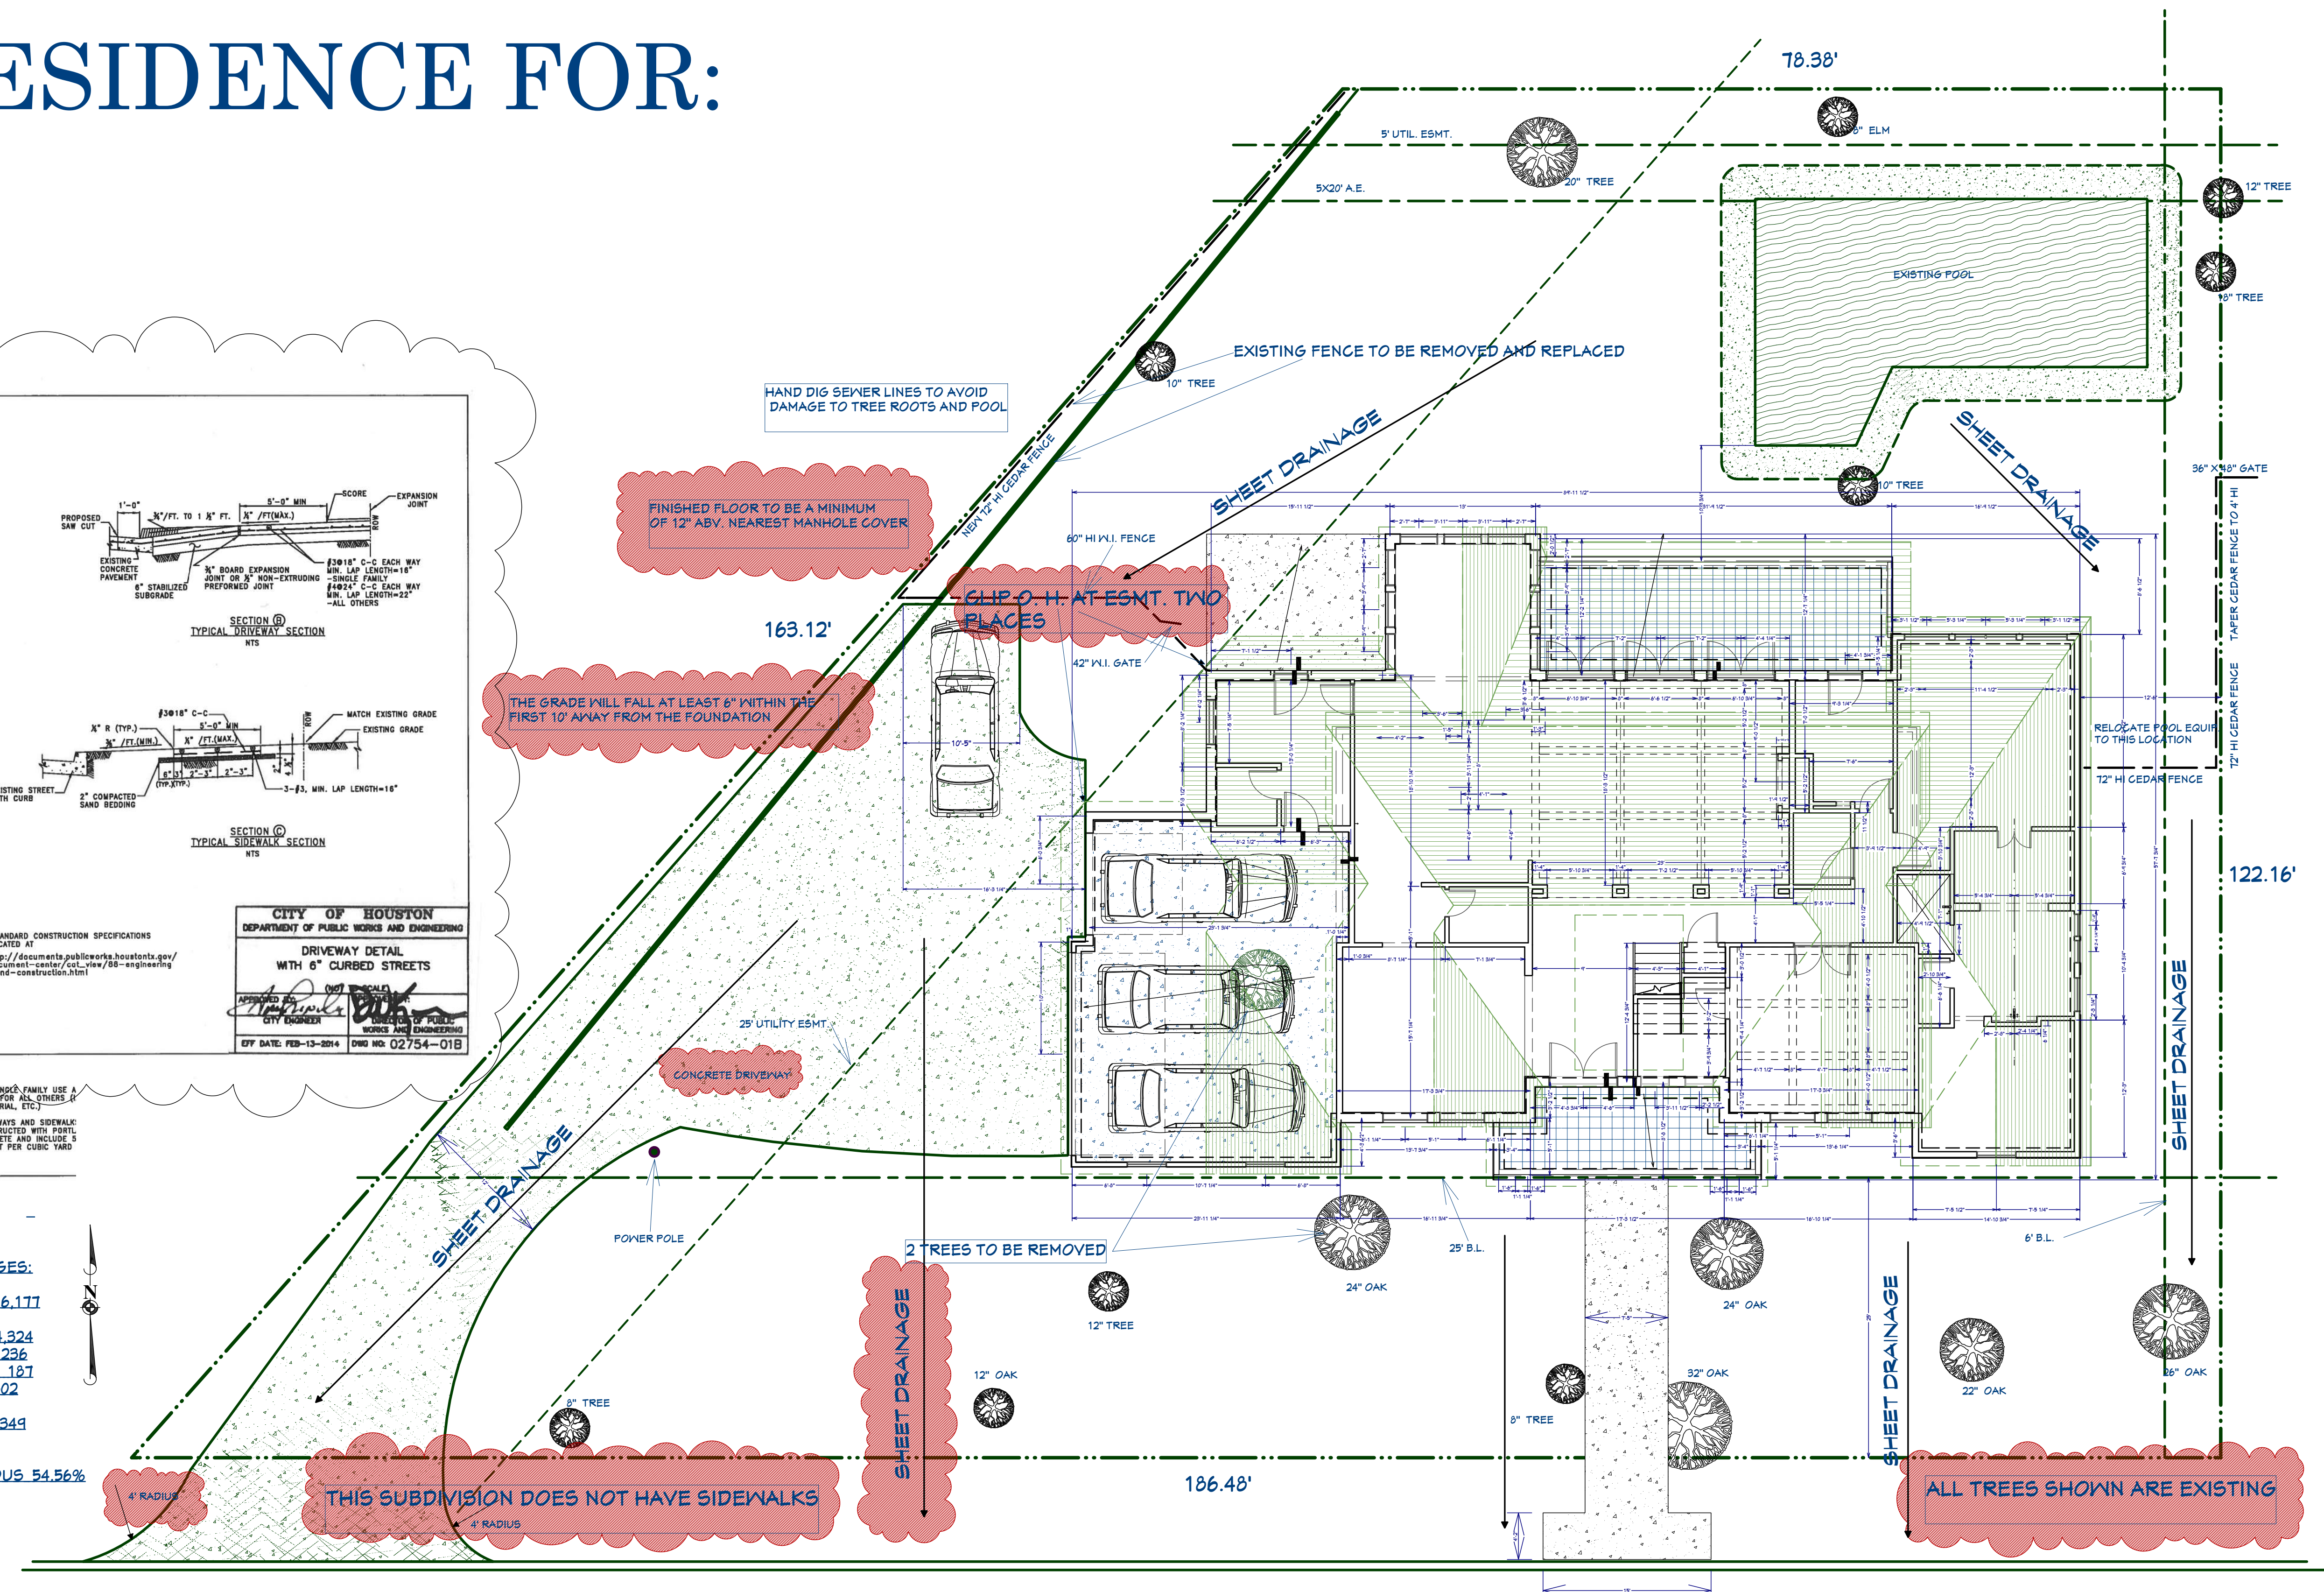

Plot Plan View  
scale 1/8"=1'-0"

800 Wilcrest suite 120  
Houston, Texas 77042  
PH. 713-789-8262  
CELL 713-806-1498

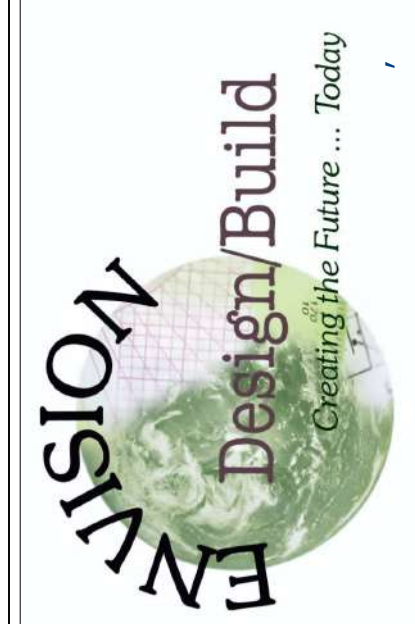

REVISIONS	DATE
Revision #2	8-21-2020

**UNLESS OTHERWISE NOTED:**

11'-0" CLG. AT FIRST FLOOR  
 10'-0" CLG. AT SECOND FLOOR  
 1X12" BASE AT FIRST FLOOR  
 1X10" BASE AT SECOND FLOOR  
 CM 50 CROWN WITH CRADLE FIRST AND SEC. FLOOR  
 KERFED JAMBS AT DOORS, NO CASING, 3/8" BULLNOSE  
 1/2" SH/RK WALLS AND CLG.  
 5/8" SH/RK WALLS AND CLG. IN GARAGE  
 SQUARE SH/RK RETURNS AT WINDOWS AND CORNERS  
 1 3/8" S.C. INT. DOORS  
 1 3/4" S.C. EXT. DOORS  
 TANKLESS WH. IN ATTIC  
 14" DEEP UPPER CABINETS IN KITCHEN & BUTLERS

**SQUARE FOOTAGE:**


**FIRST FLOOR 2987**  
**SECOND FLOOR 1562**  
**TOTAL LIVING AREA 4549**

**GARAGE 745**  
**PORCHES 492**

**TOTAL COVERED AREA 5786**

**56% BRICK AT EXTERIOR WALLS**

THIS PROJECT SHALL COMPLY WITH 2012 IRC WITH COH AMENDMENTS  
 2012 UMC  
 2012 UPC  
 2017 NEC  
 2012 IFC  
 2015 INTERNATIONAL ENERGY CONSERVATION CODE

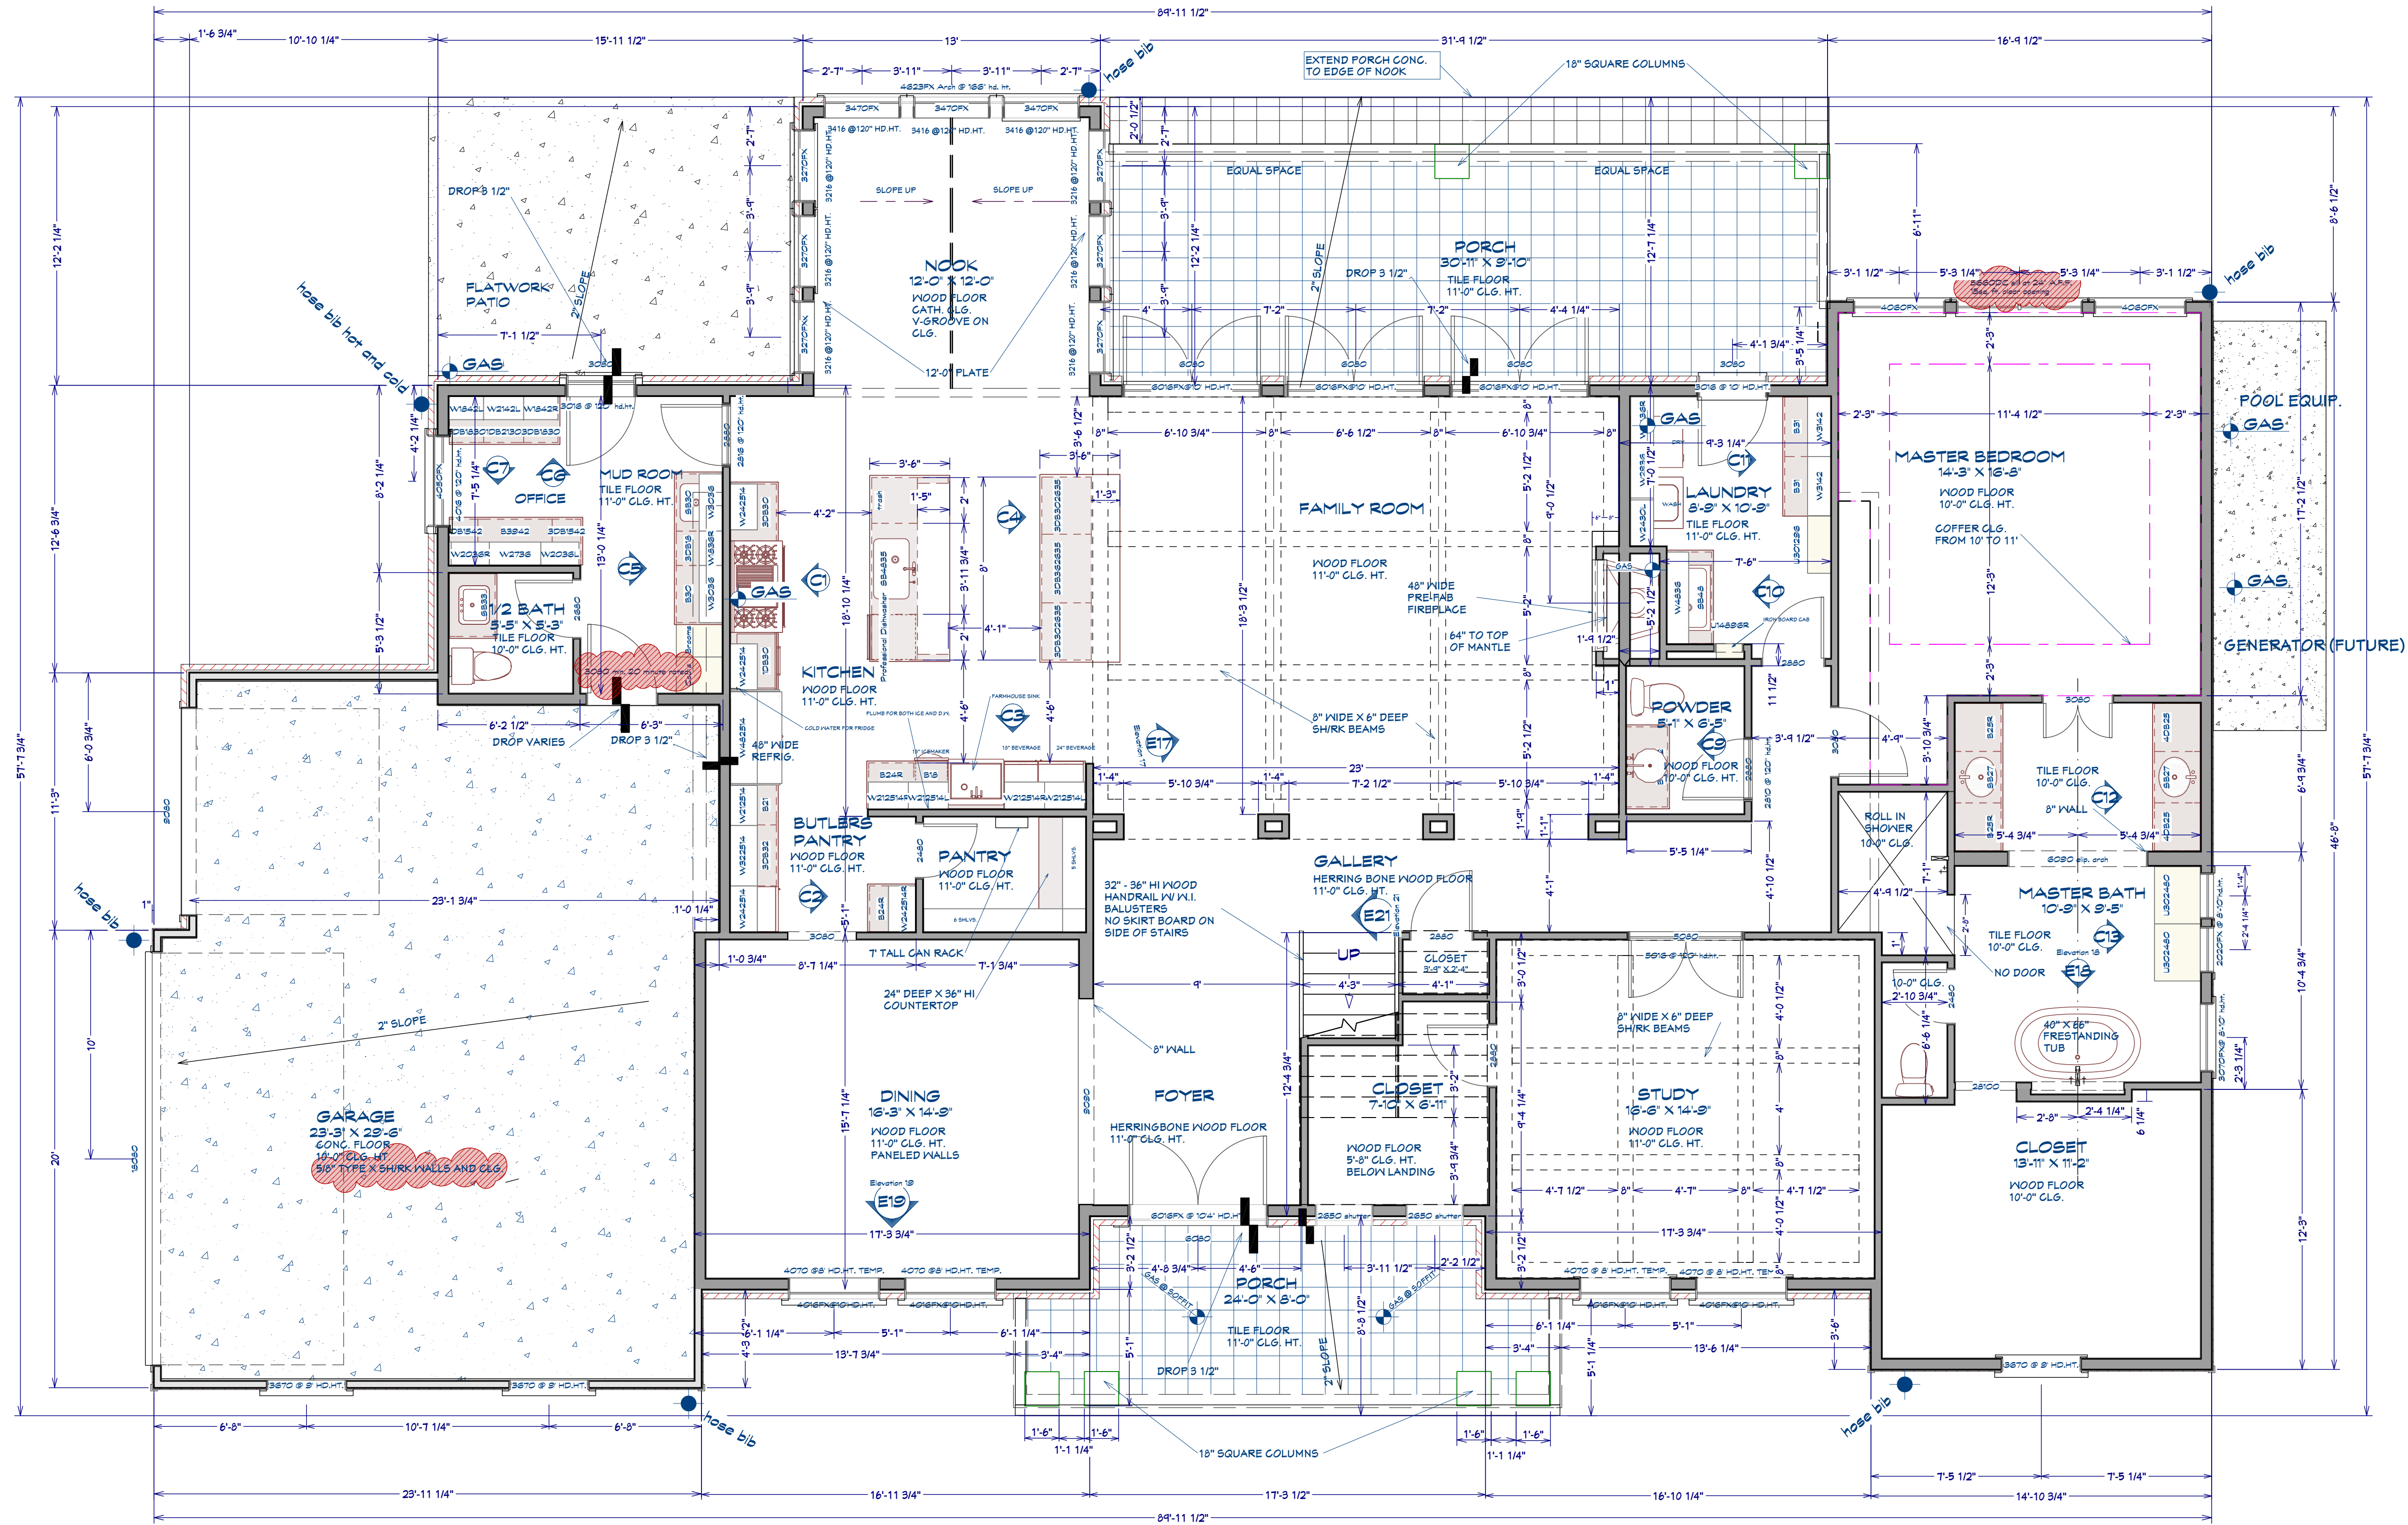

1st Floor

Date:  
12-20-2020


800 Wilcrest suite 120  
 Houston, Texas 77042  
 PH. 713-789-8262  
 CELL 713-806-1448




DATE

Revision #2


REVISIONS

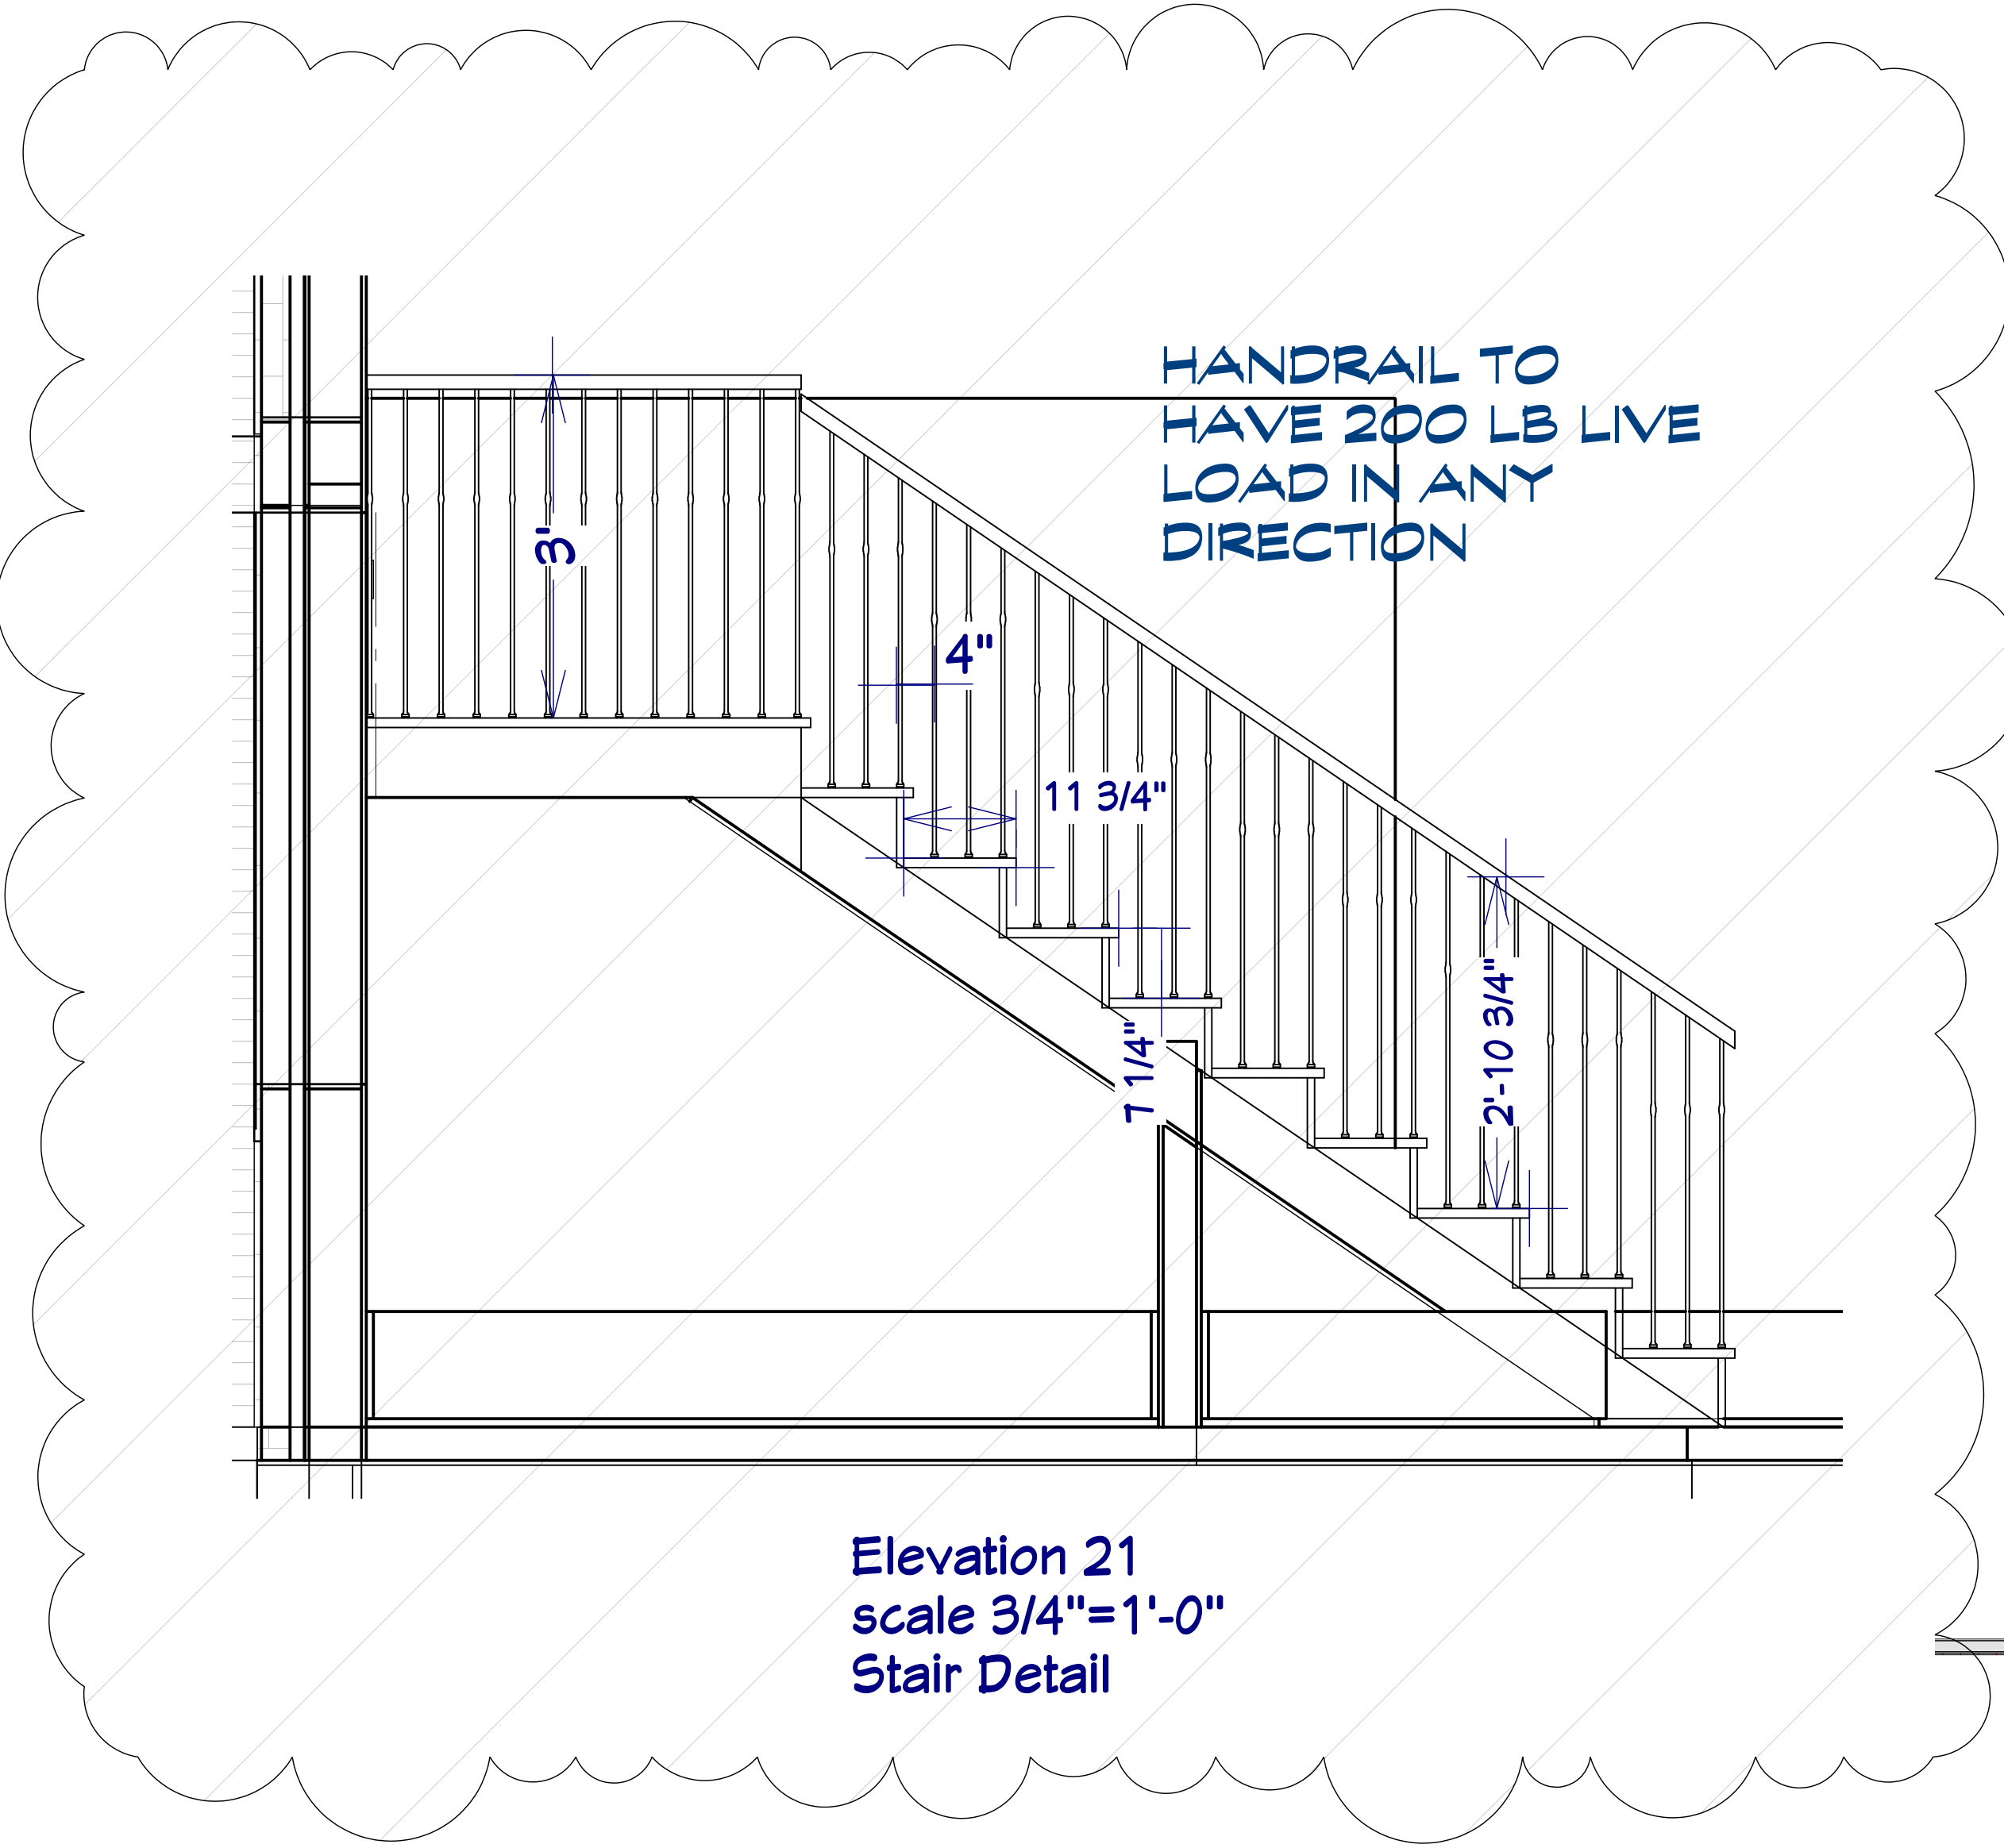

Elevation 21  
scale 3/4"=1'-0"  
Stair Detail

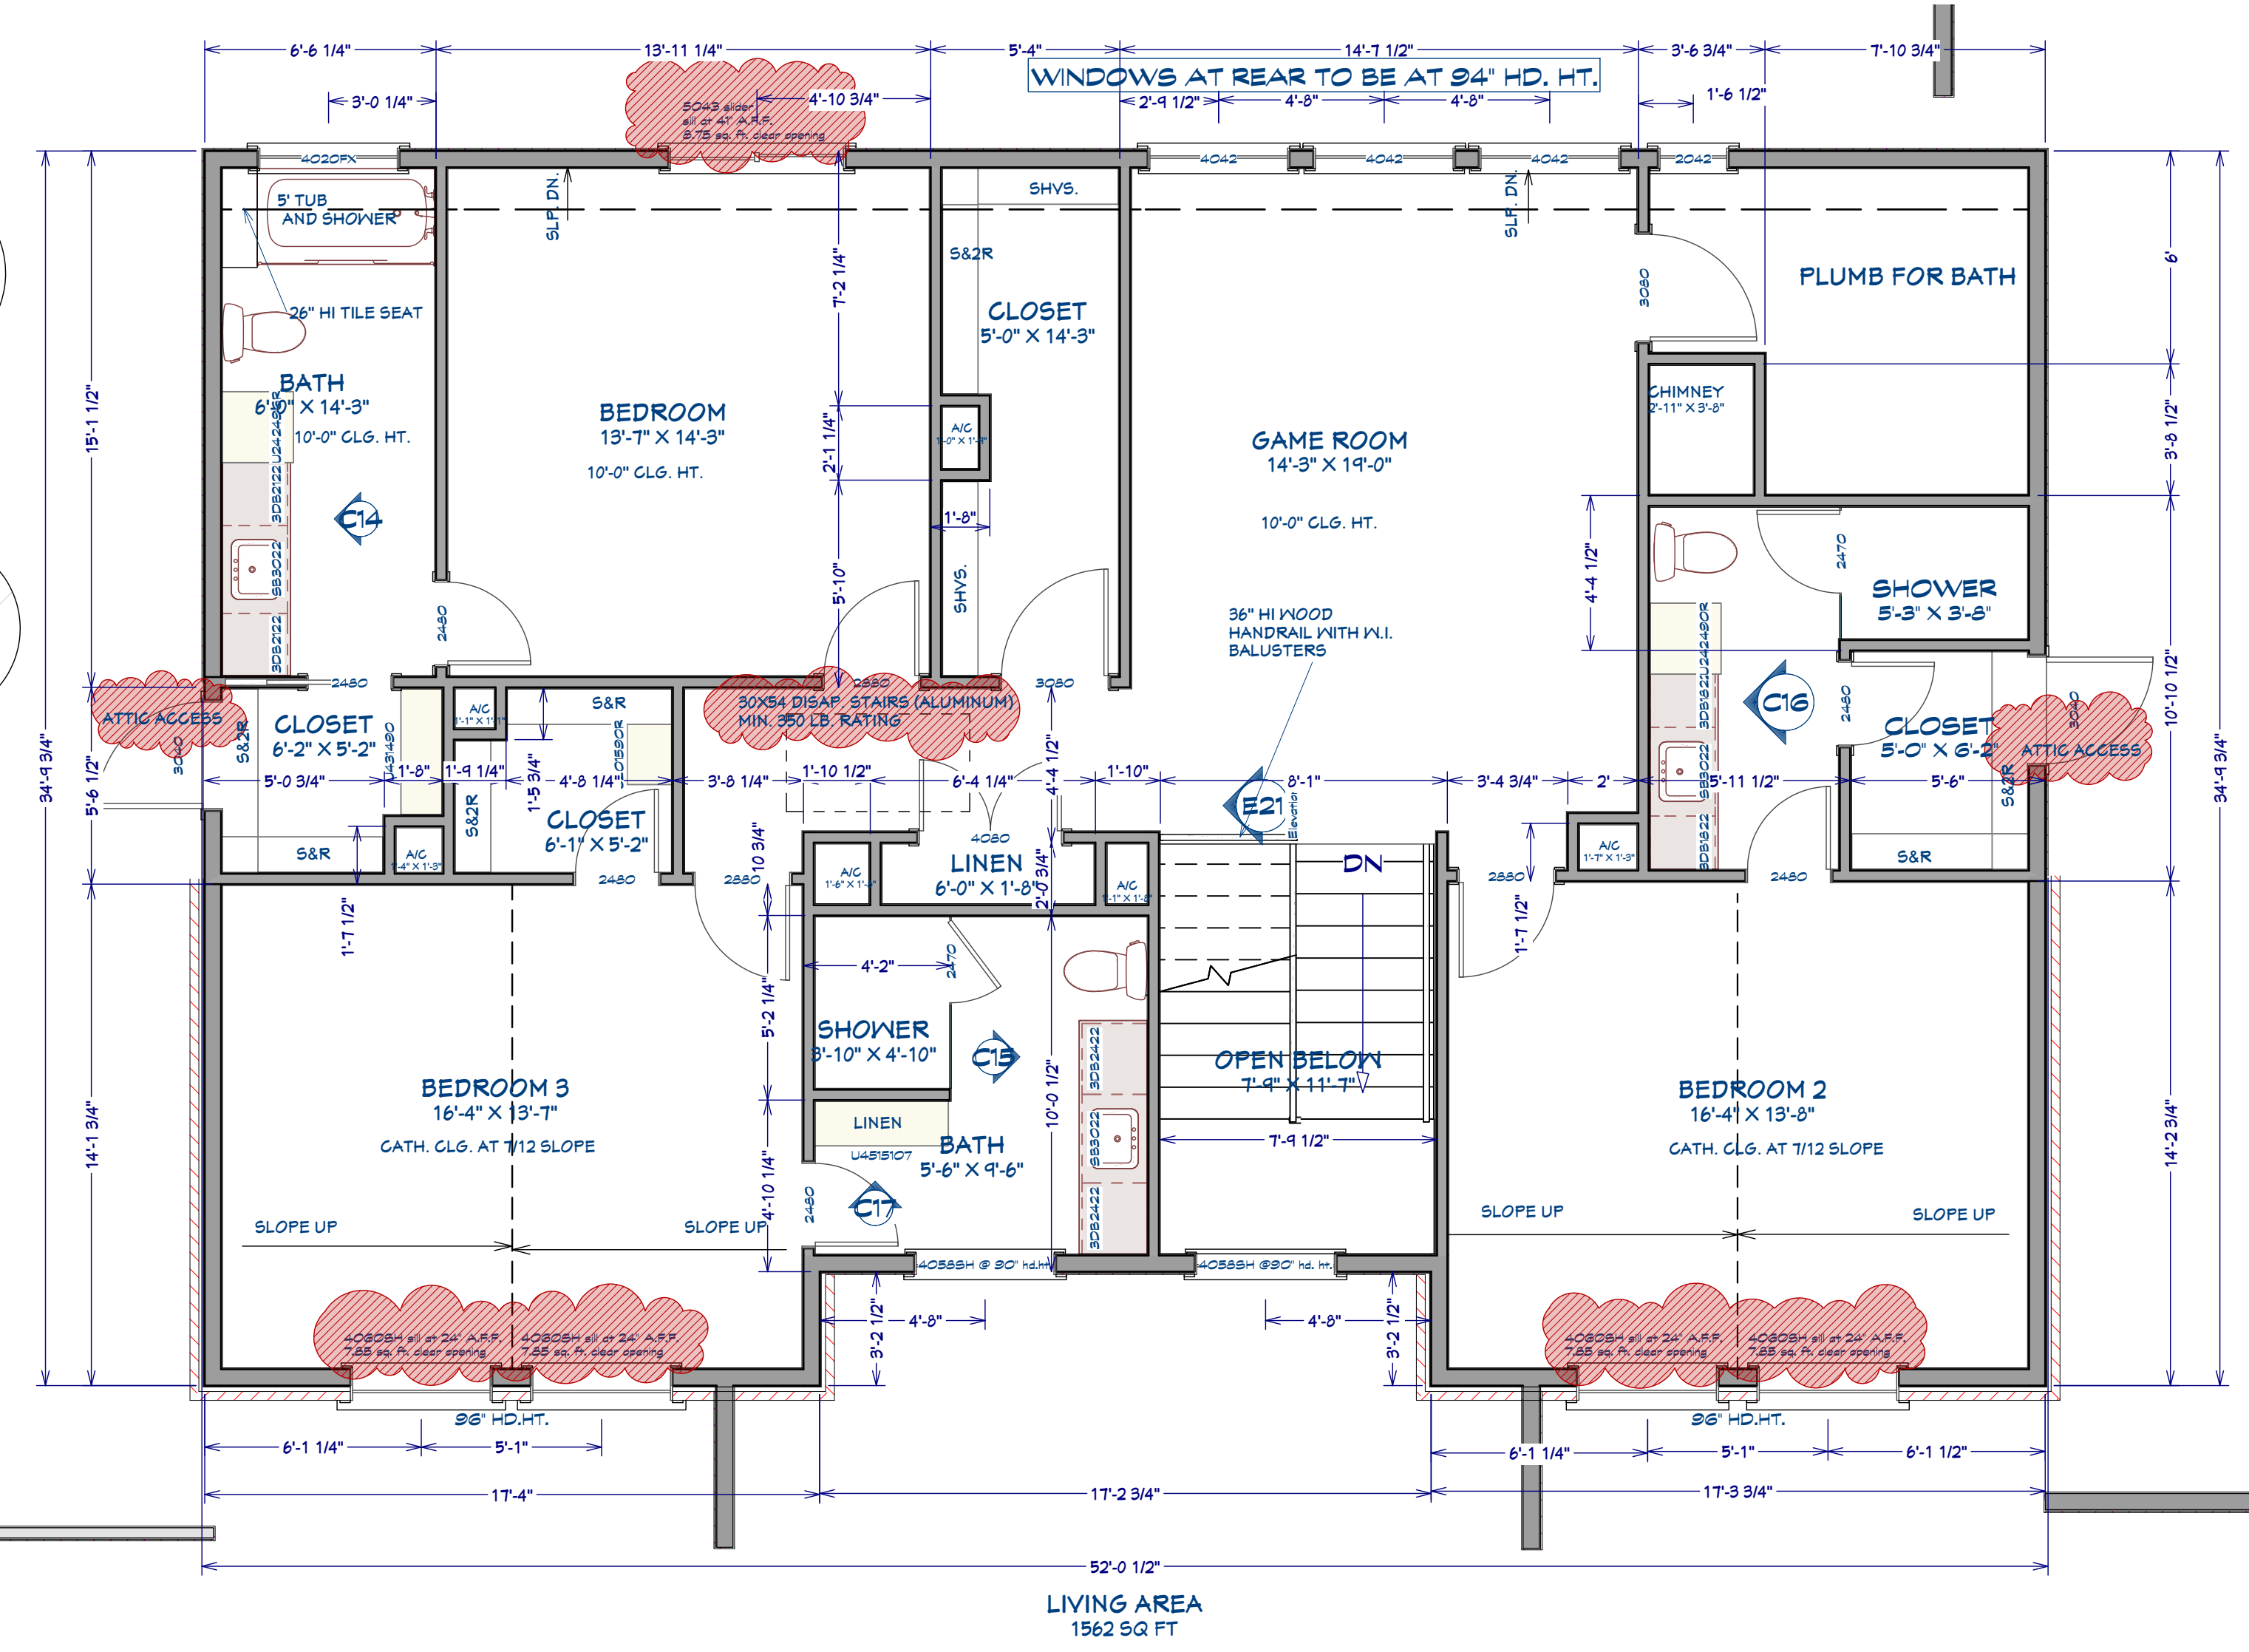


2nd Floor Plan  
scale 1/4"=1'-0"

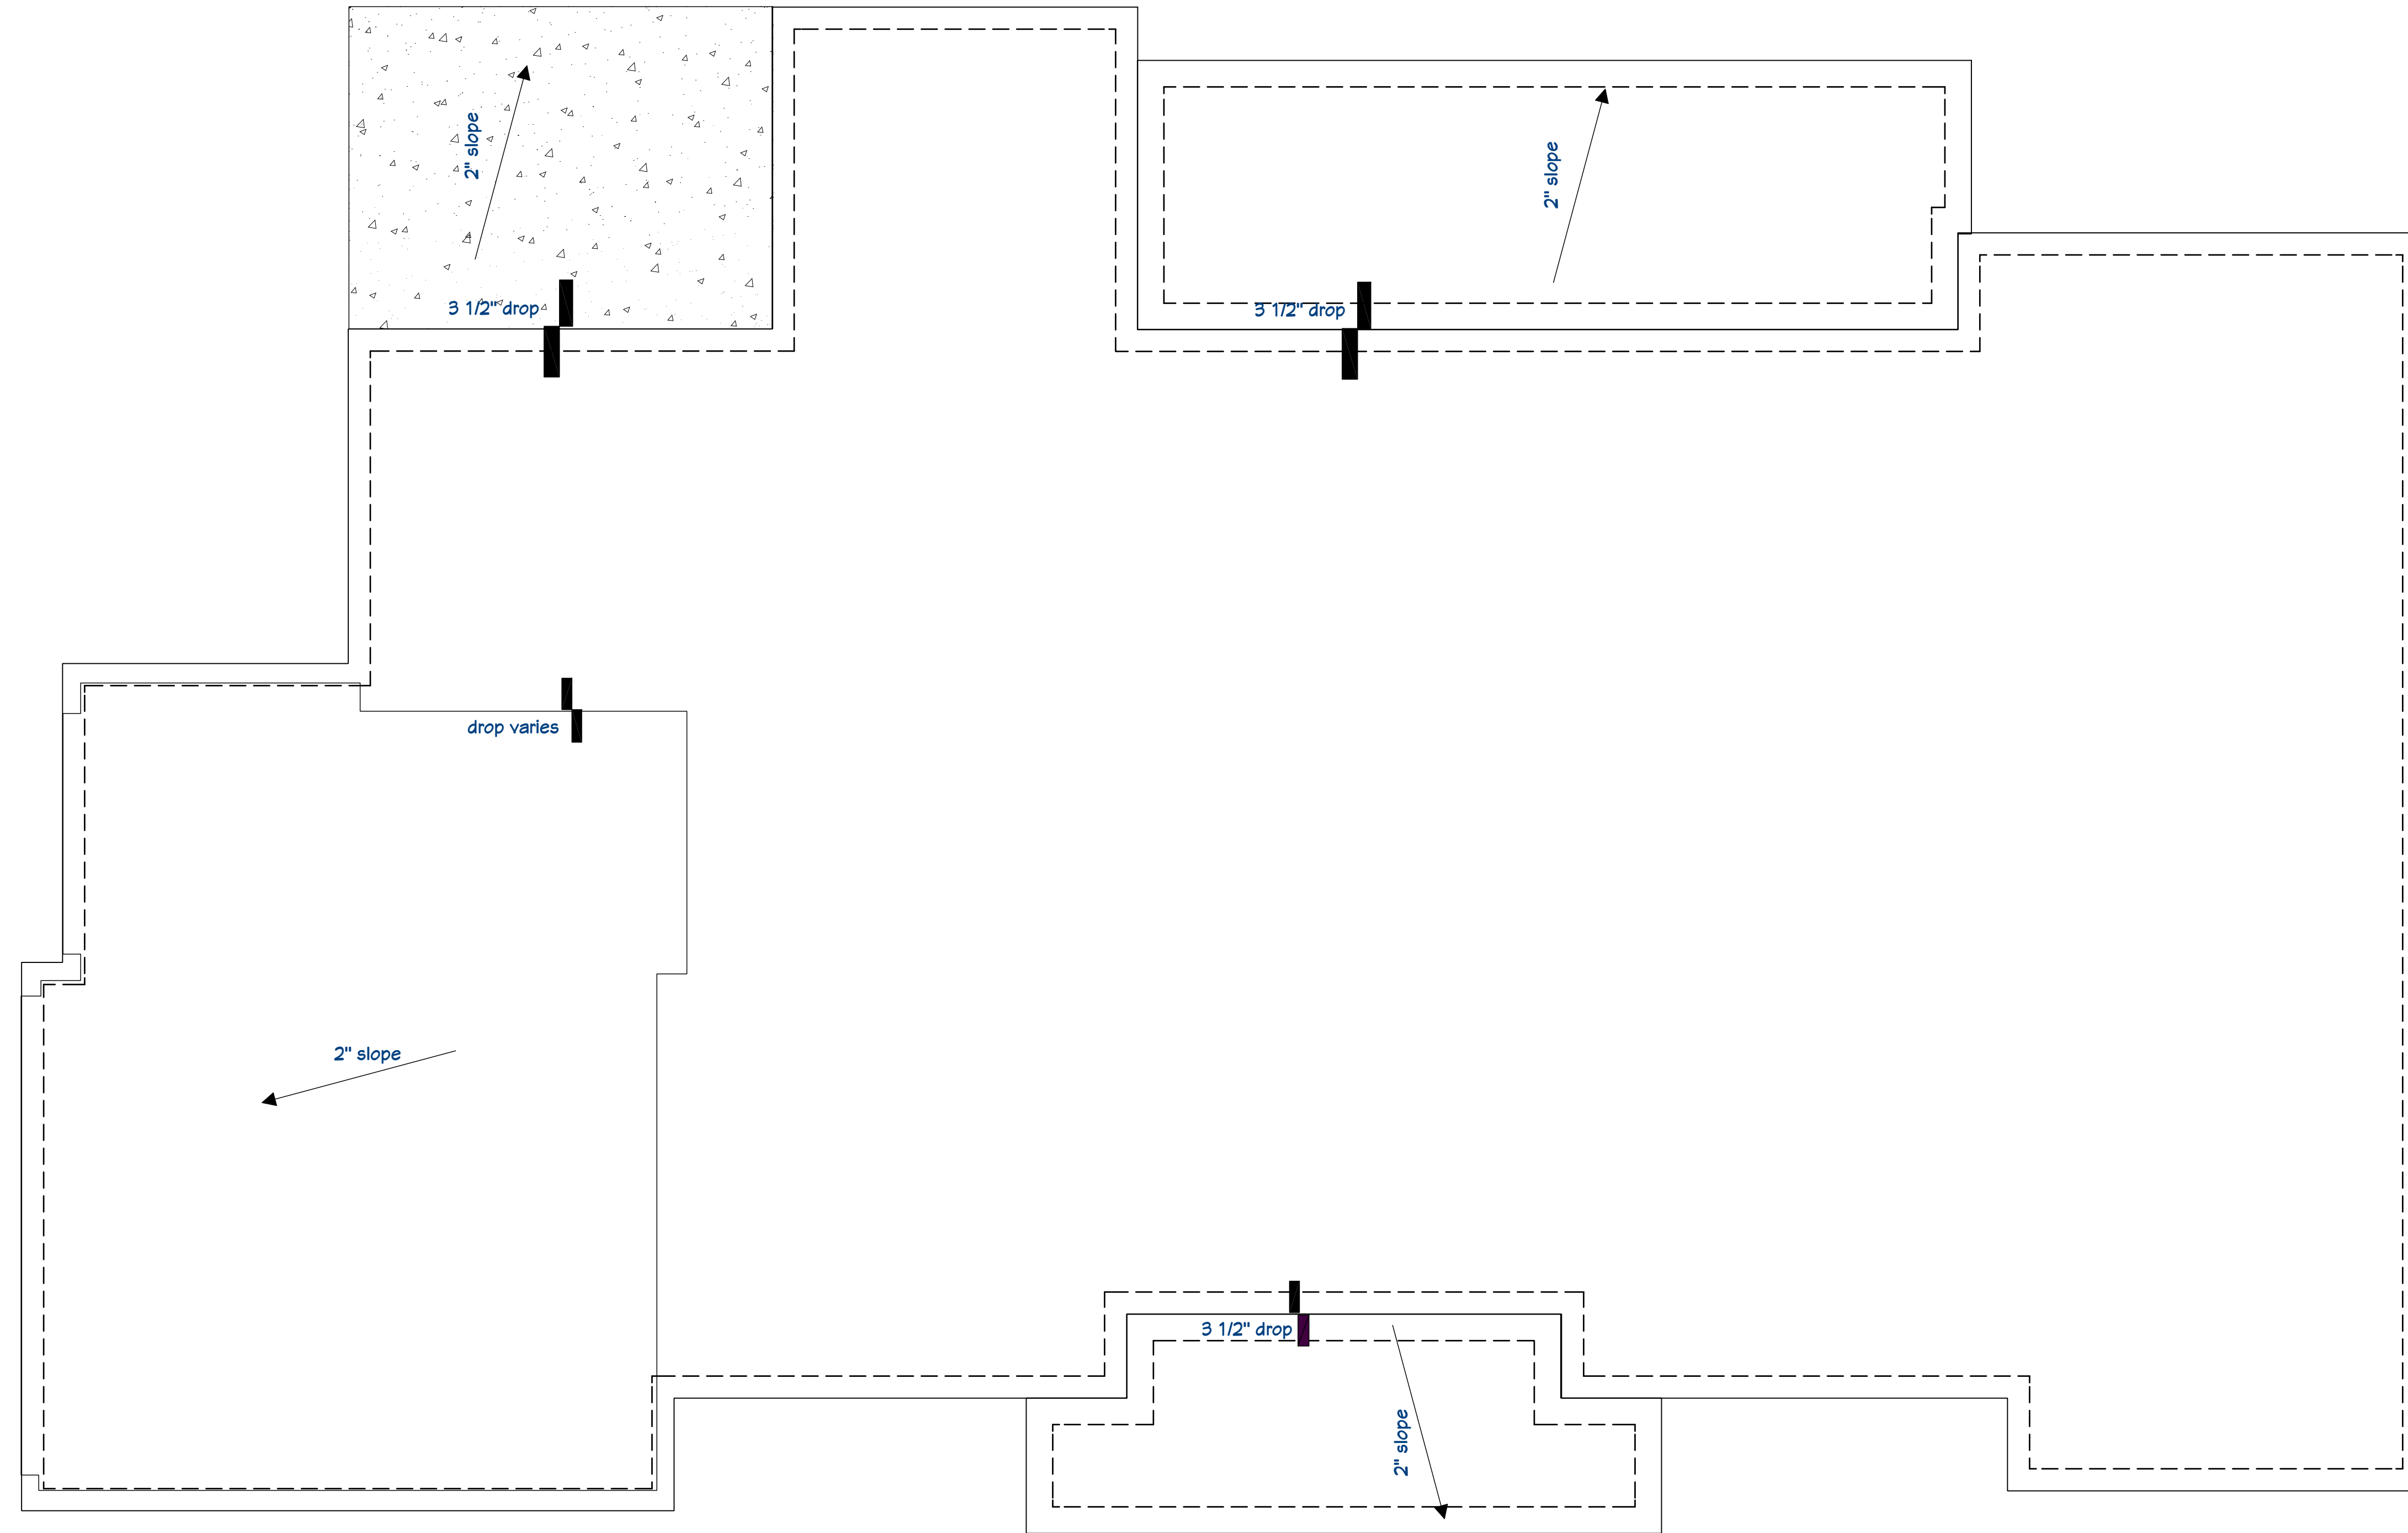

Foundation Plan  
scale 1/4"=1'-0"  
SEE ENGINEERS PLAN

800 Wilcrest suite 120  
Houston, Texas 77042  
PH. 713-789-8262  
CELL 713-806-1998

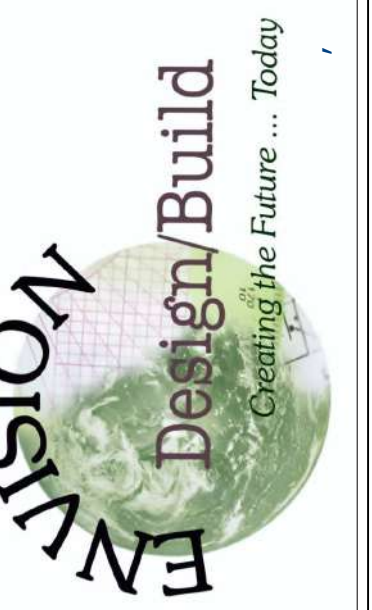

REVISIONS	DATE
Revision #2	8-21-2020



South Elevation



North Elevation

800 Wilcrest suite 120  
Houston, Texas 77042  
PH. 713-789-8262  
CELL 713-806-1998




REVISIONS


DATE

Revision #2

A-5

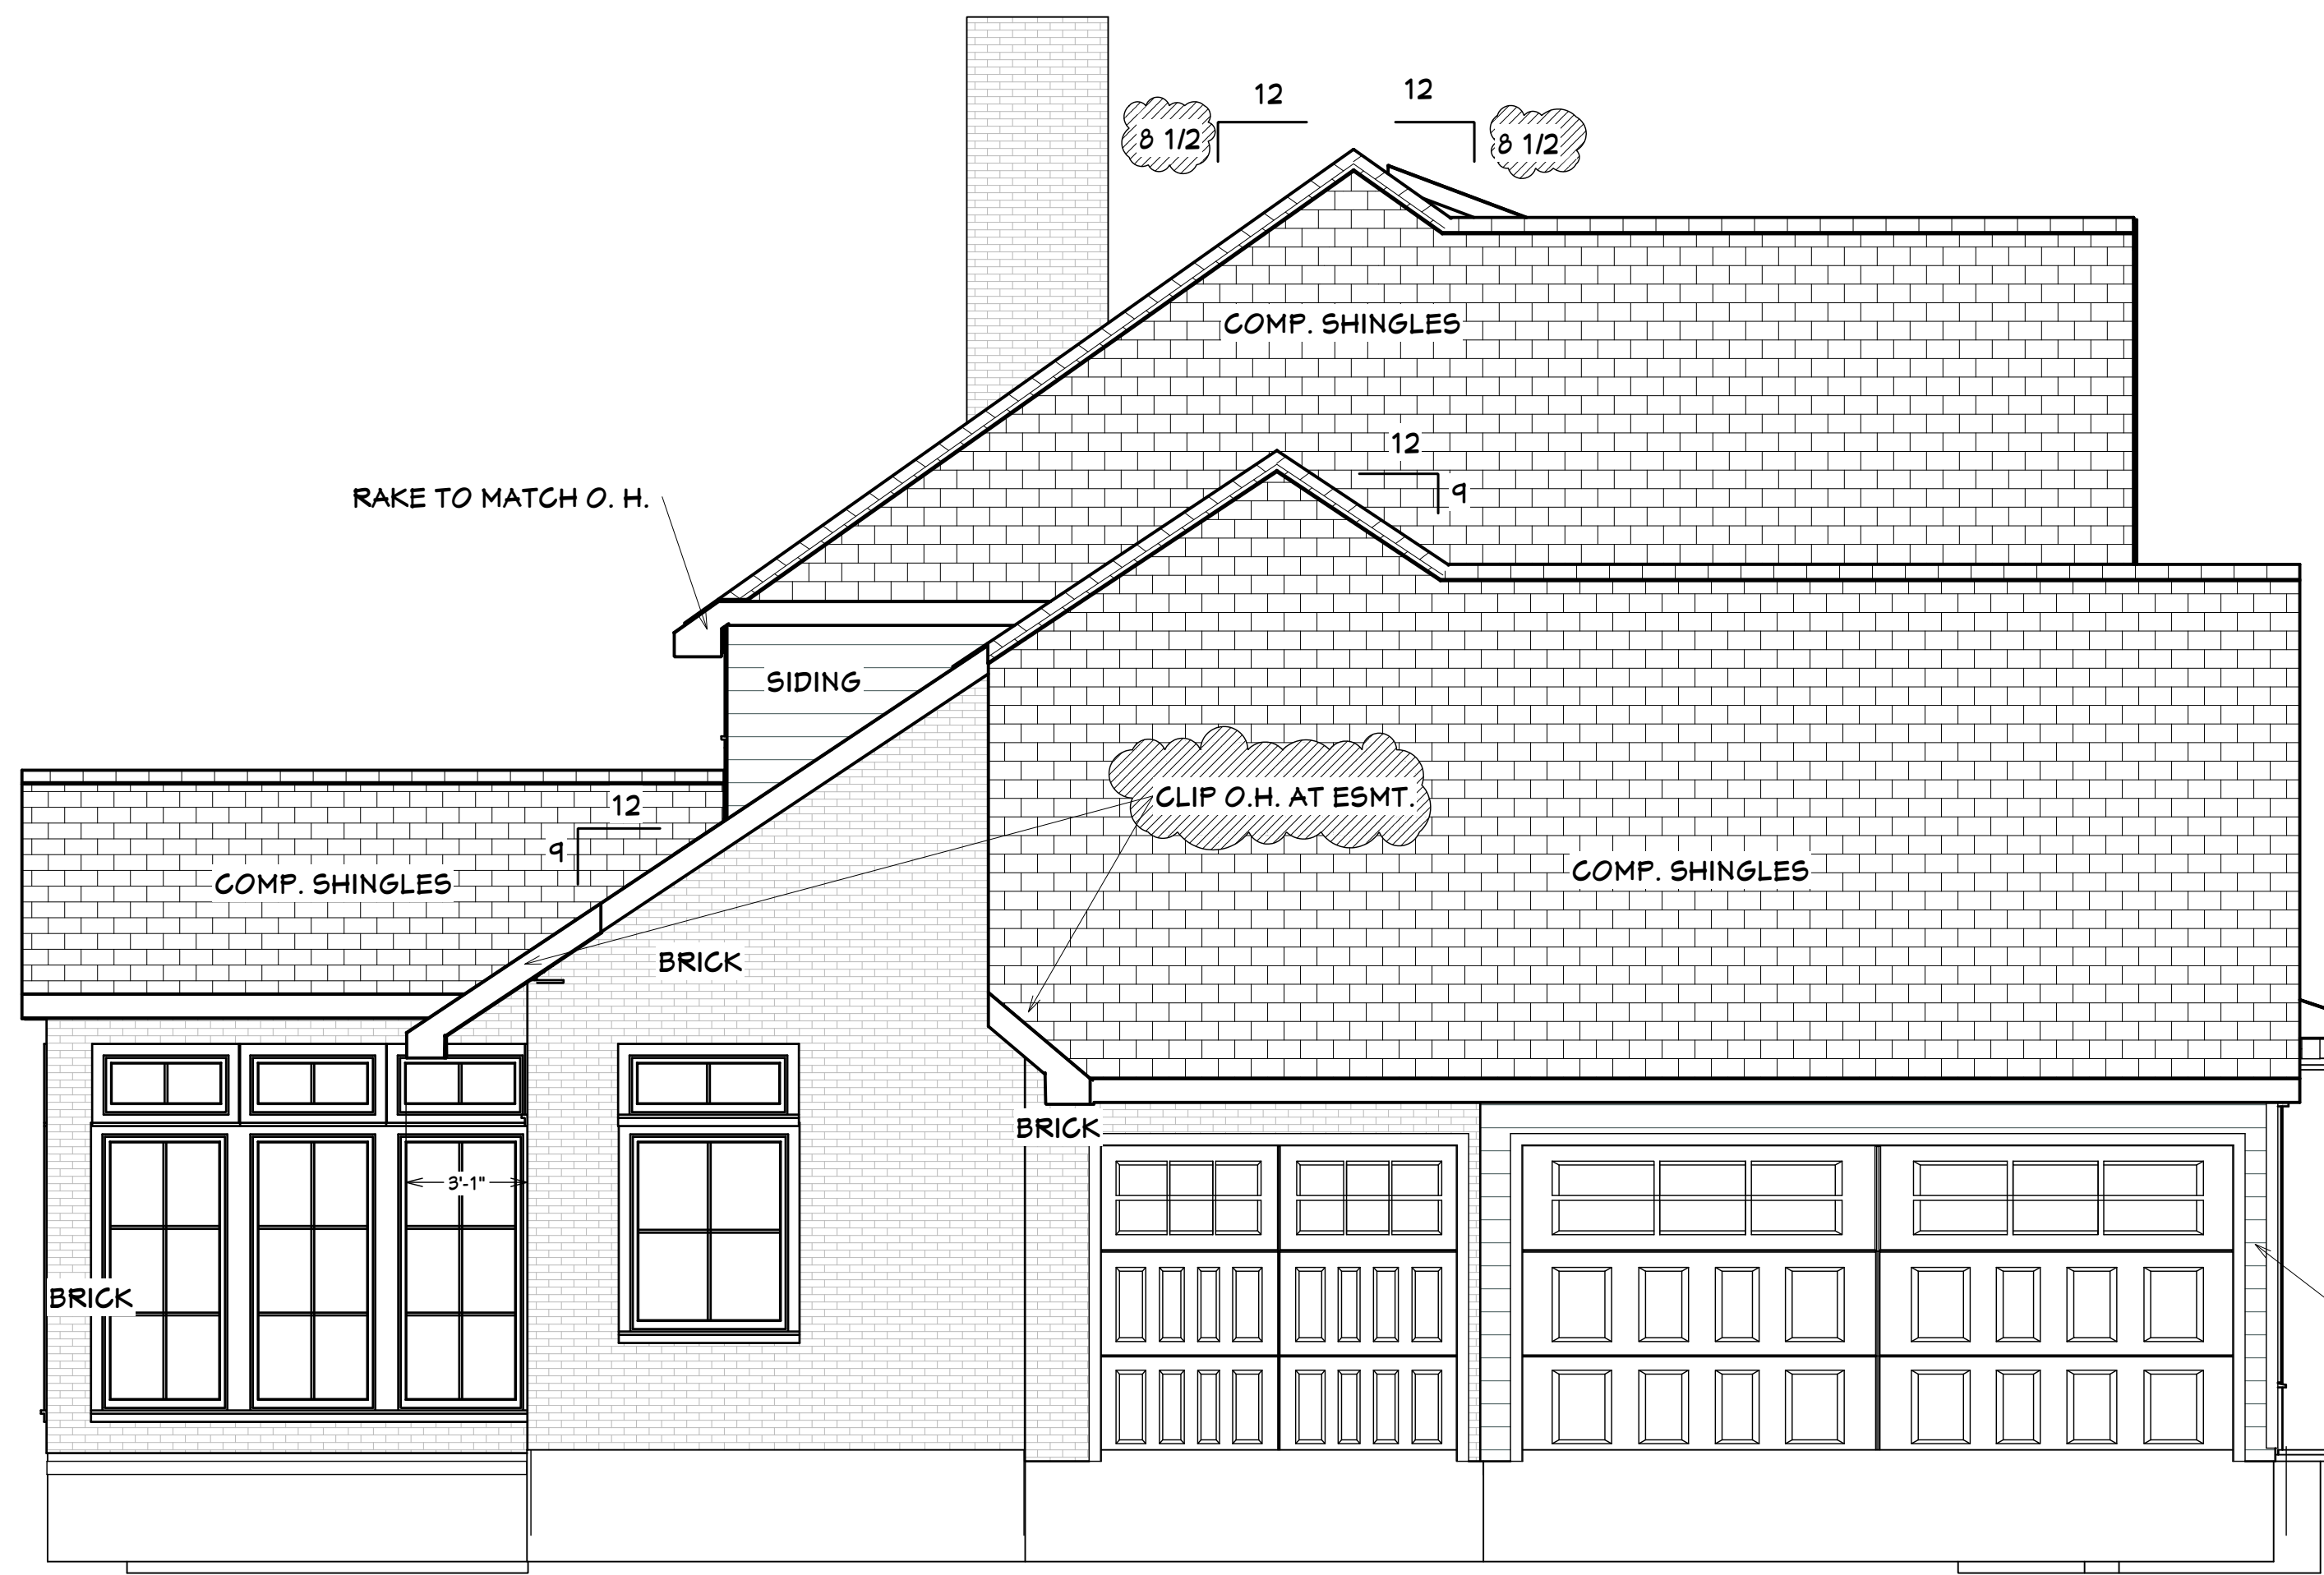


West Elevation  
scale 1/4"=1'-0"

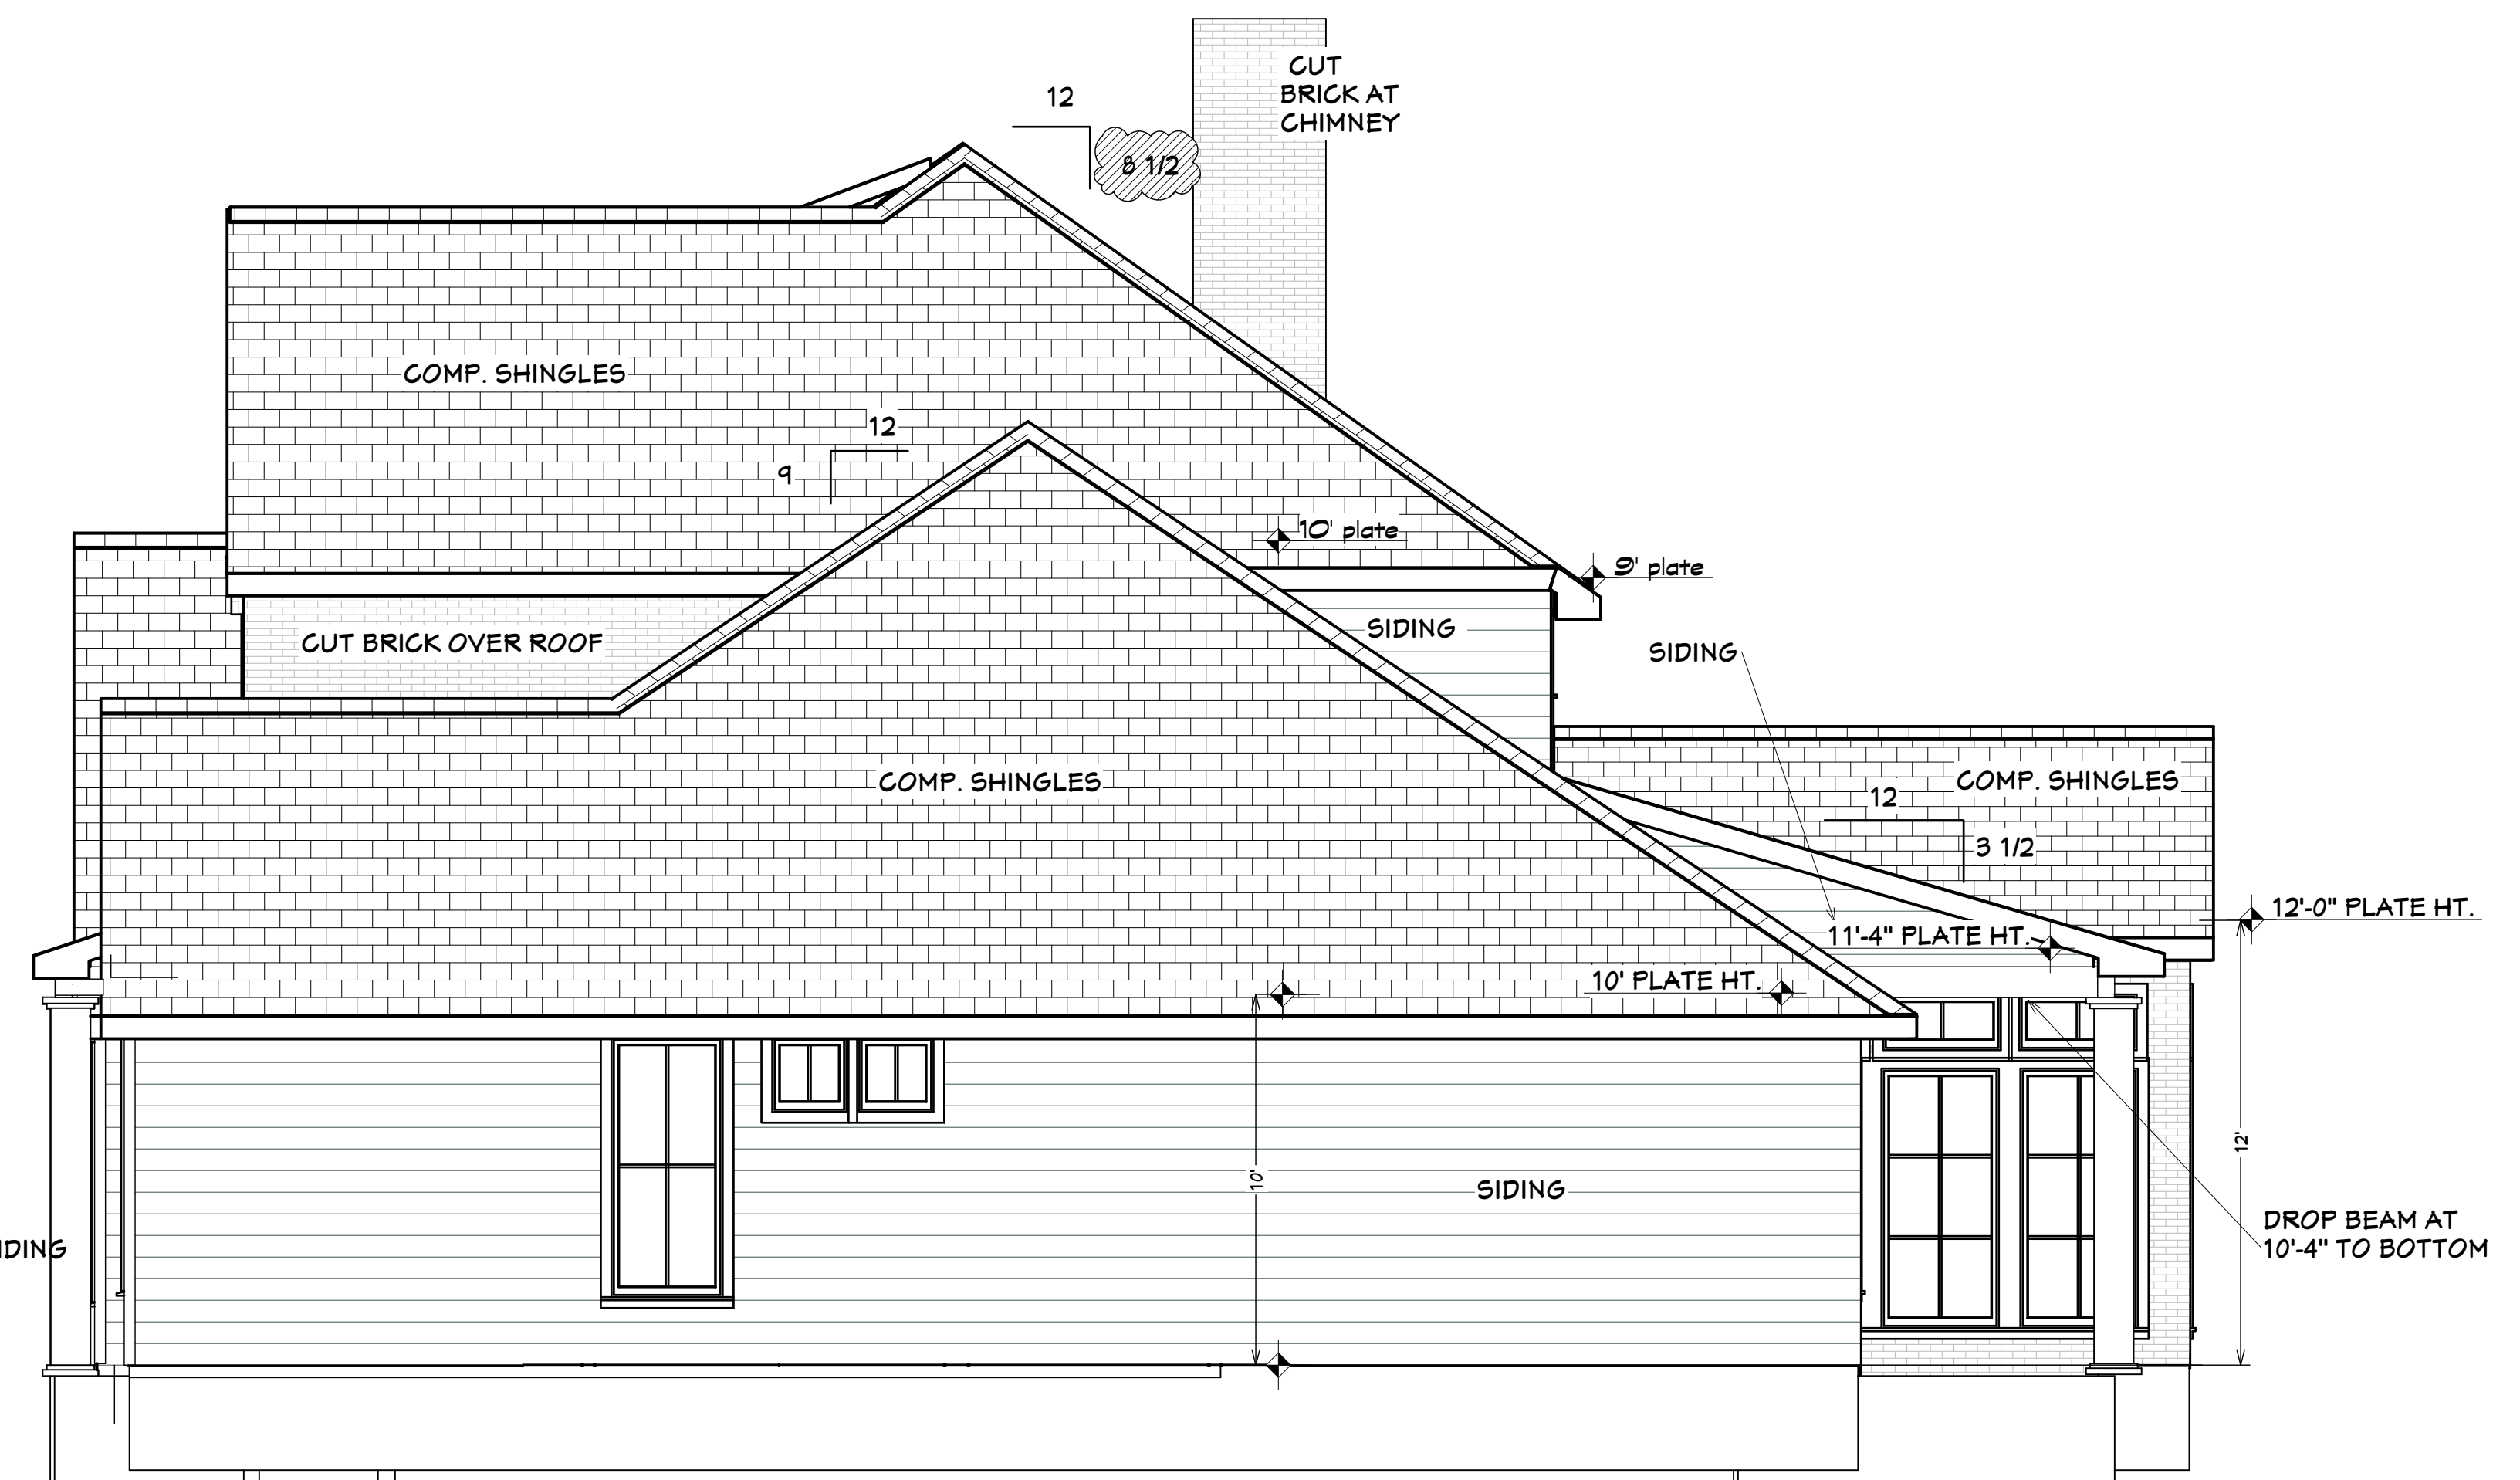


East Elevation  
scale 1/4"=1'-0"

Interior Cabinets  
scale 3/4"=1'-0"

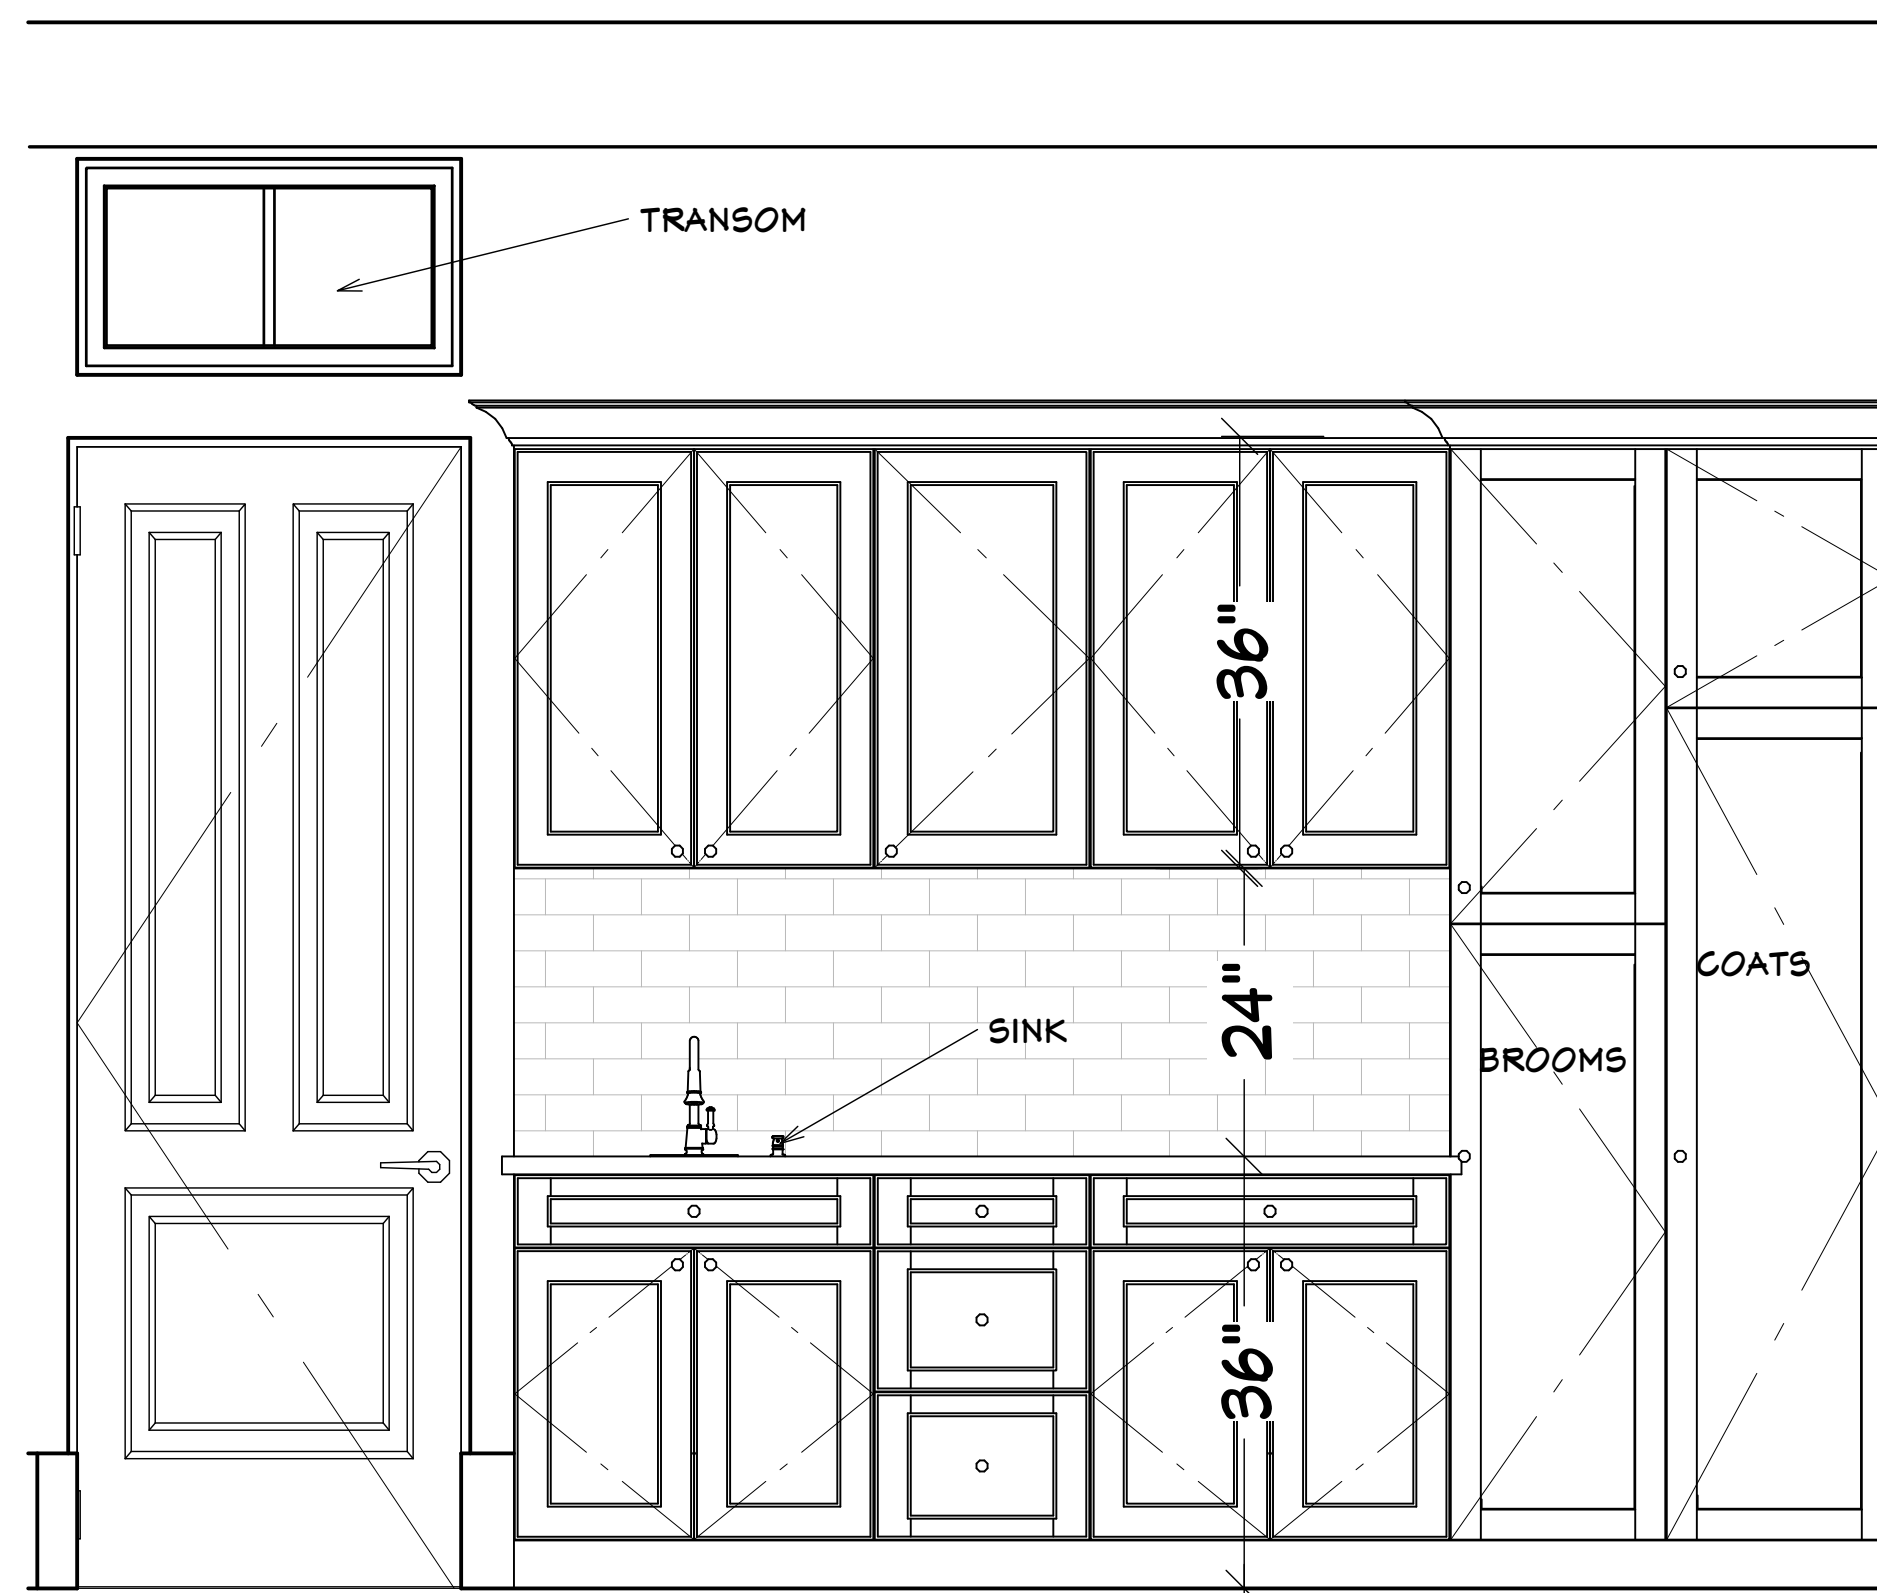

C5

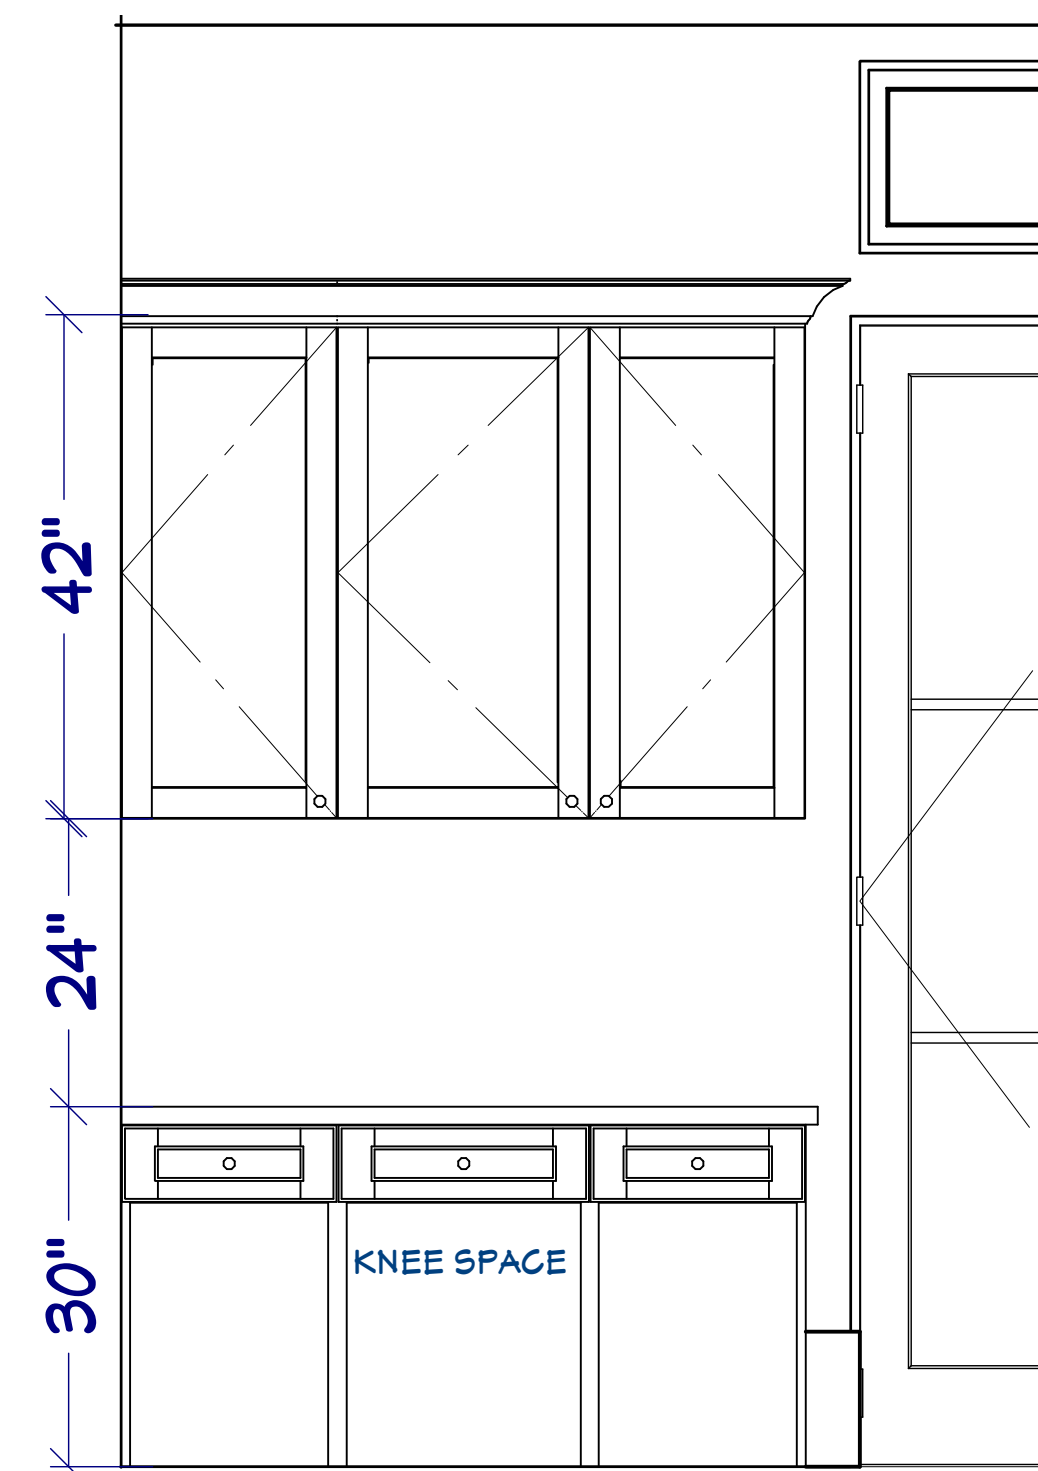


C6




C7

800 Wilcrest suite 120  
Houston, Texas 77042  
PH. 713-789-8262  
CELL 713-806-1998

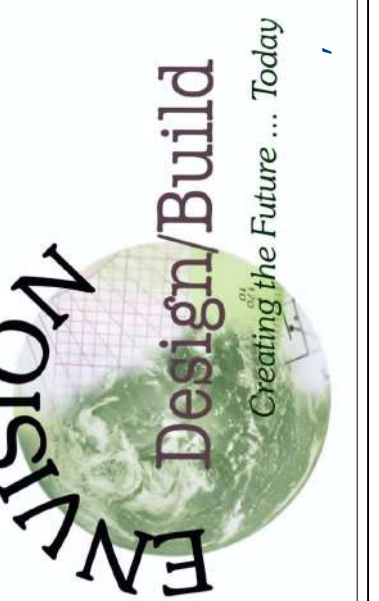

REVISIONS	DATE
Revision #2	8-21-2020




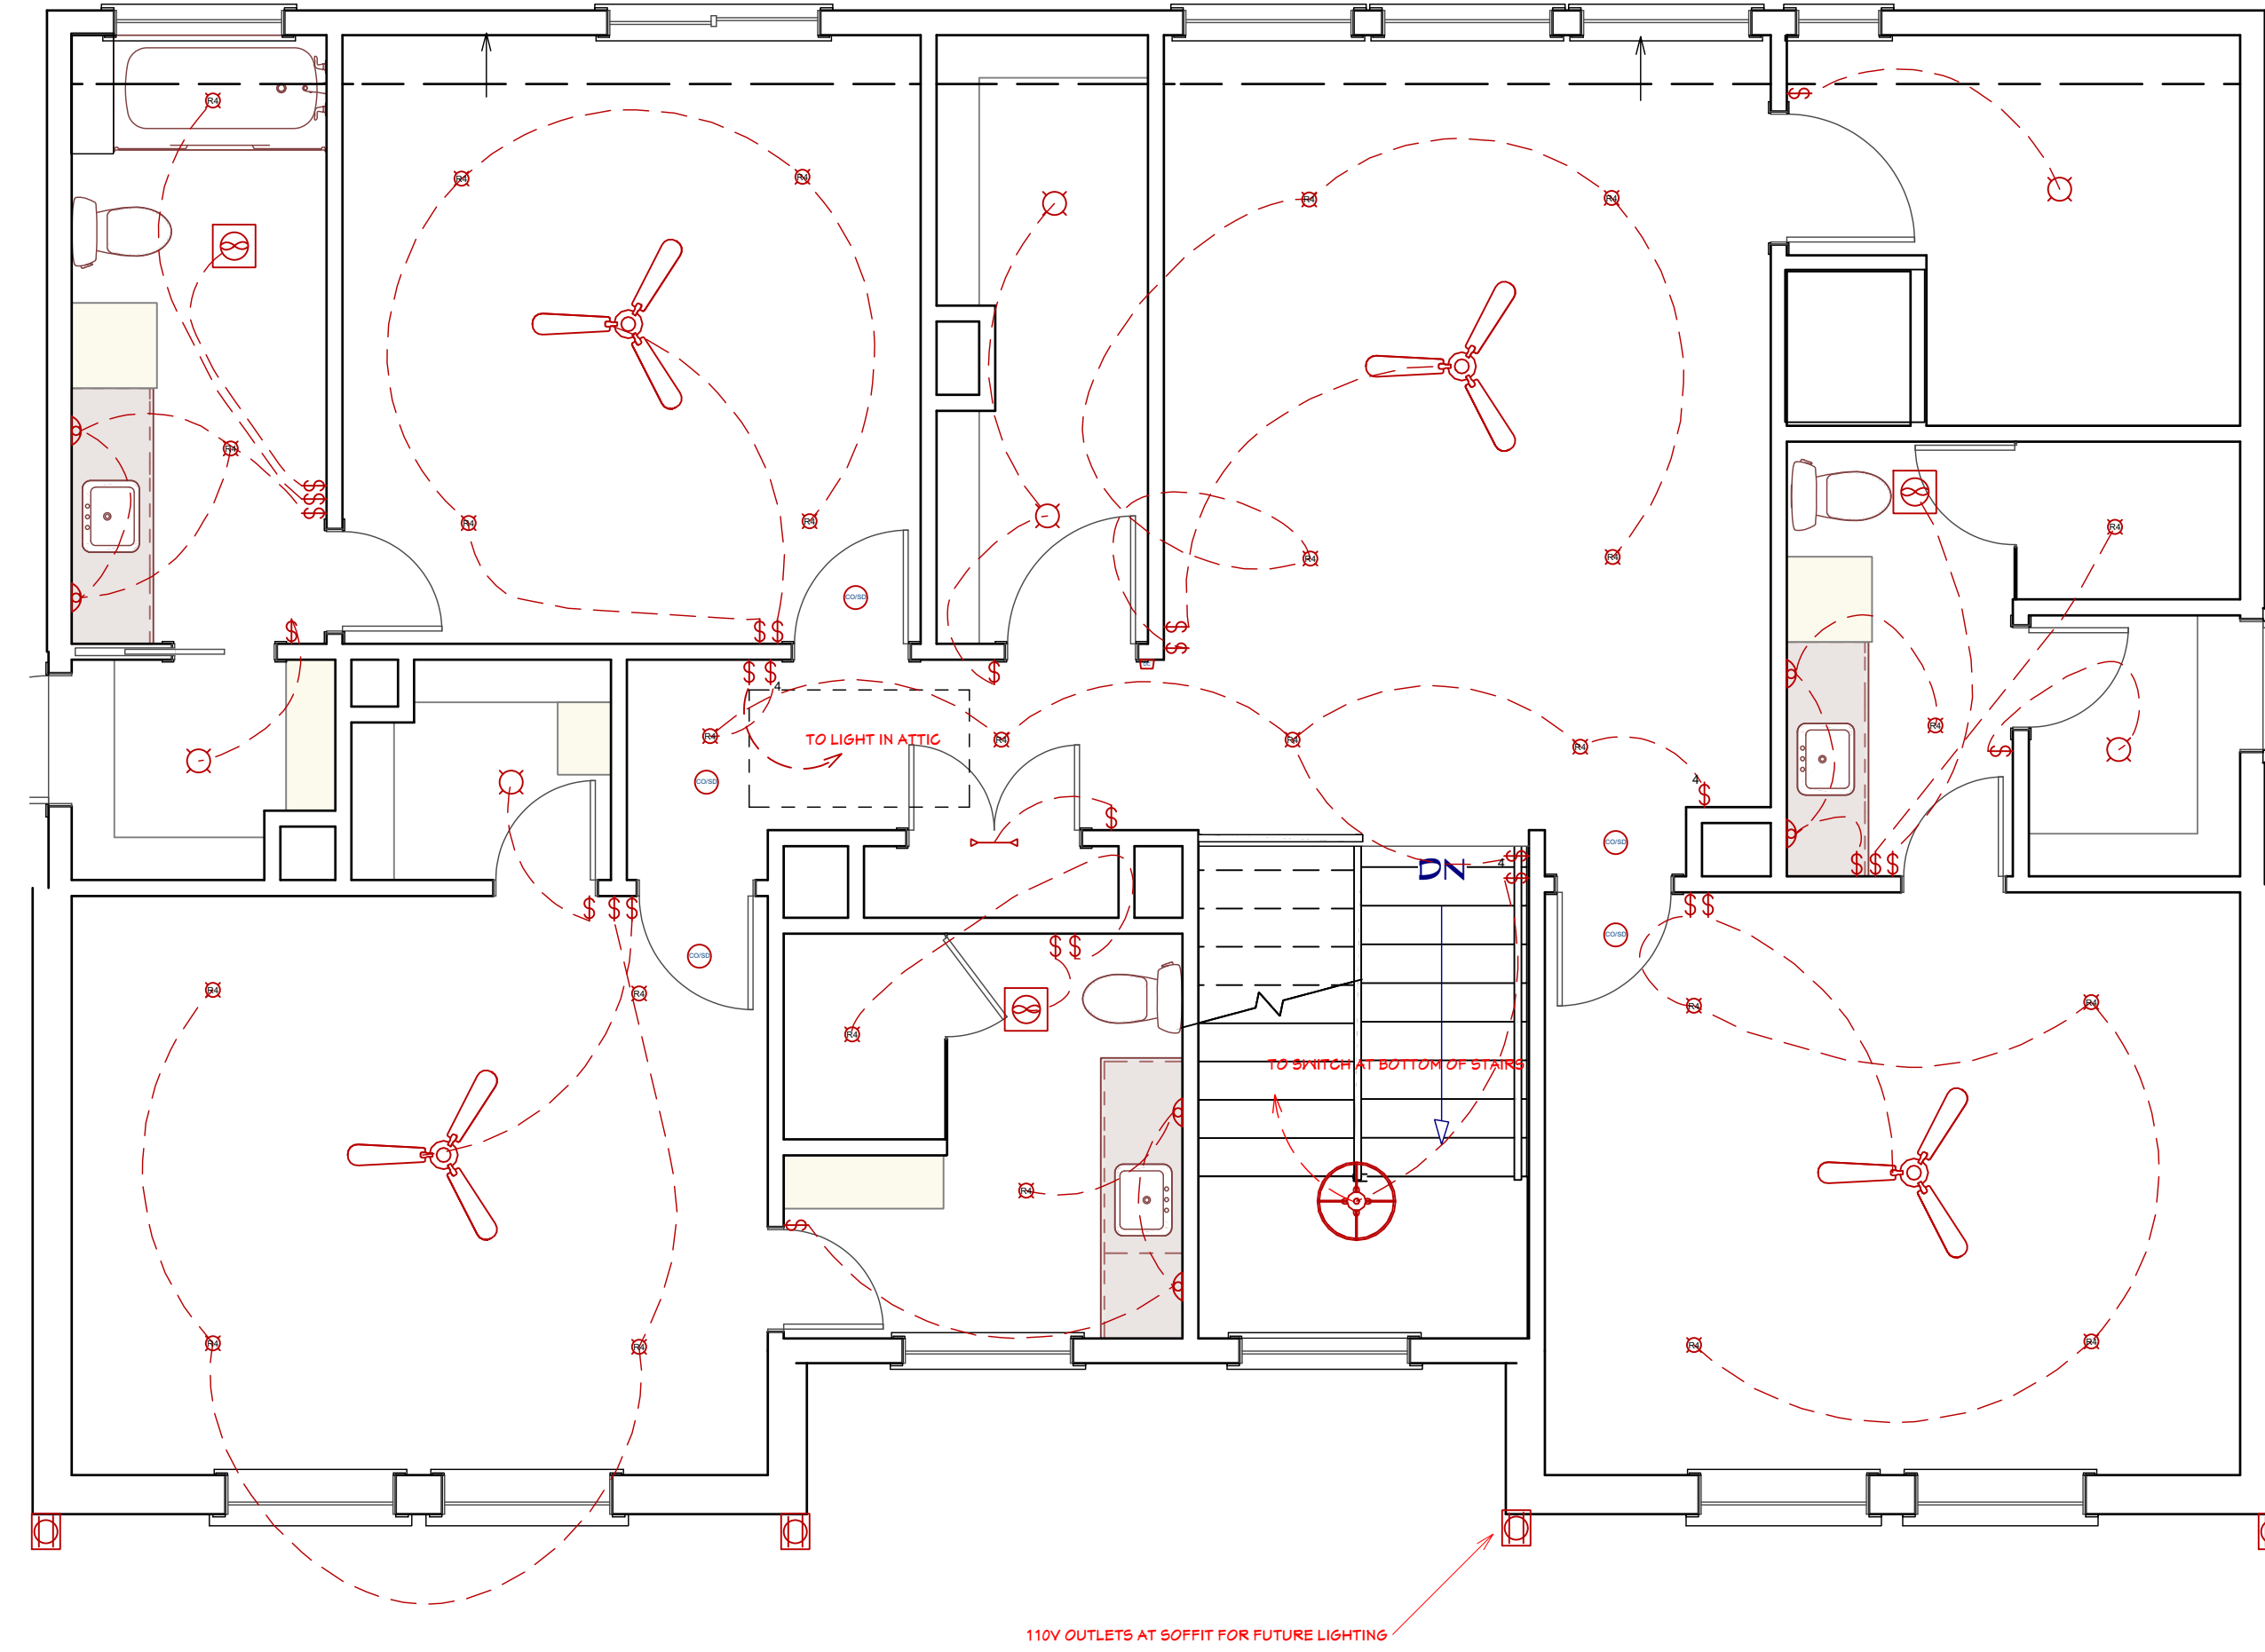


S. F. Electrical Plan View  
scale 1/4"=1'-0"

REVISIONS	DATE
Revision #2	8-21-2020

800 Wilcrest suite 120  
Houston, Texas 77042  
PH. 713-789-8262  
CELL 713-806-1498

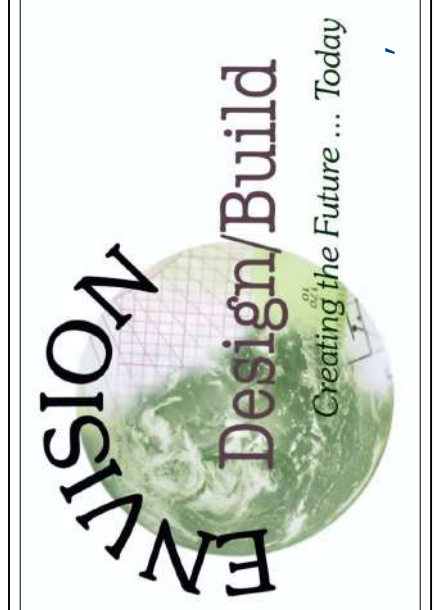




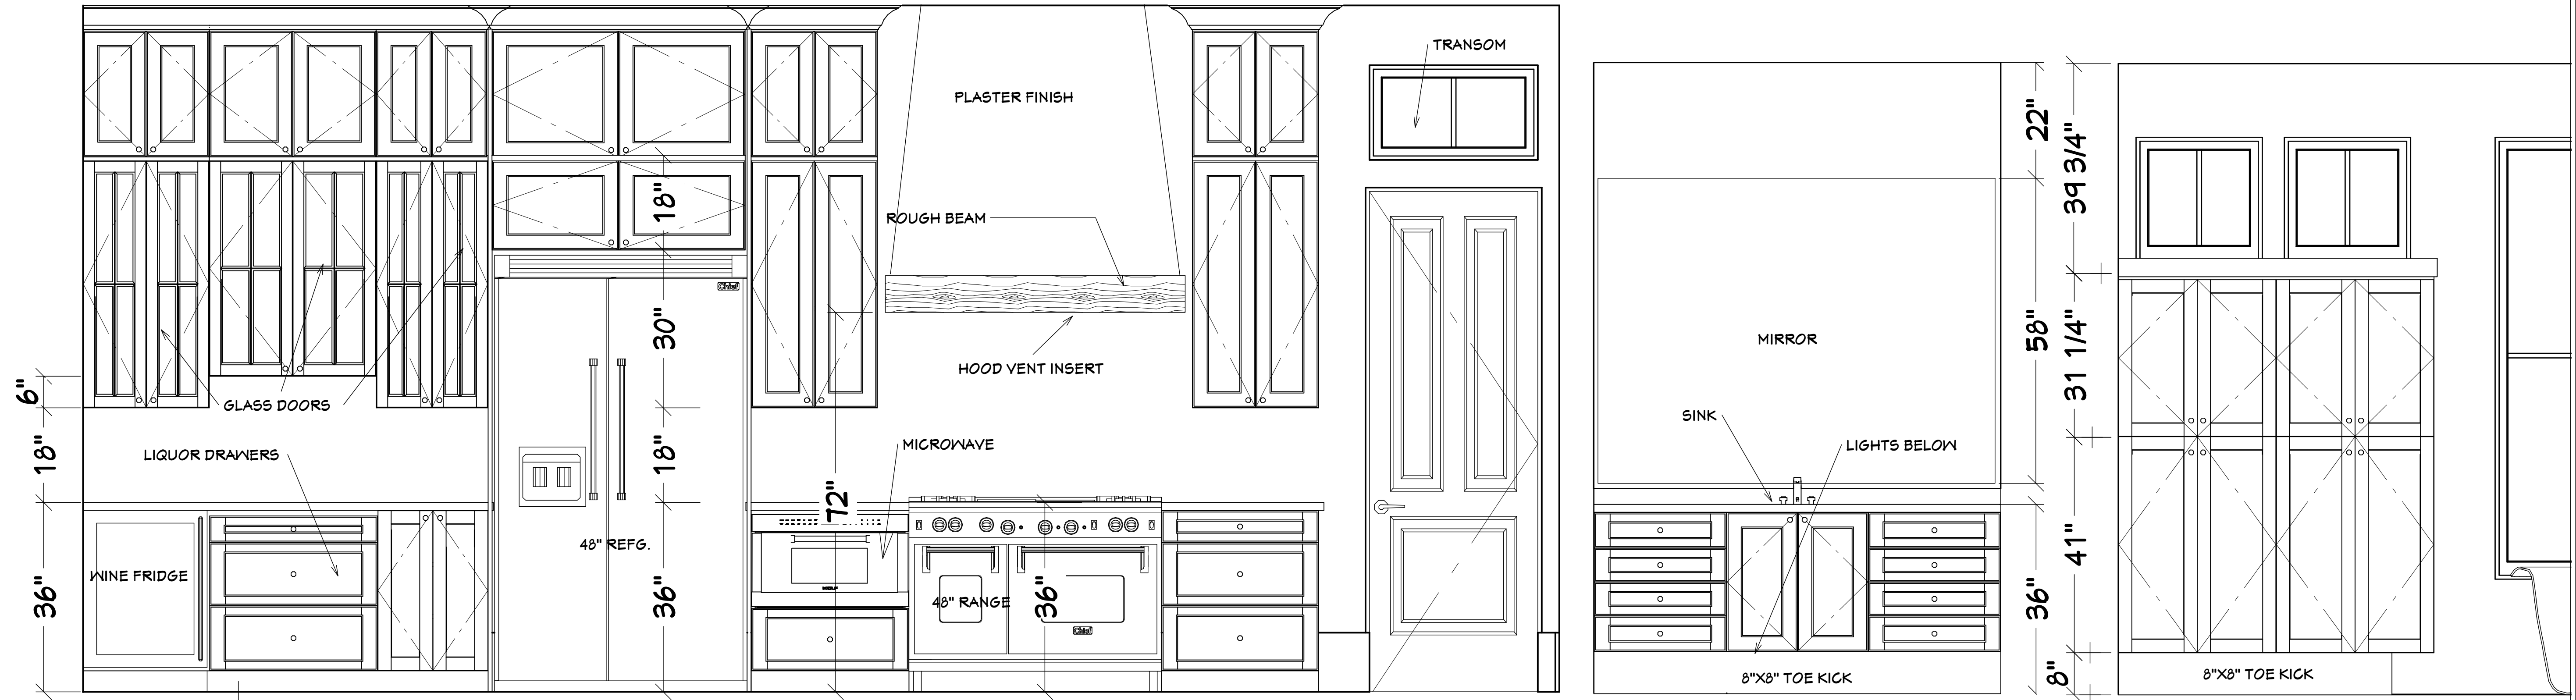

C 1


C 12 (both sides)

C 13

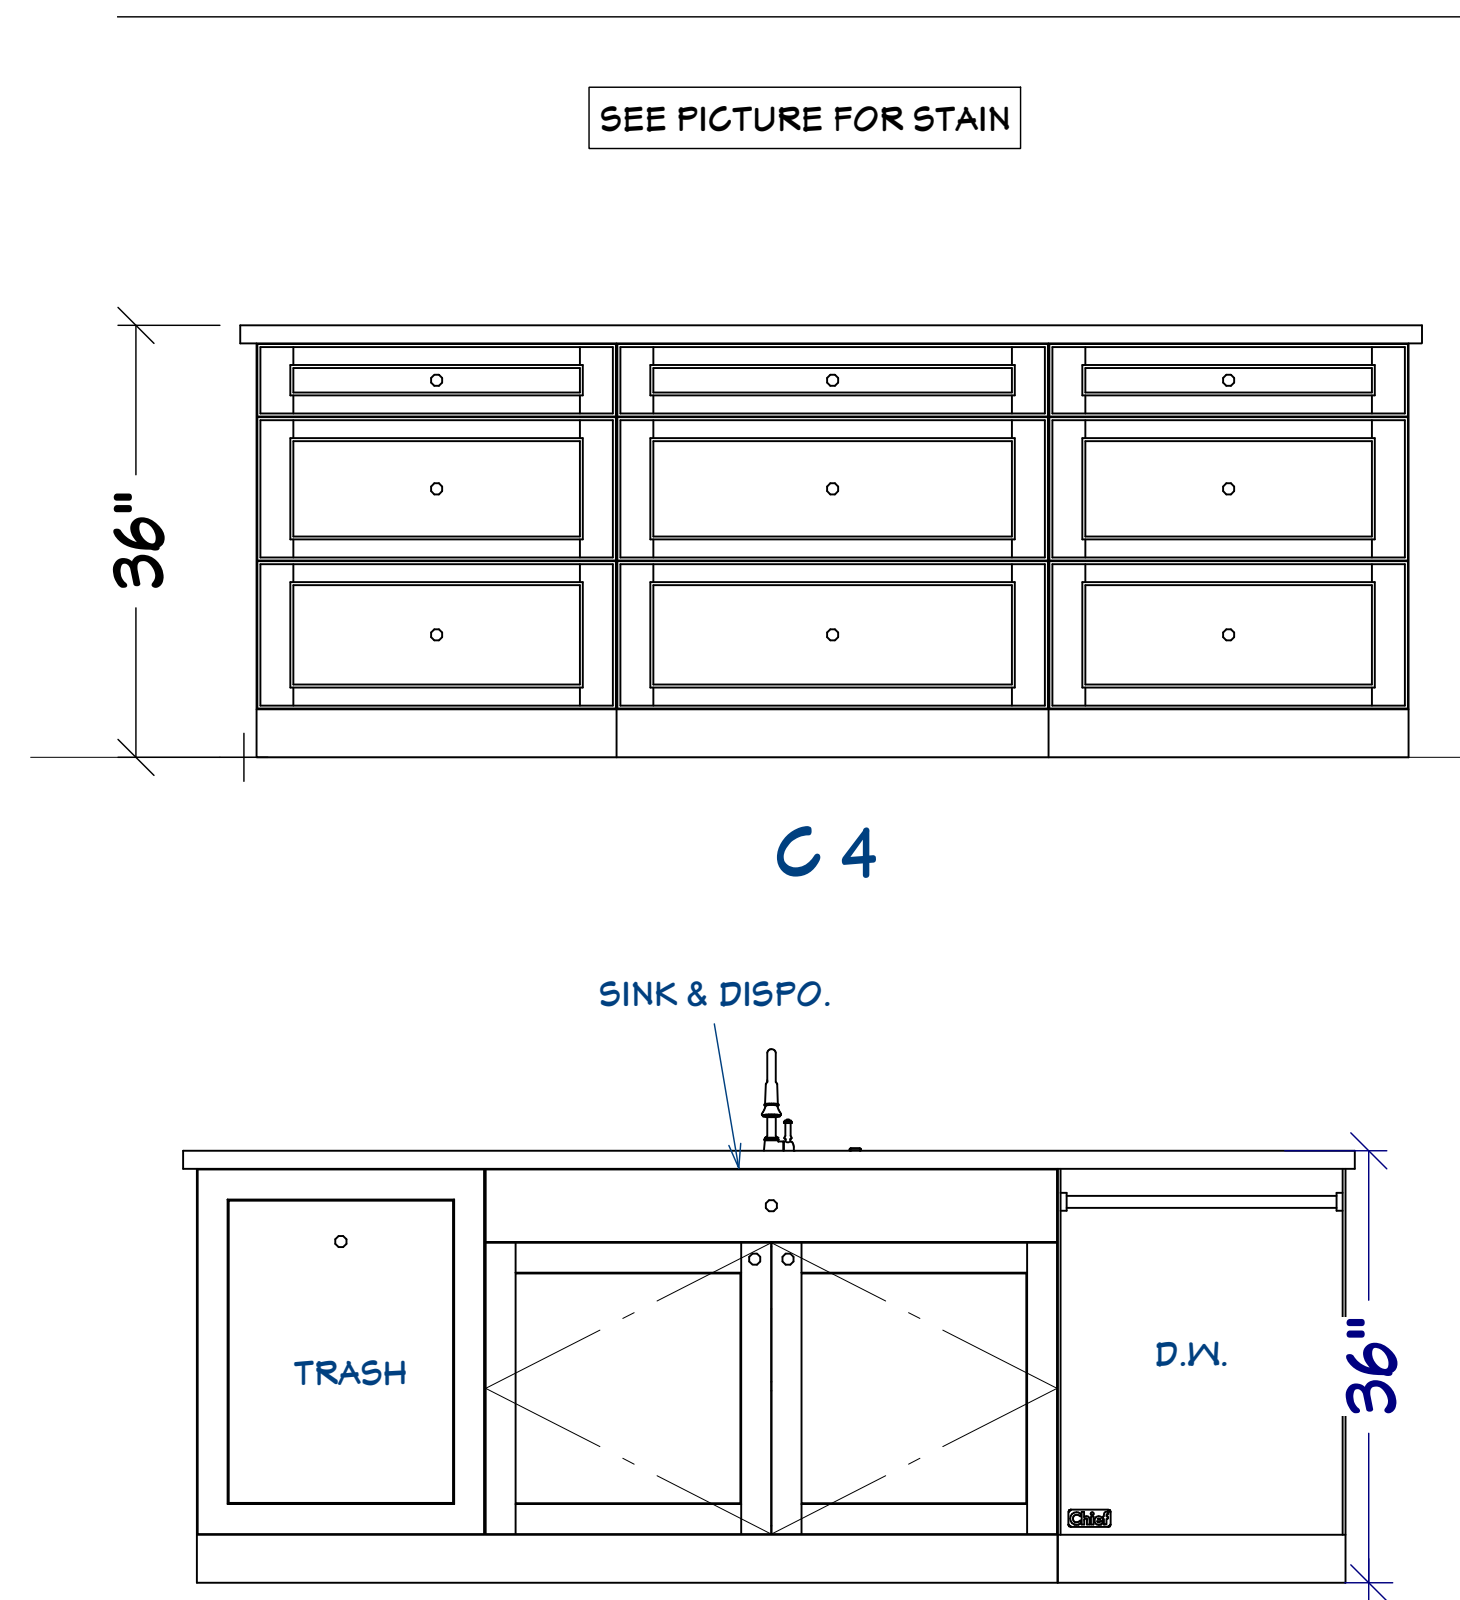


C 4

C 2

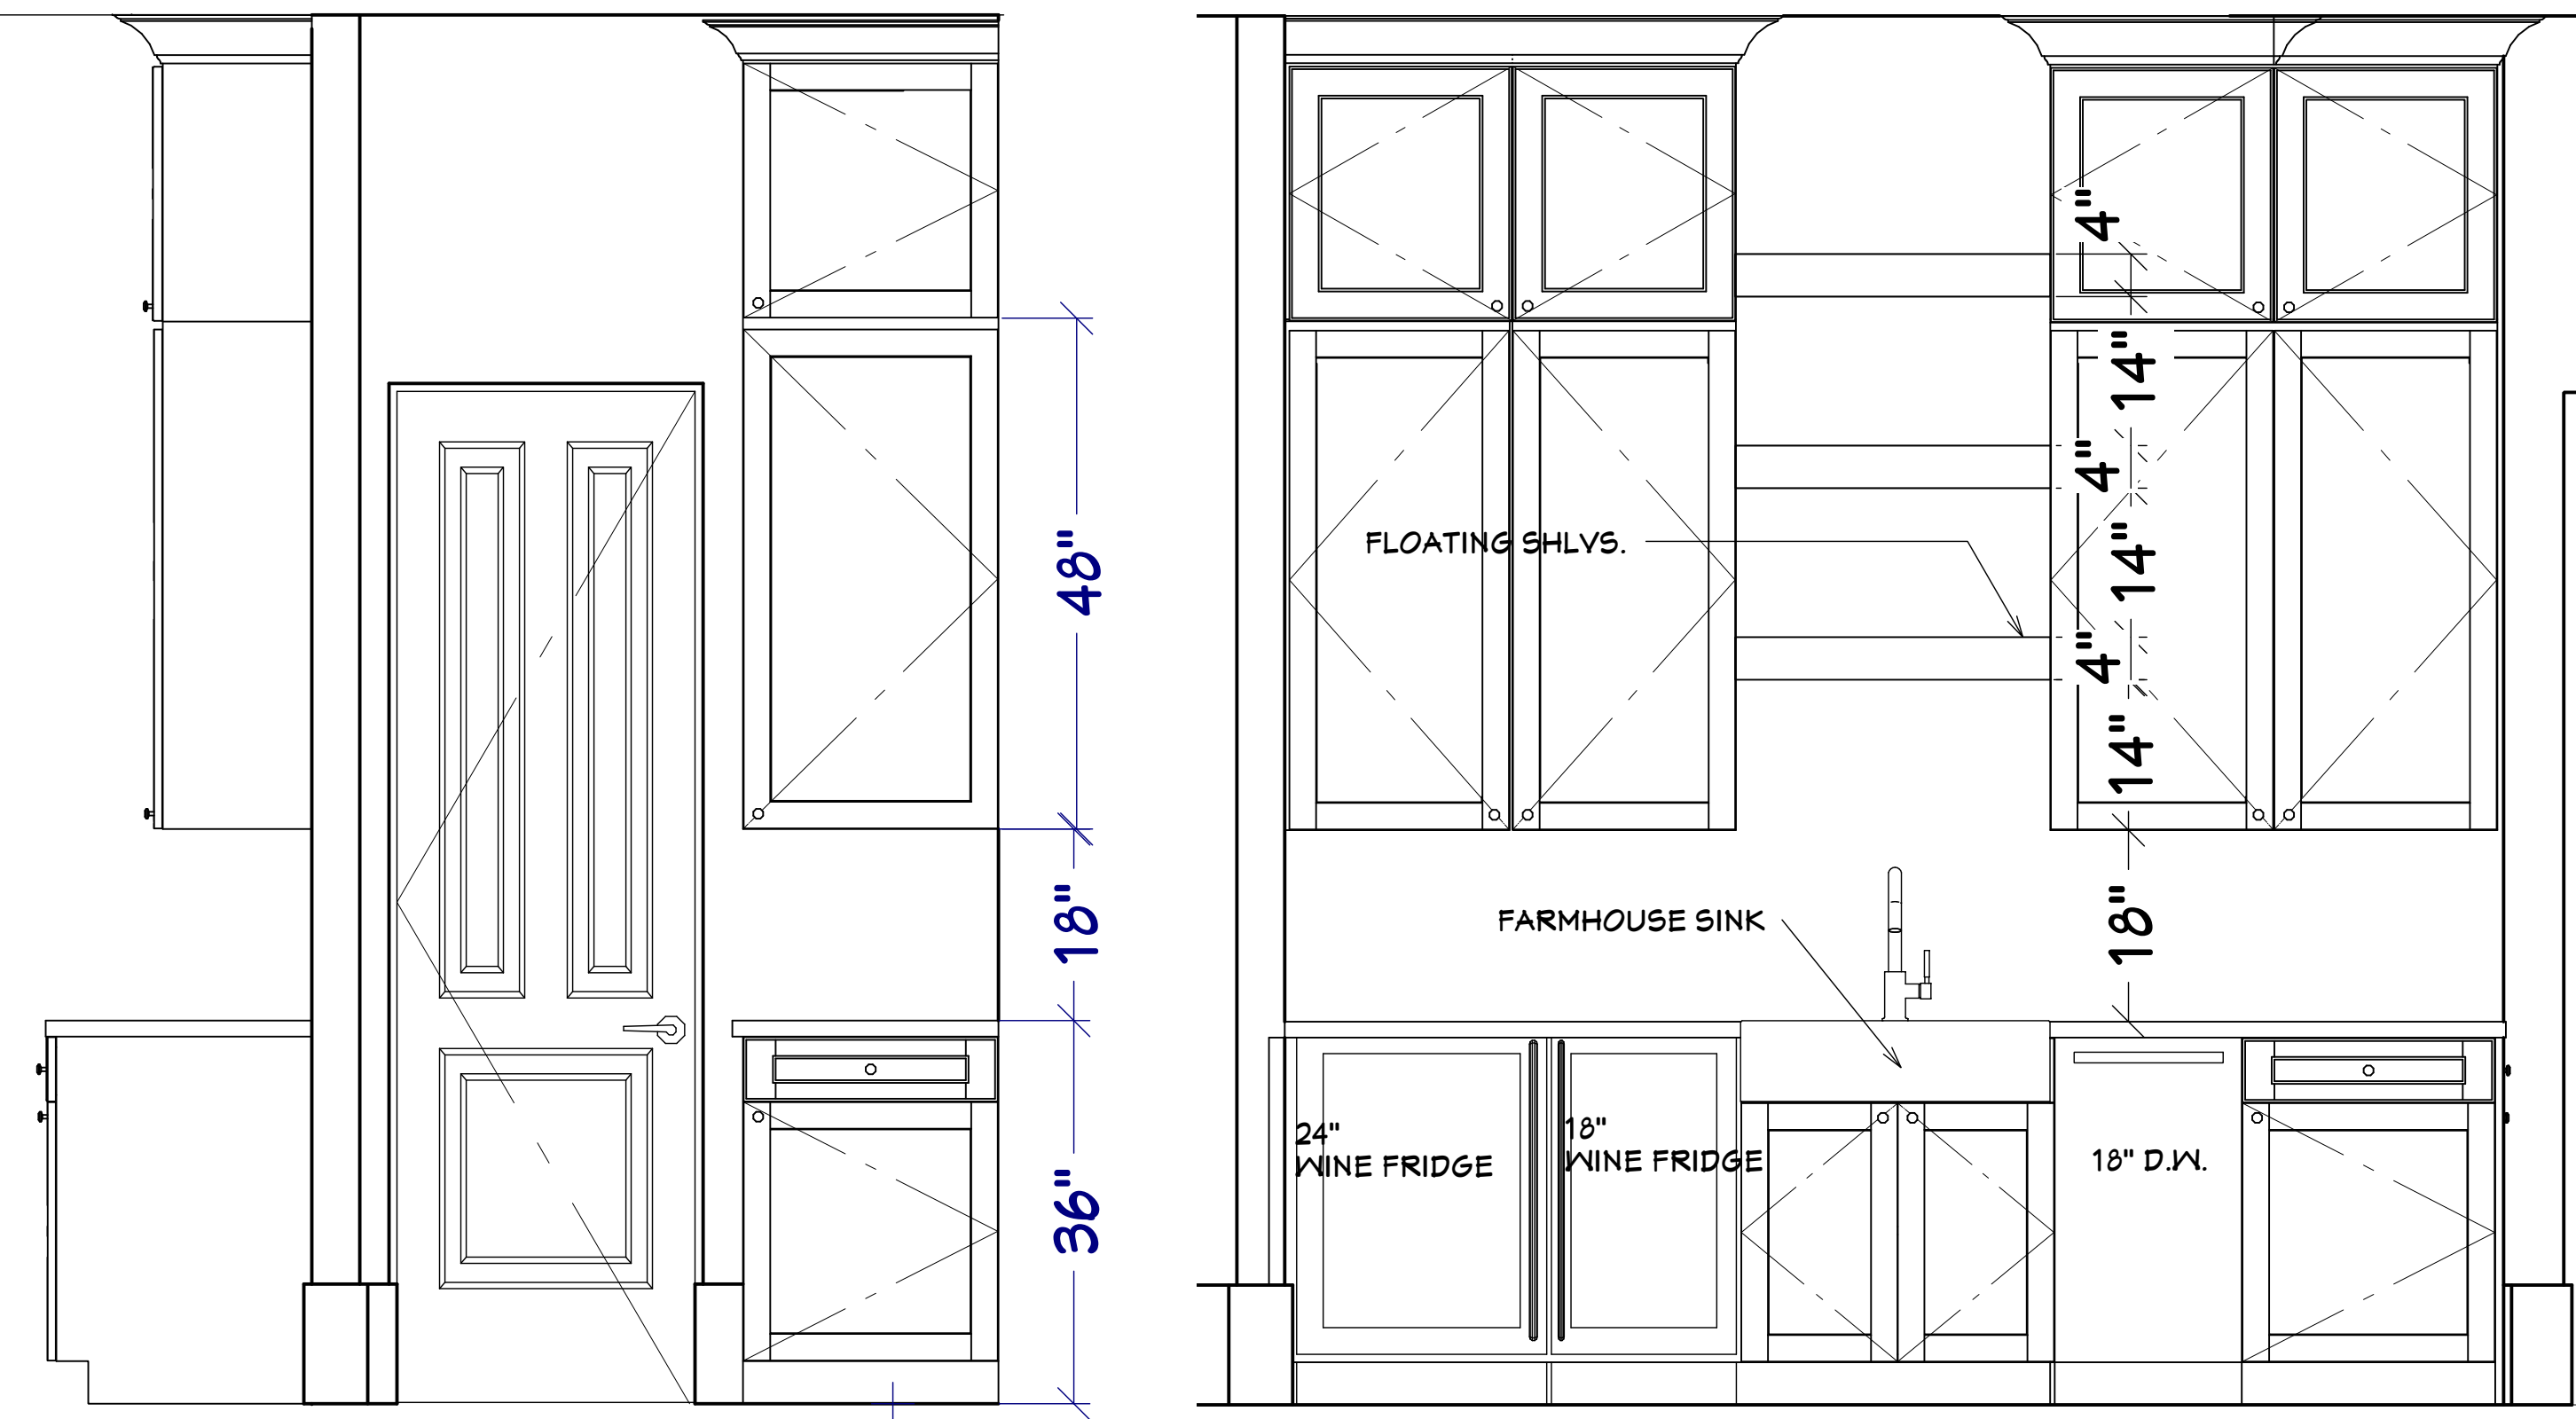


C 3

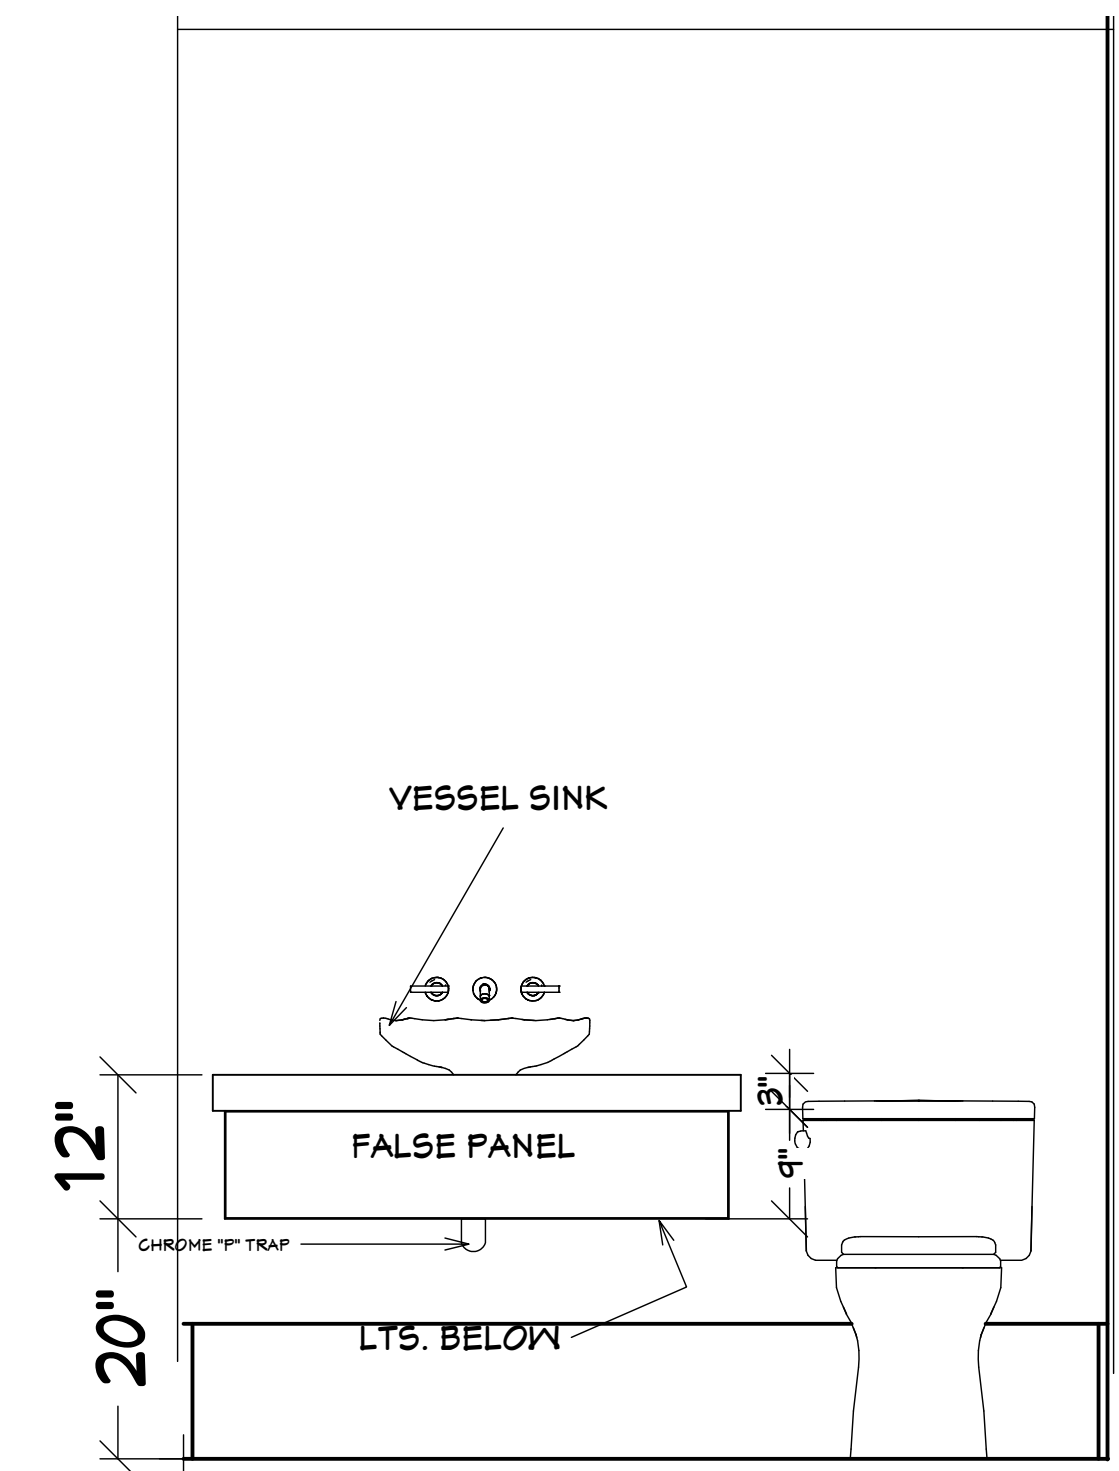

C 9


interior cabinets  
scale 3/4"=1'-0"

800 Wilcrest suite 120  
Houston, Texas 77042  
PH. 713-789-8262  
CELL 713-806-1998

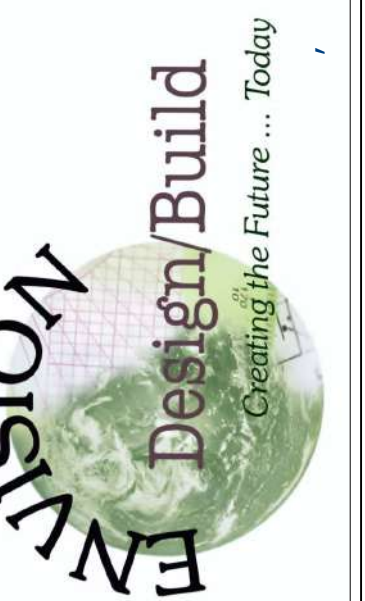


REVISIONS


DATE  
Revision #2  
8-21-2020

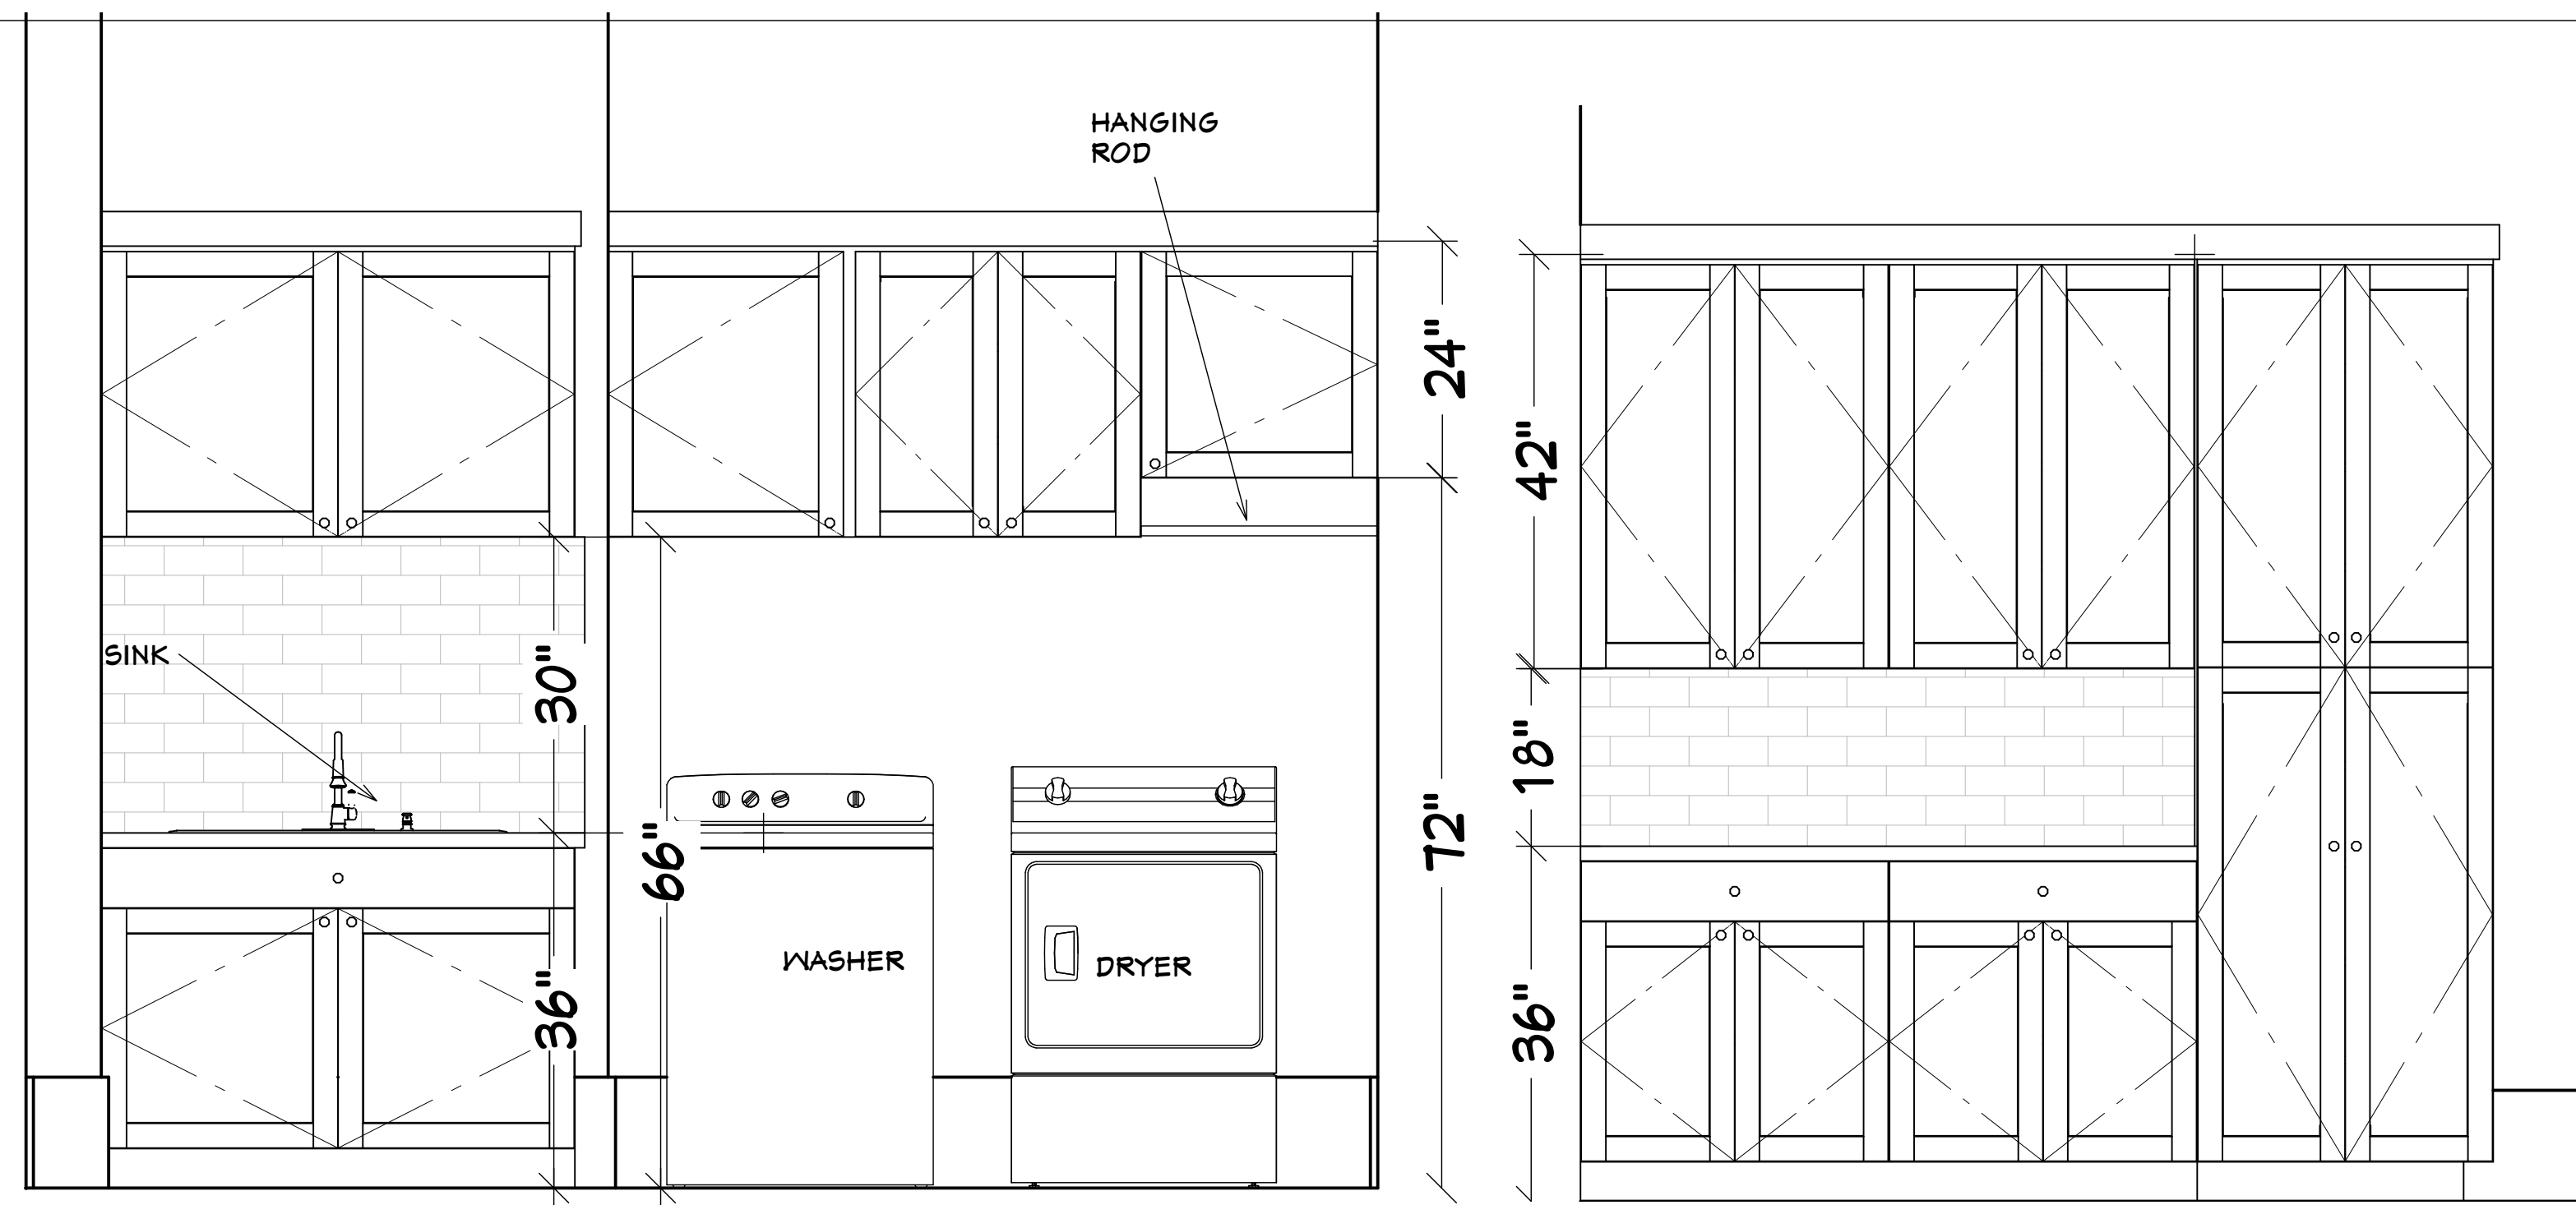


C 10

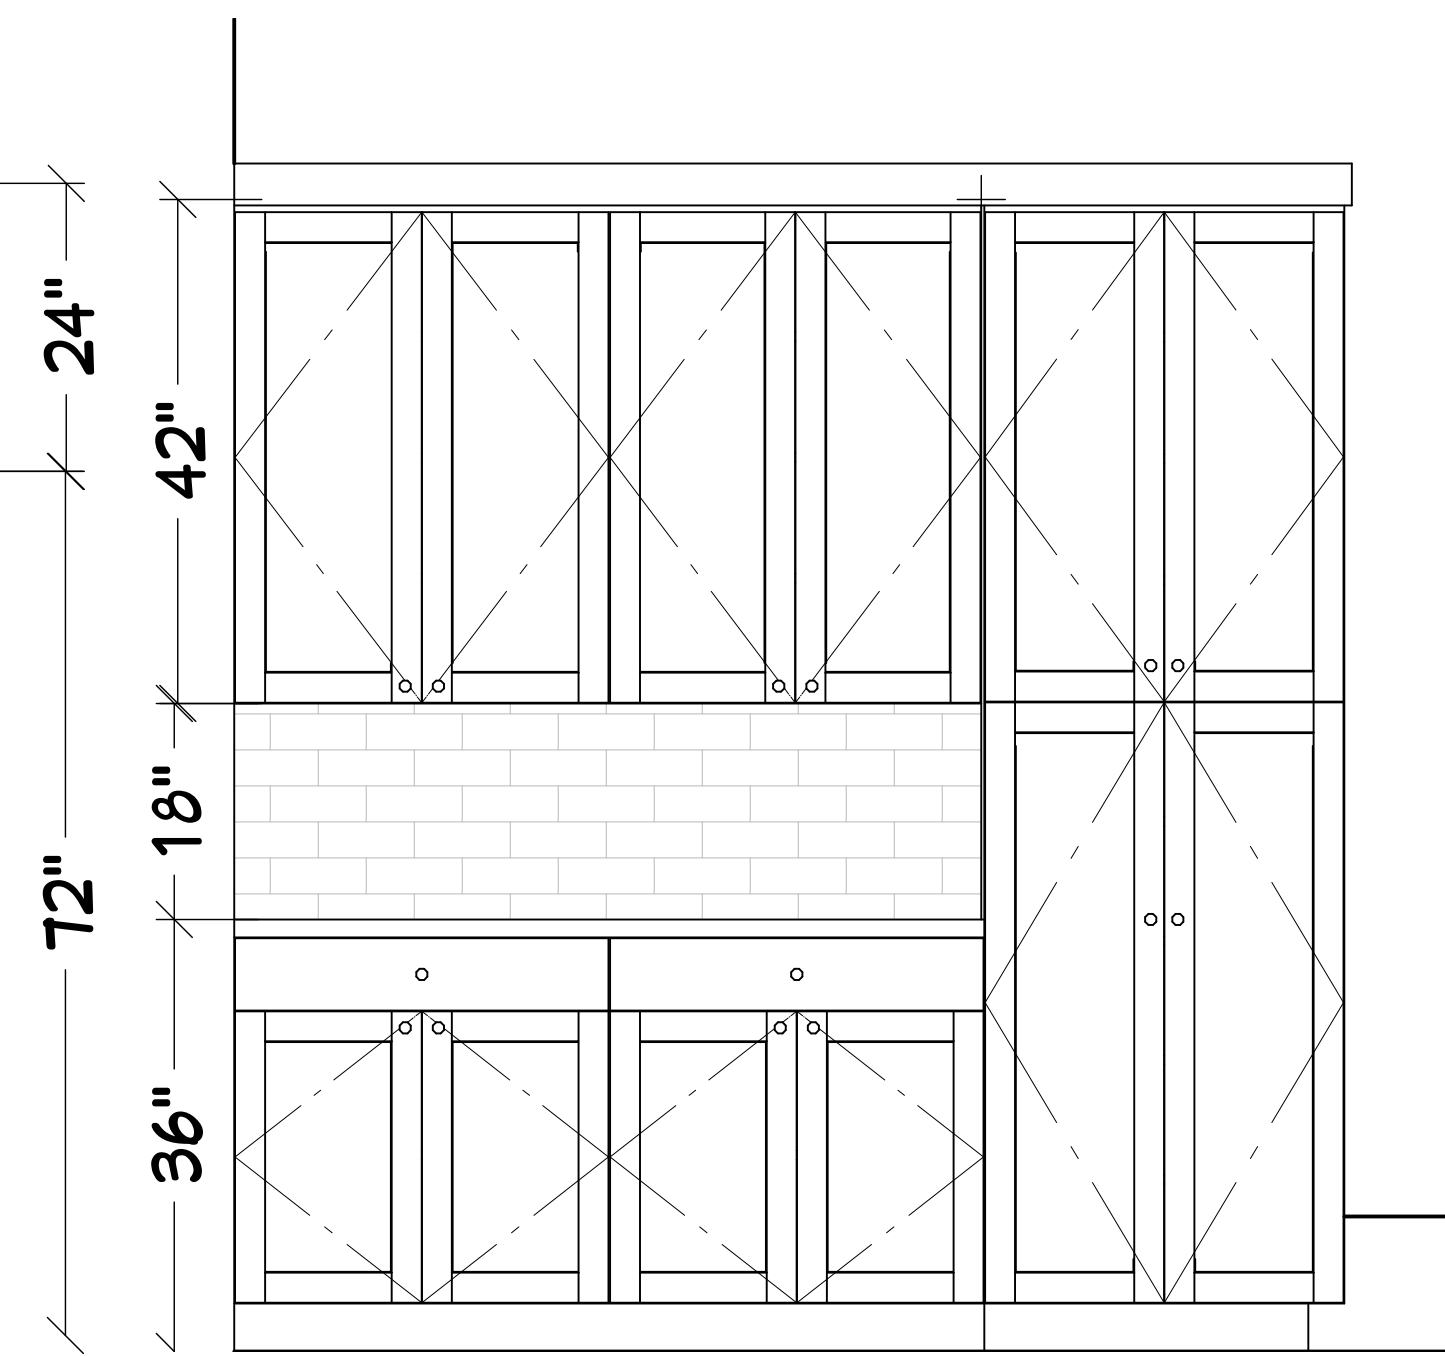

C11

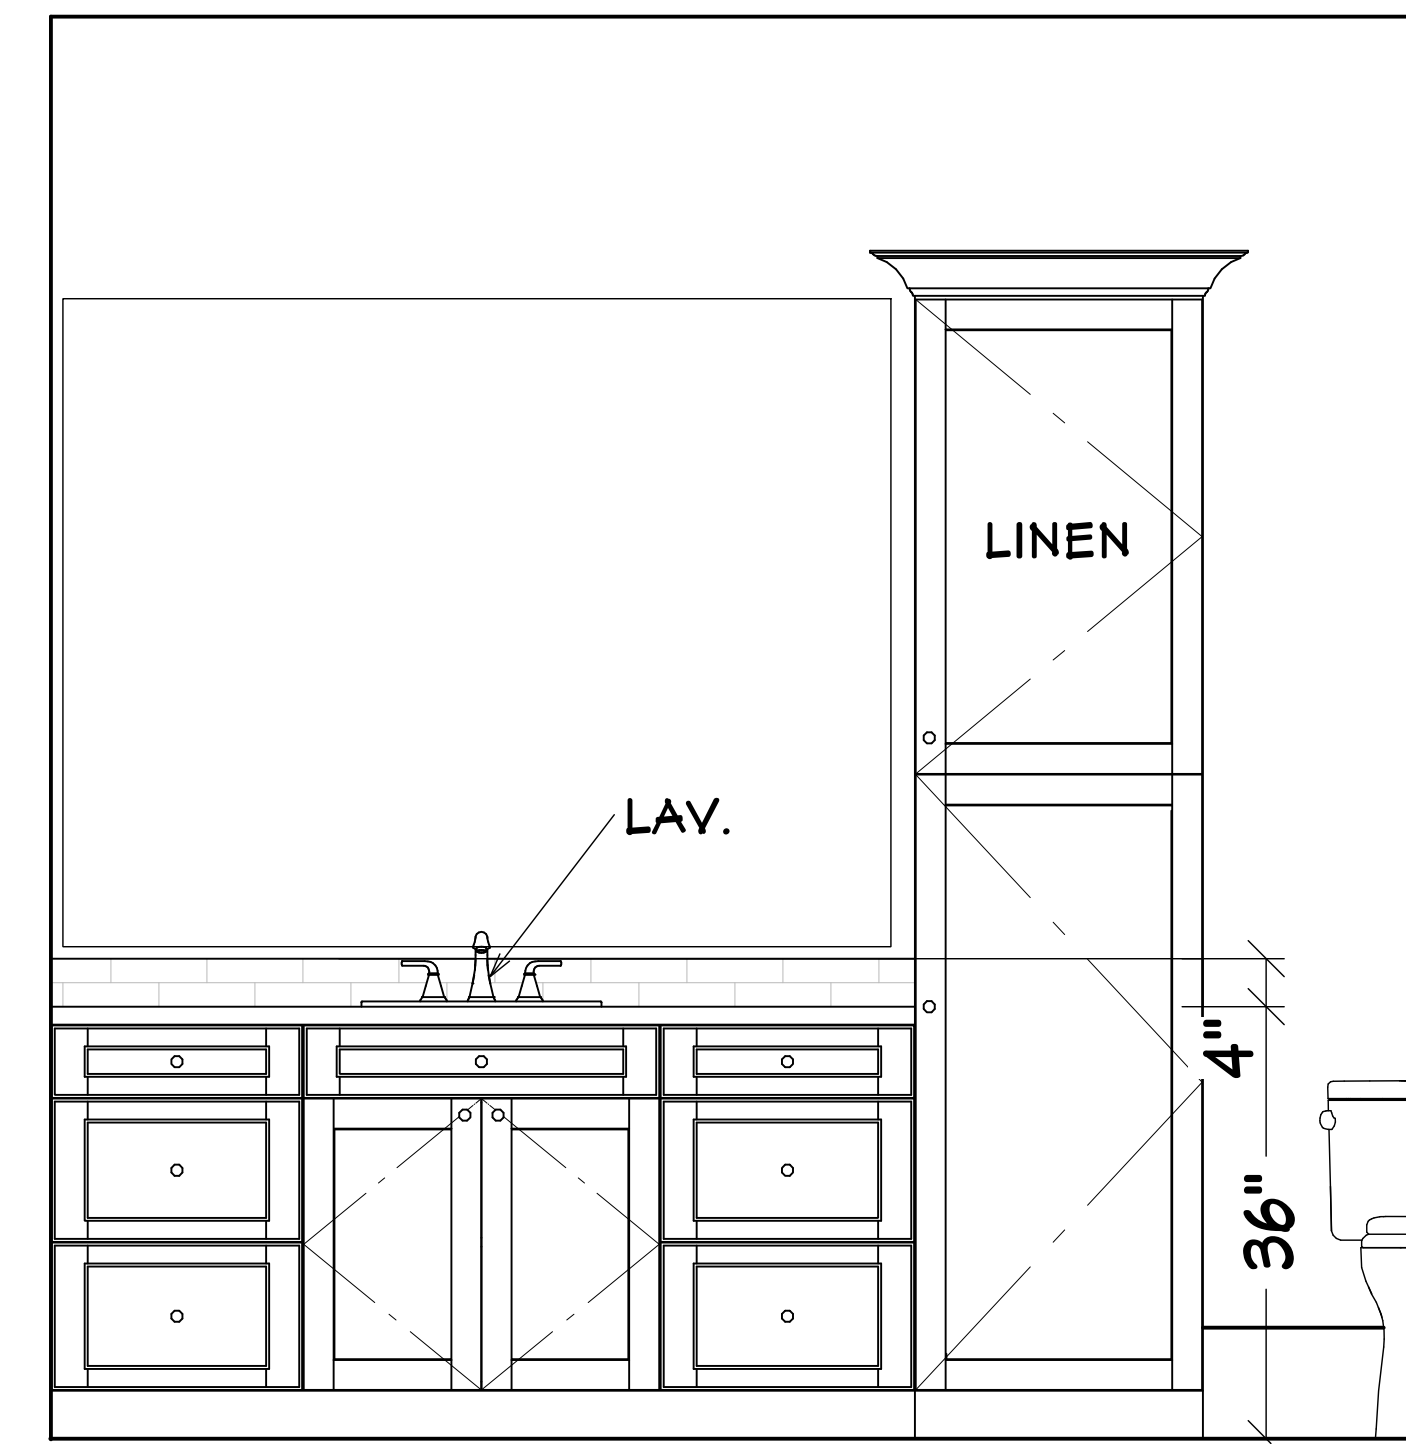


C 14

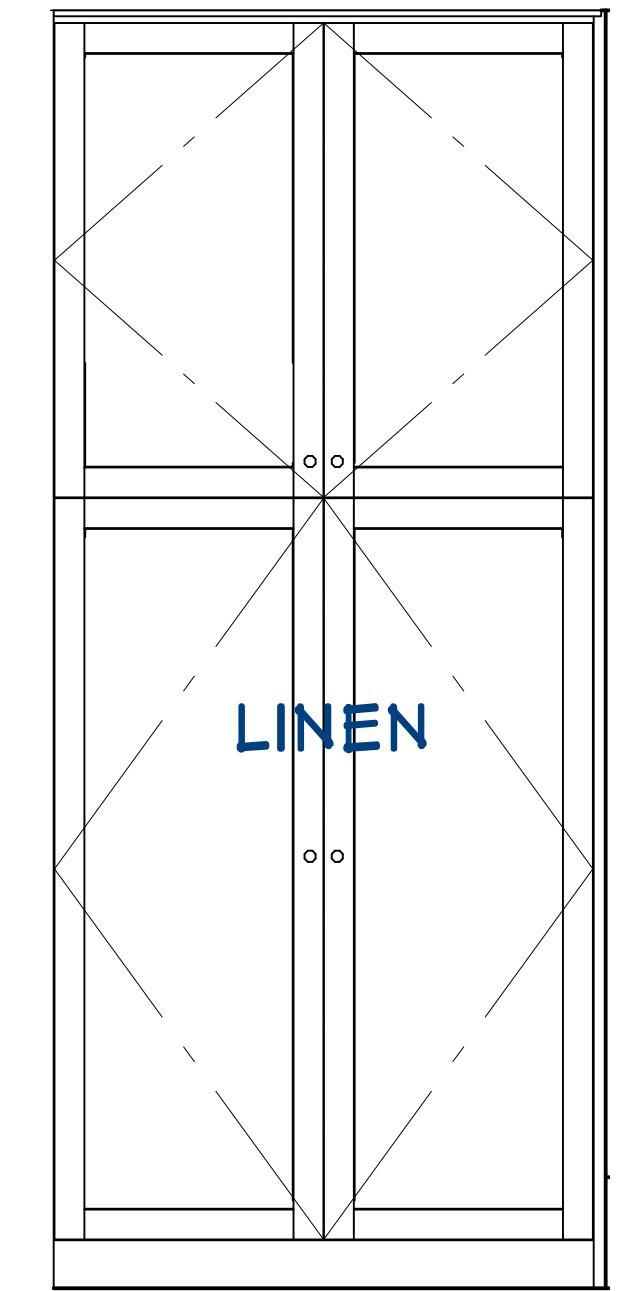


C 17

interior cabinets  
scale 3/4"=1'-0"

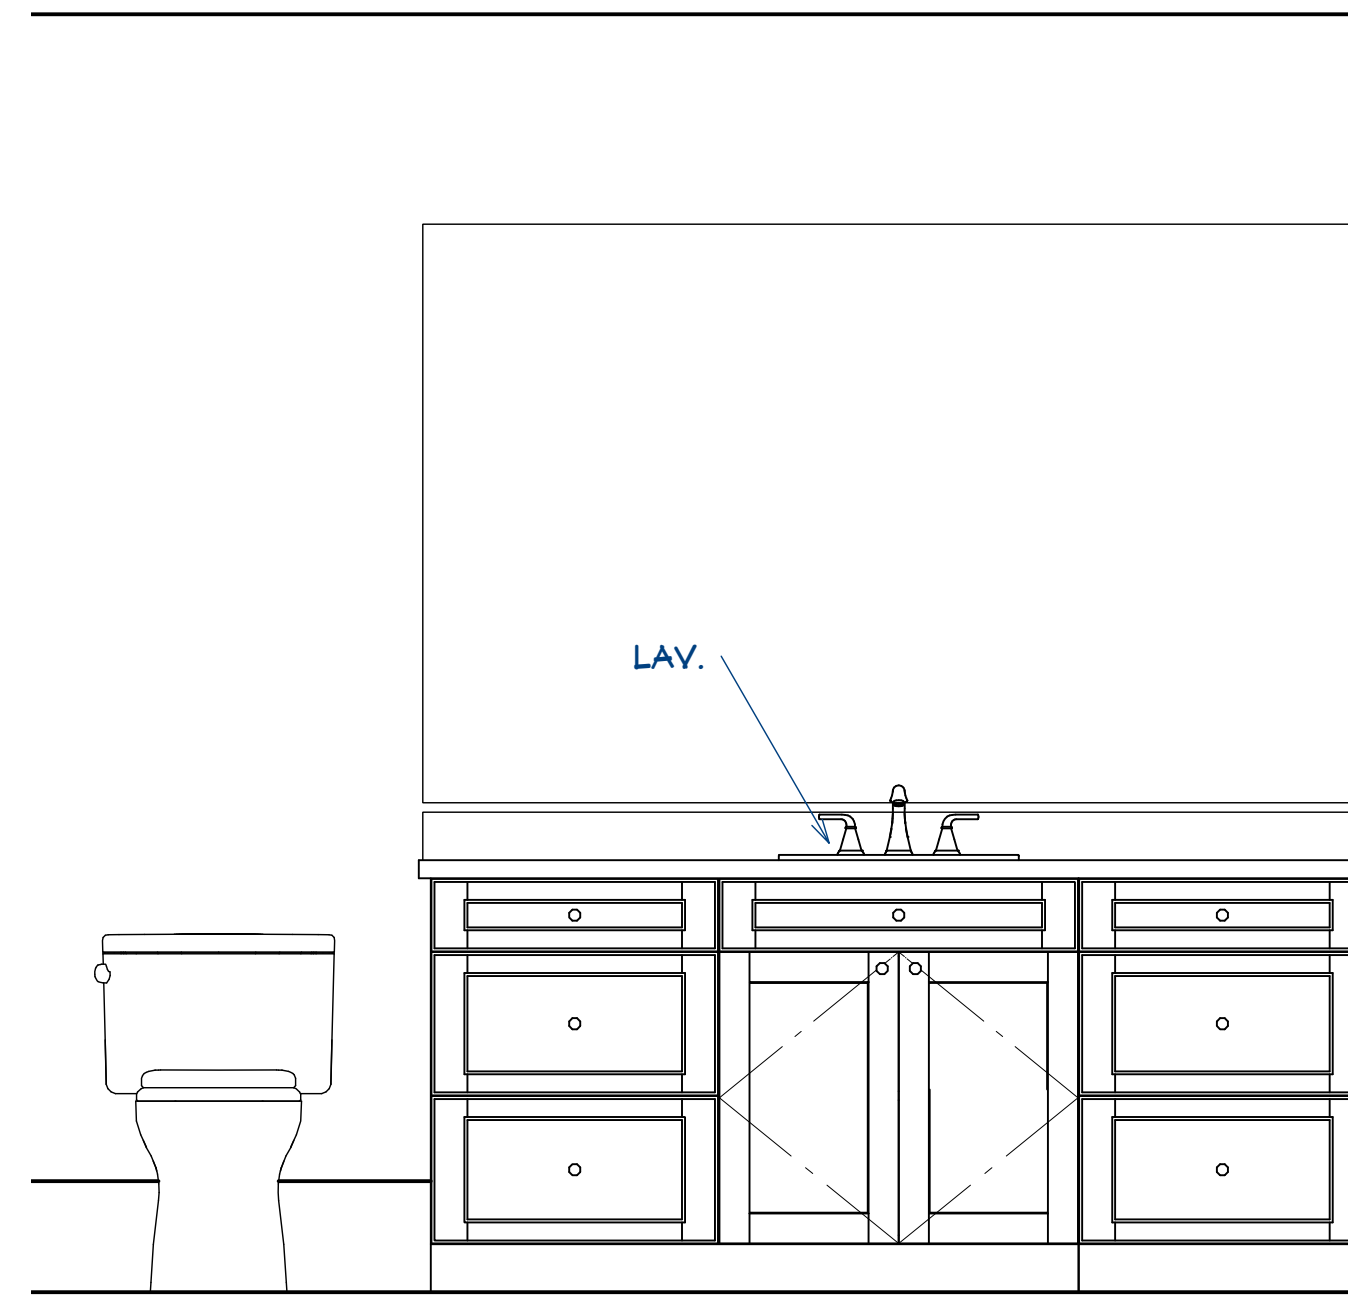

C 15

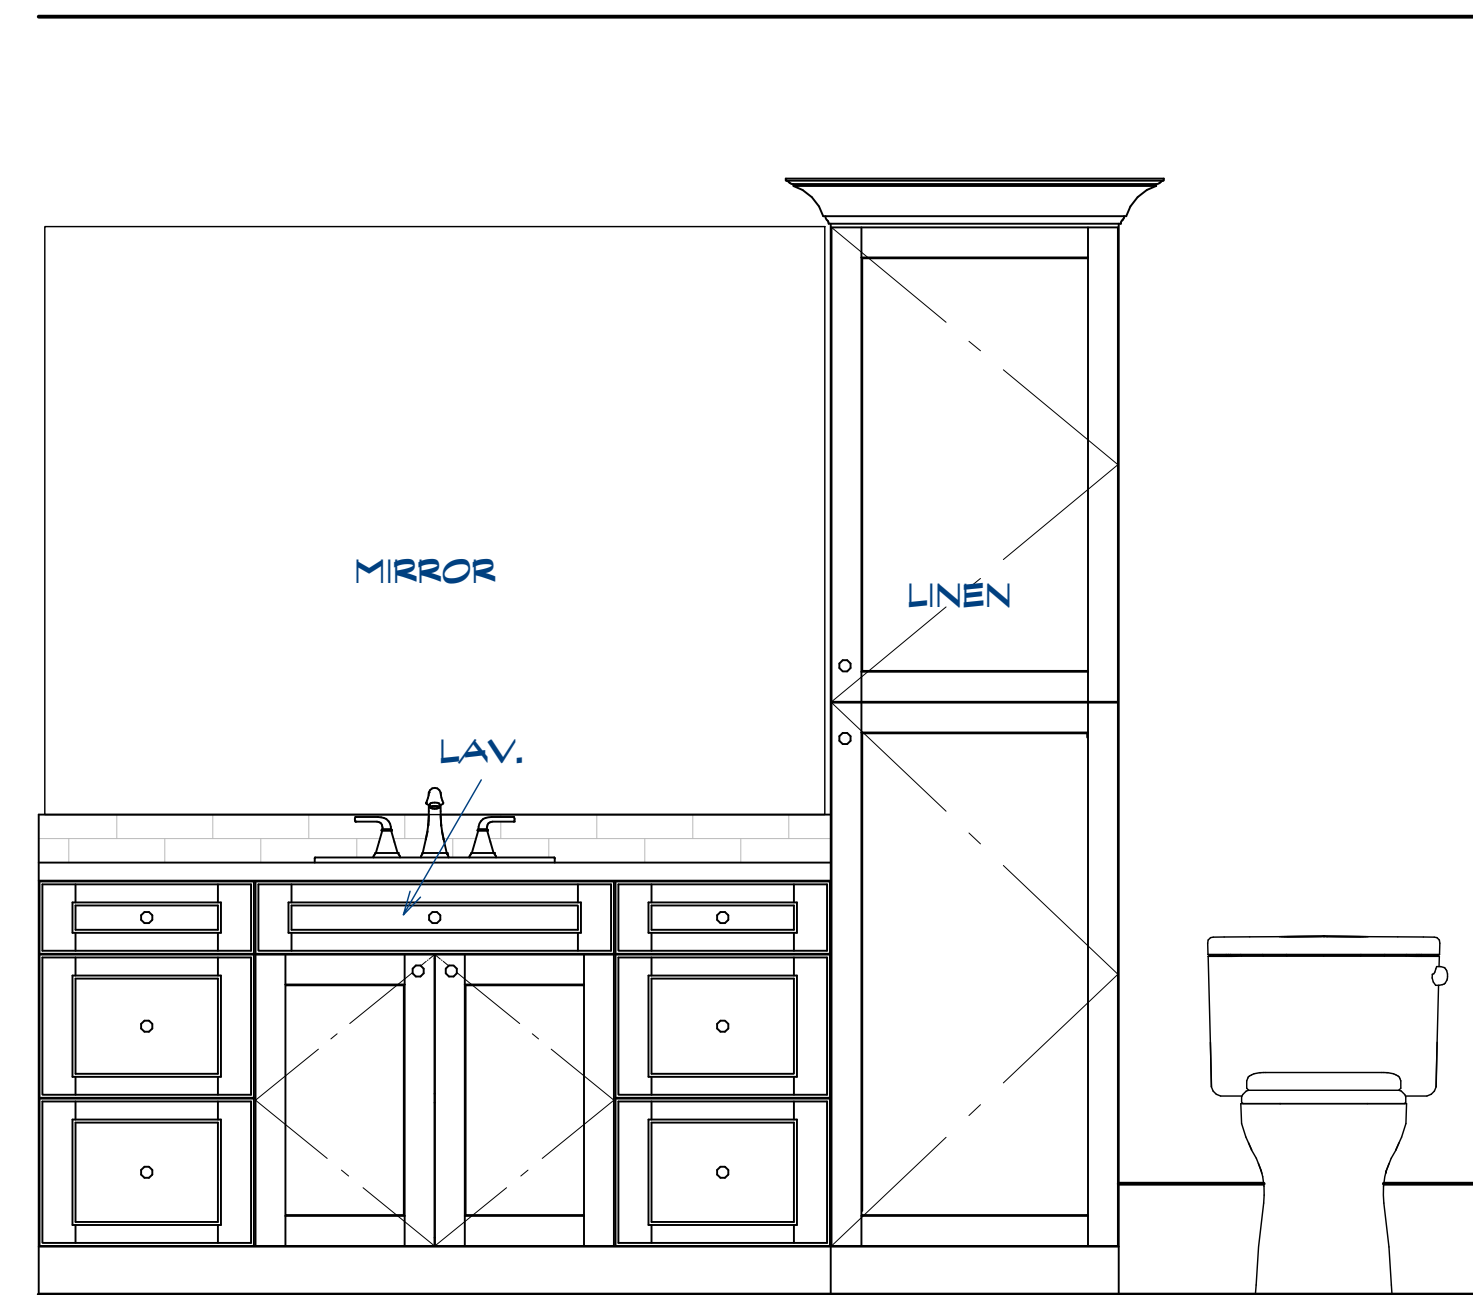


C 16



Elevation 17 no scale




Elevation 19 scale 1/2"=1'-0"

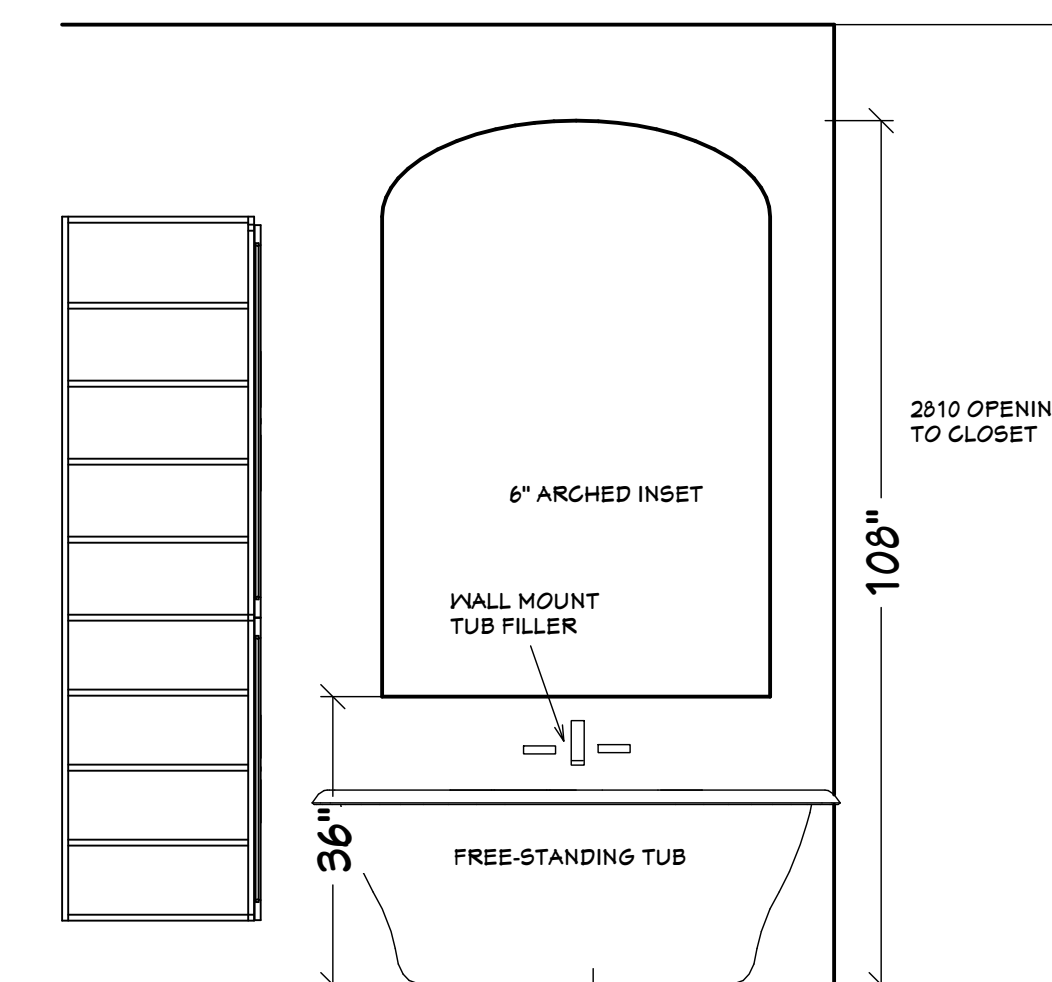

Elevation 18 scale 1/2"=1'-0"

Date:  
12-20-2020

800 Wilcrest suite 120  
Houston, Texas 77042  
PH. 713-789-8262  
CELL 713-806-1998

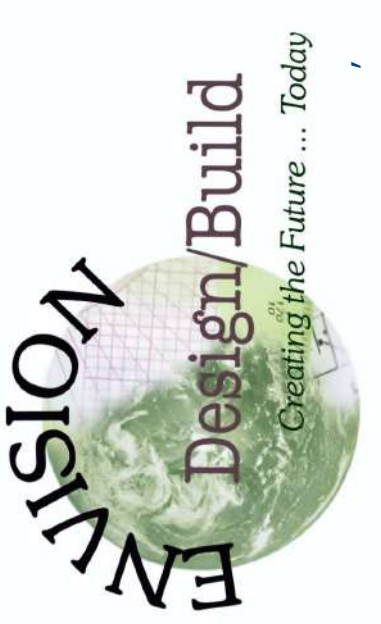

REVISIONS	DATE
Revision #2	8-21-2020